


File: L:\202\121A10111 - LIT Fire Suppression Improvements\Drawings\LIT_FS_IMP-EP101.dwg, Last Save: 5/5/2025 11:34 AM, Last saved by: NAHolland
Last plotted by: Holland, Nicholas A., Plot Style: AECmonochrome.ctb, Plot Scale: 1" = 1', Plot Date: 5/5/2025 12:02 PM, Plotter used: DWG To PDF, pc3

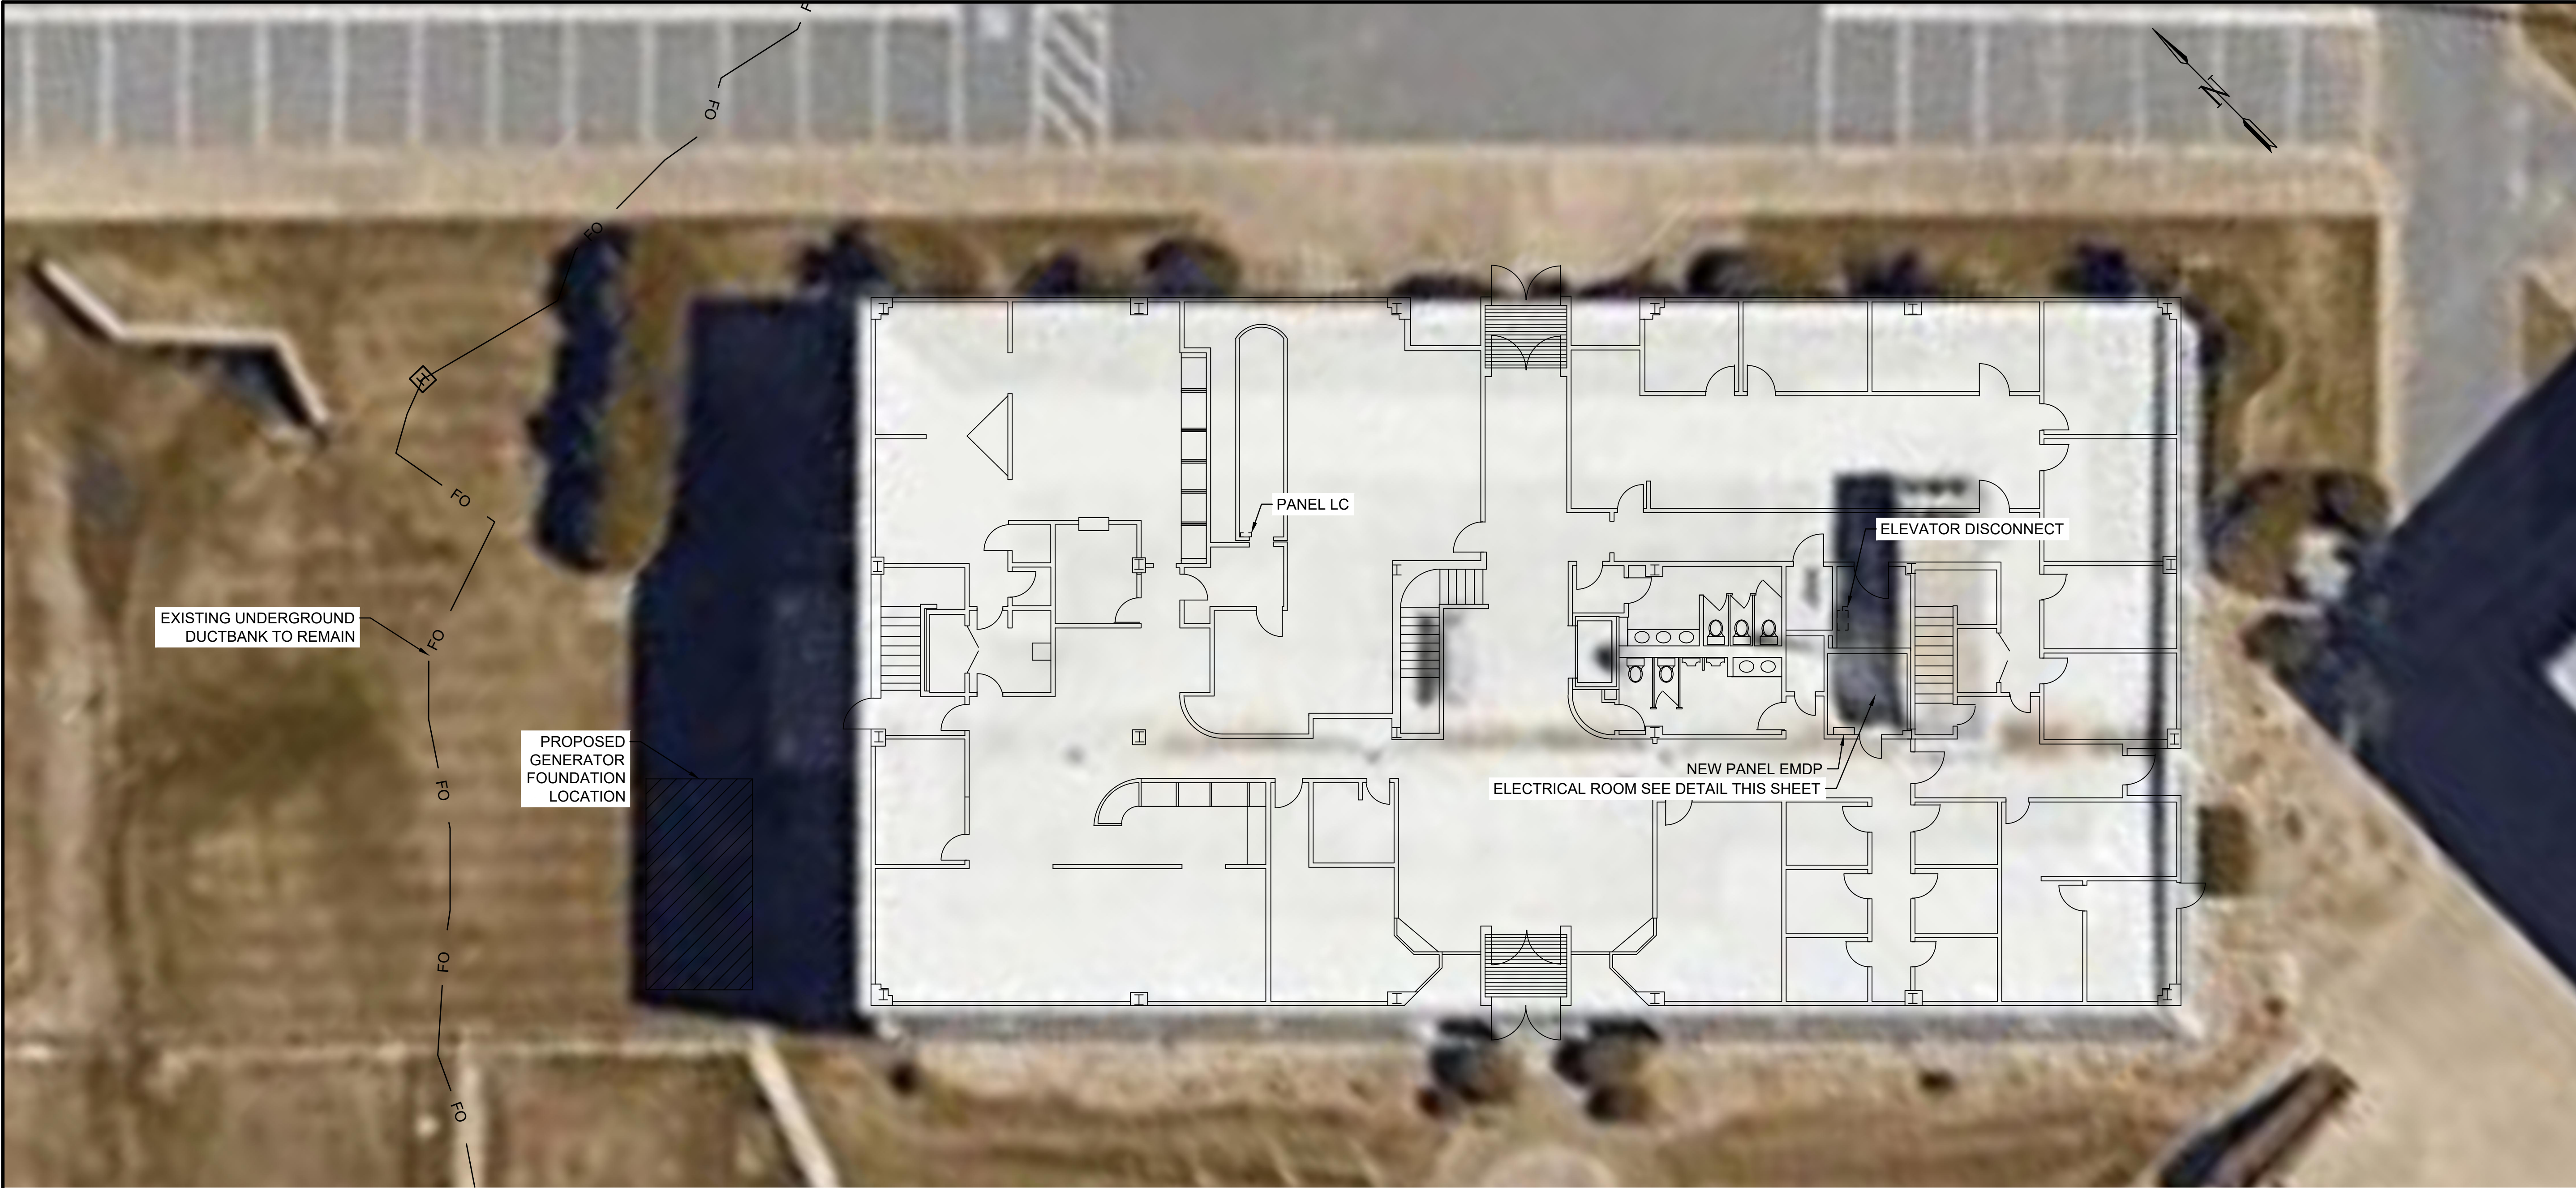


NOTES:

- CONTRACTOR SHALL COORDINATE WITH OWNER AND ENGINEER TO FIELD LOCATE GENERATOR ADJACENT TO AND ON THE WEST SIDE OF THE BUILDING. CONTRACTOR SHALL PROVIDE AND INSTALL NEW 150KW NATURAL GAS GENERATOR TO PROVIDE EMERGENCY BACKUP POWER TO SELECTED PANELS. REFER TO ONE-LINE DIAGRAM FOR MORE INFORMATION.
- CONTRACTOR SHALL INSTALL ALL REQUIRED NATURAL GAS PIPING, REGULATOR, CONDUIT, WIRE, CONTROL SYSTEM, ANNUNCIATOR, AND NEW FOUNDATION FOR GENERATOR AS REQUIRED FOR A FULLY FUNCTIONAL AND OPERATIONAL EMERGENCY GENERATOR SYSTEM. COORDINATE FINAL LOCATION OF REMOTE ANNUNCIATOR PANEL WITH OWNER AND ENGINEER ON-SITE.

1
EP-100

BUILDING 100 - FIRST FLOOR

SCALE: 1" = 10'

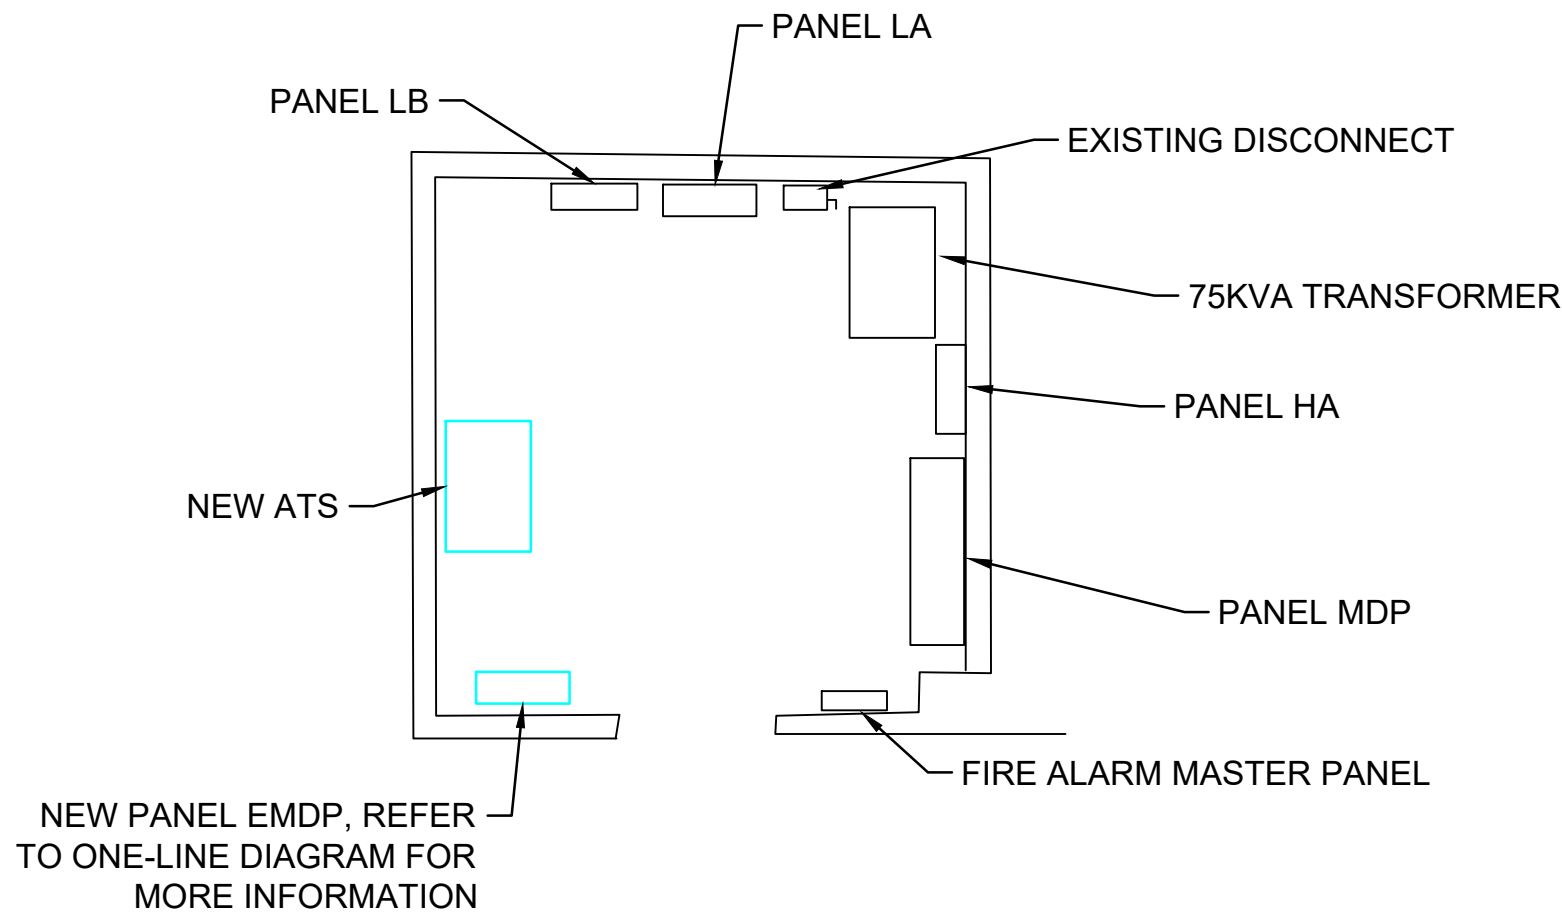

2
EP-100

BUILDING 100 - FIRST FLOOR ELECTRICAL ROOM

SCALE: NONE



© 2025 GARVER, LLC
THIS DOCUMENT, ALONG WITH THE IDEAS AND DESIGNS CONVEYED HEREIN, SHALL BE CONSIDERED INSTRUMENTS OF PROFESSIONAL SERVICE AND ARE PROPERTY OF GARVER, LLC. ANY USE, REPRODUCTION, OR DISTRIBUTION OF THIS DOCUMENT, ALONG WITH THE IDEAS AND DESIGN CONTAINED HEREIN, IS PROHIBITED UNLESS AUTHORIZED IN WRITING BY GARVER, LLC OR EXPLICITLY ALLOWED IN THE GOVERNING PROFESSIONAL SERVICES AGREEMENT FOR THIS WORK.



Digitally Signed 05/02/2025

BY	DATE	DESCRIPTION

BILL AND HILLARY CLINTON
NATIONAL AIRPORT
LITTLE ROCK, AR 72206
FIRE SUPPRESSION
IMPROVEMENTS

BUILDING 100 -
ELECTRICAL 1ST
FLOOR PLAN

JOB NO.: 21A10111
DATE: MAY 2025
DESIGNED BY: NAH
DRAWN BY: ICC

BAR IS ONE INCH ON
ORIGINAL DRAWING
0 1"
IF NOT ONE INCH ON THIS SHEET,
ADJUST SCALES ACCORDINGLY.

DRAWING NUMBER
EP-100