



File: L:\202\12\A10111 - LIT Fire Suppression Improvements\Drawings\LIT_FS_IMP-EP101.dwg, Last Save: 5/5/2025 11:34 AM, Last saved by: NAHolland
Last plotted by: Holland, Nicholas A., Plot Style: AECmonochrome.ctb, Plot Scale: 1:1, Plot Date: 5/5/2025 12:01 PM, Plotter used: DWG To PDF, pc3

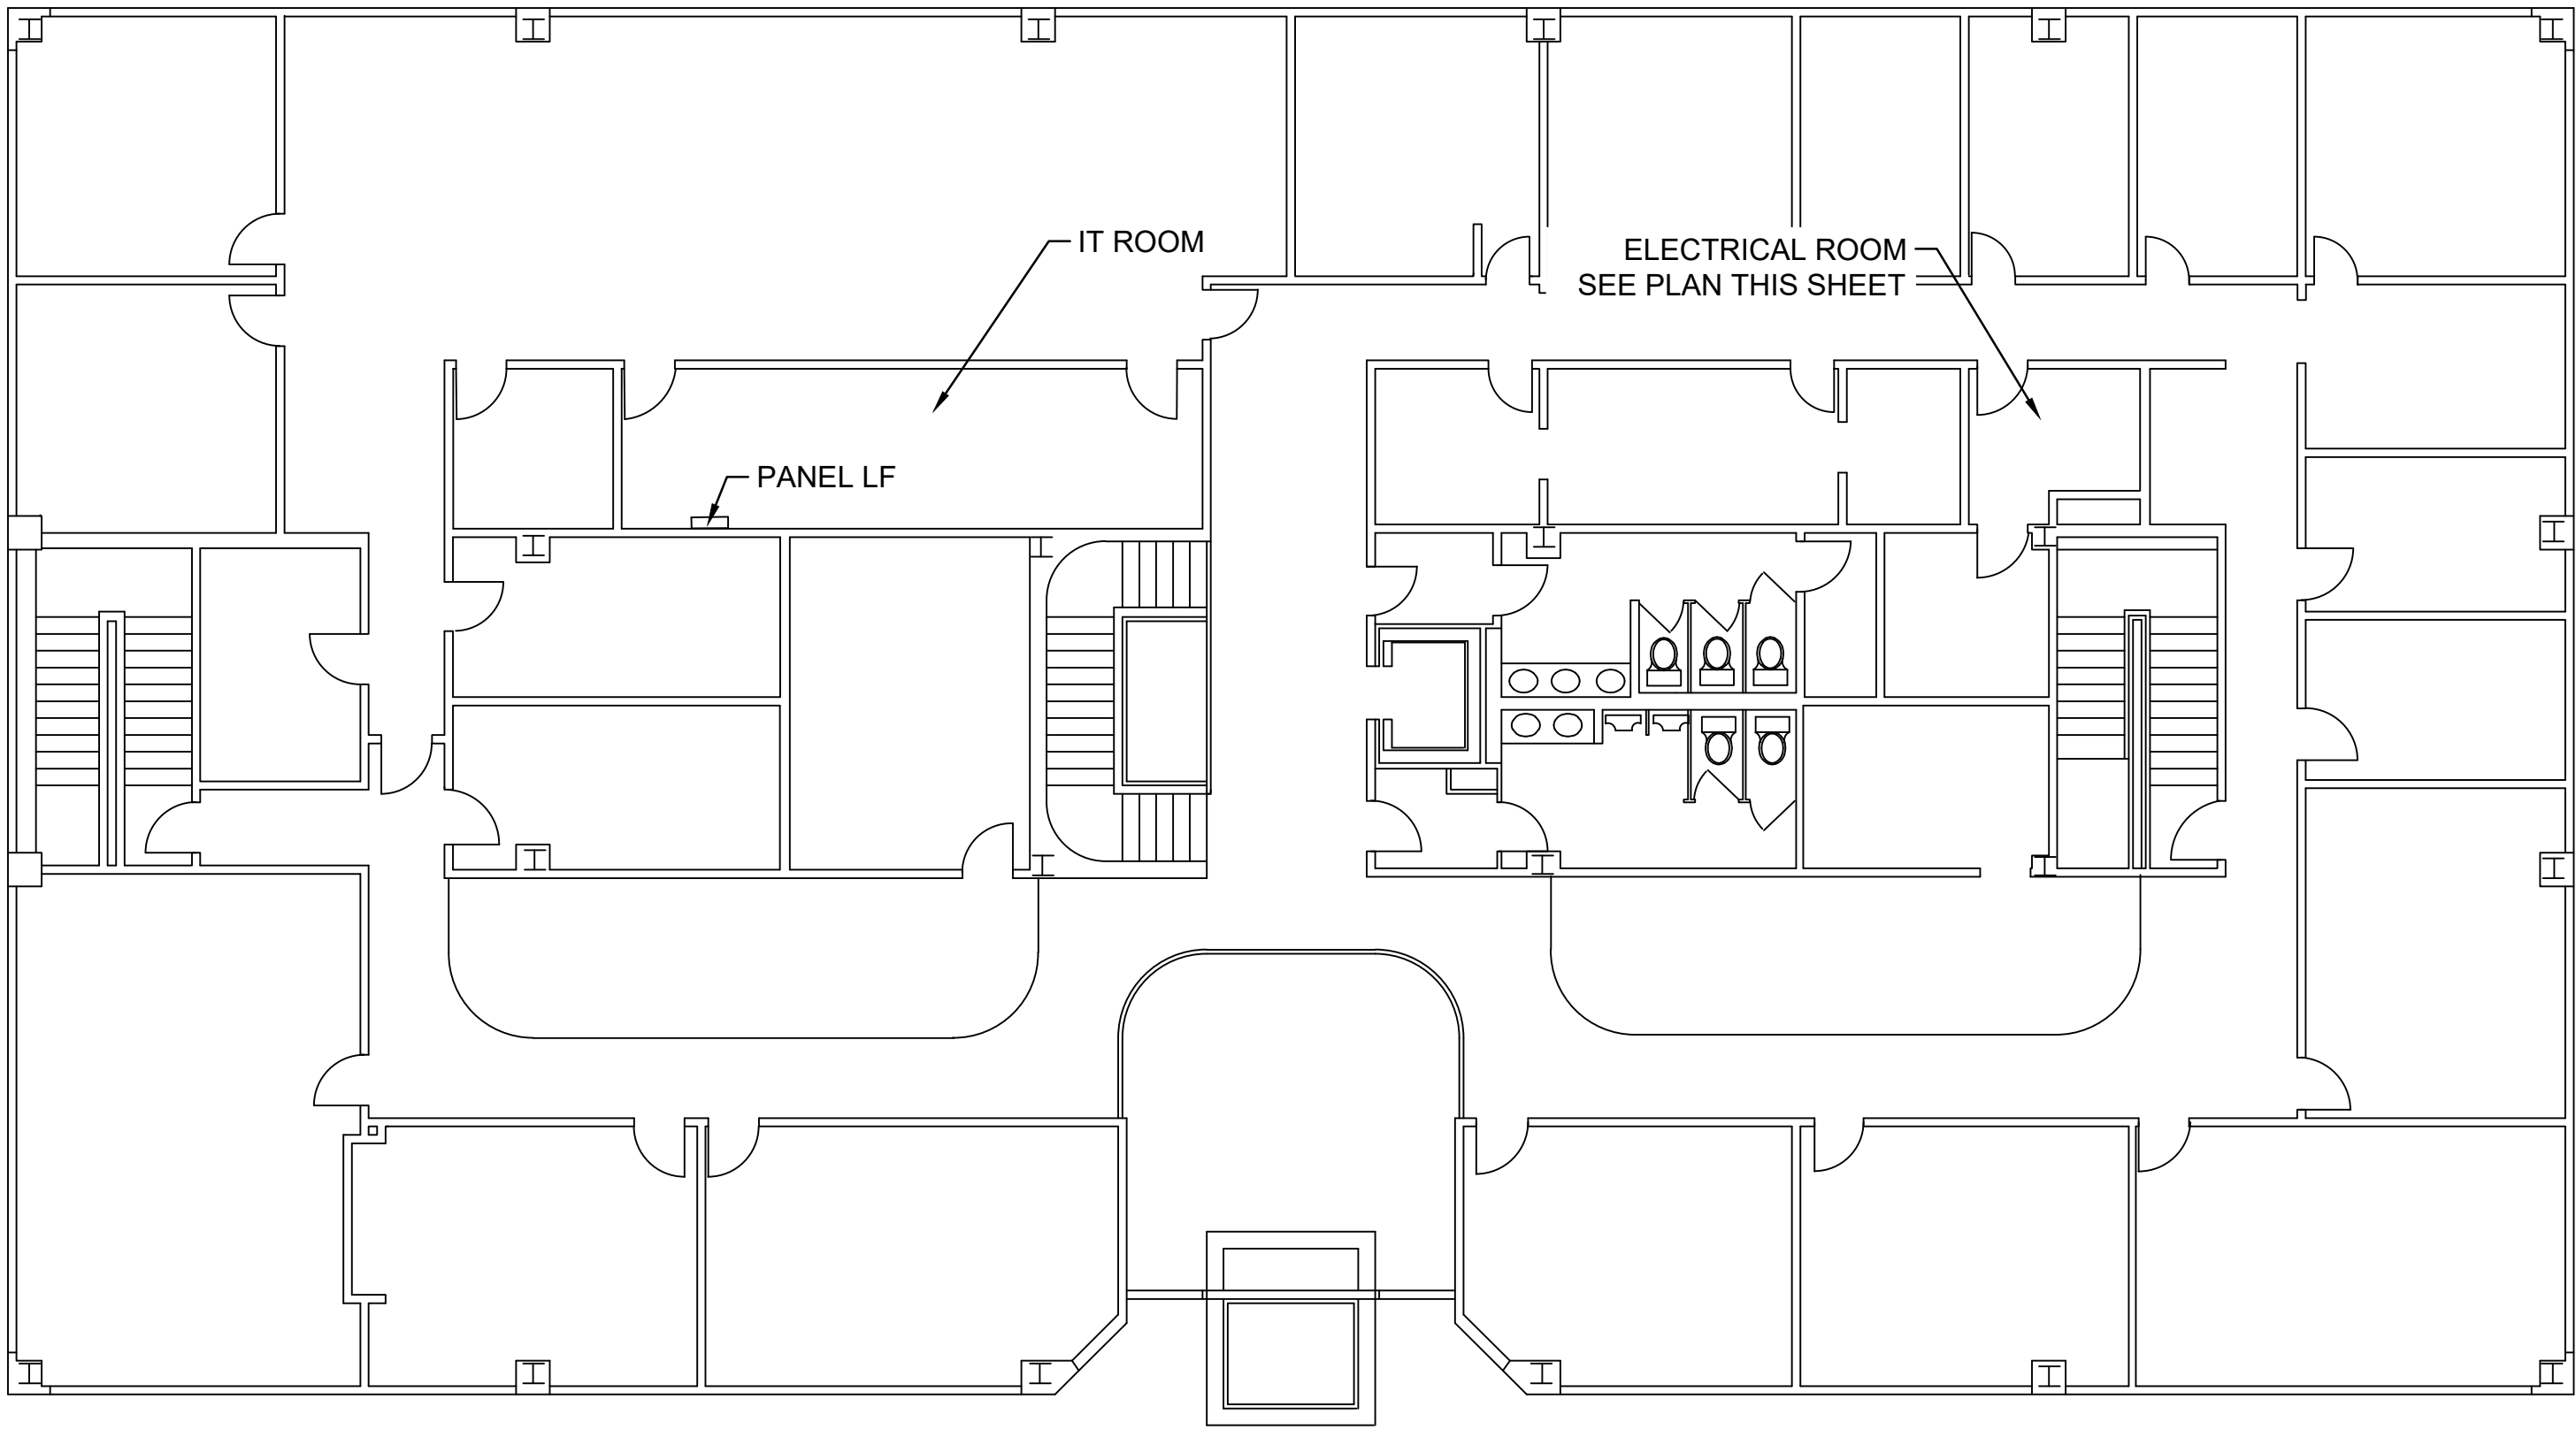

1
EP-101

BUILDING 100 - SECOND FLOOR


SCALE: 1" = 10'

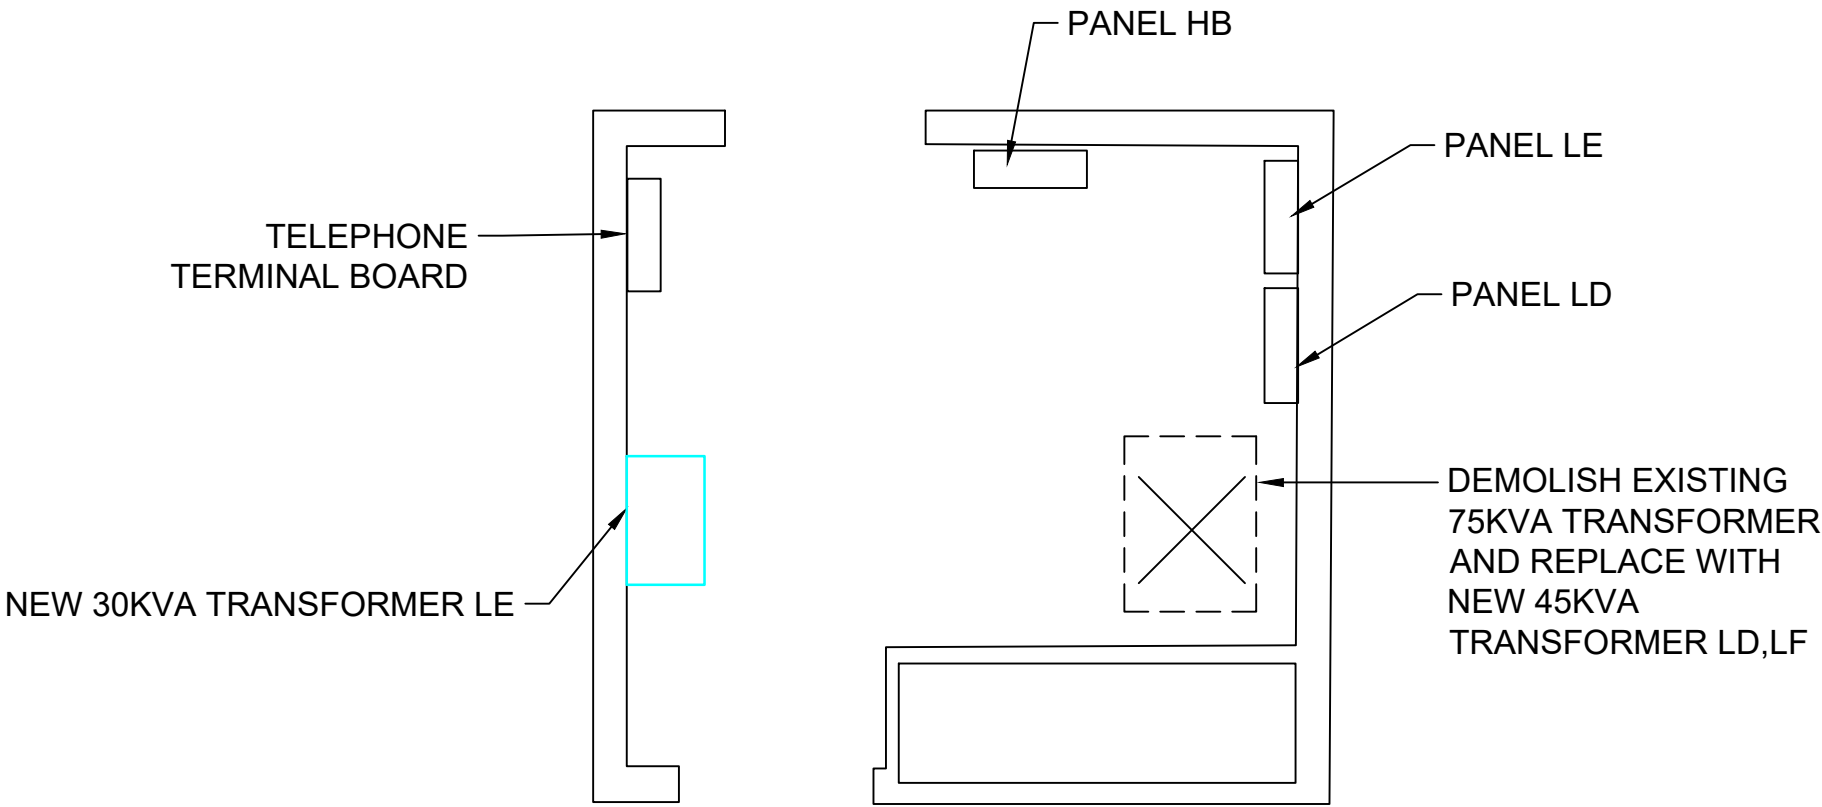

2
EP-101

BUILDING 100 - SECOND FLOOR ELECTRICAL ROOM

SCALE: NONE

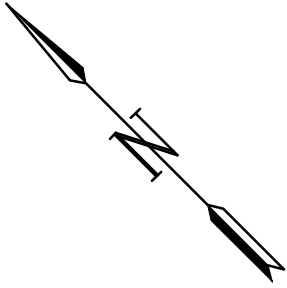

© 2025 GARVER, LLC
THIS DOCUMENT, ALONG WITH THE
IDEAS AND DESIGNS CONVEYED
HEREIN, SHALL BE CONSIDERED
INSTRUMENTS OF PROFESSIONAL
SERVICE AND ARE PROPERTY OF
GARVER, LLC. ANY USE,
REPRODUCTION, OR DISTRIBUTION
OF THIS DOCUMENT, ALONG WITH
THE IDEAS AND DESIGN CONTAINED
HEREIN, IS PROHIBITED UNLESS
AUTHORIZED IN WRITING BY
GARVER, LLC OR EXPLICITLY
ALLOWED IN THE GOVERNING
PROFESSIONAL SERVICES
AGREEMENT FOR THIS WORK.



Digitally Signed 05/02/2025

REV	DATE	DESCRIPTION	BY

BILL AND HILLARY CLINTON
NATIONAL AIRPORT
LITTLE ROCK, AR 72206

FIRE SUPPRESSION
IMPROVEMENTS

BUILDING 100 -
ELECTRICAL 2ND
FLOOR PLAN

JOB NO.: 21A10111
DATE: MAY 2025
DESIGNED BY: NAH
DRAWN BY: ICC

BAR IS ONE INCH ON
ORIGINAL DRAWING
0 1"
IF NOT ONE INCH ON THIS SHEET,
ADJUST SCALES ACCORDINGLY.

DRAWING NUMBER
EP-101