


File: L:\202\12\1A10111 - LIT Fire Suppression Improvements\Drawings\LIT_FS_IMP-EP101.dwg, Last Save: 5/5/2025 11:34 AM, Last saved by: NAHolland
Last plotted by: Holland, Nicholas A., Plot Style: AECOnono.ctb, Plot Scale: 1"=1', Plot Date: 5/5/2025 12:02 PM, Plotter used: DWG To PDF, p3

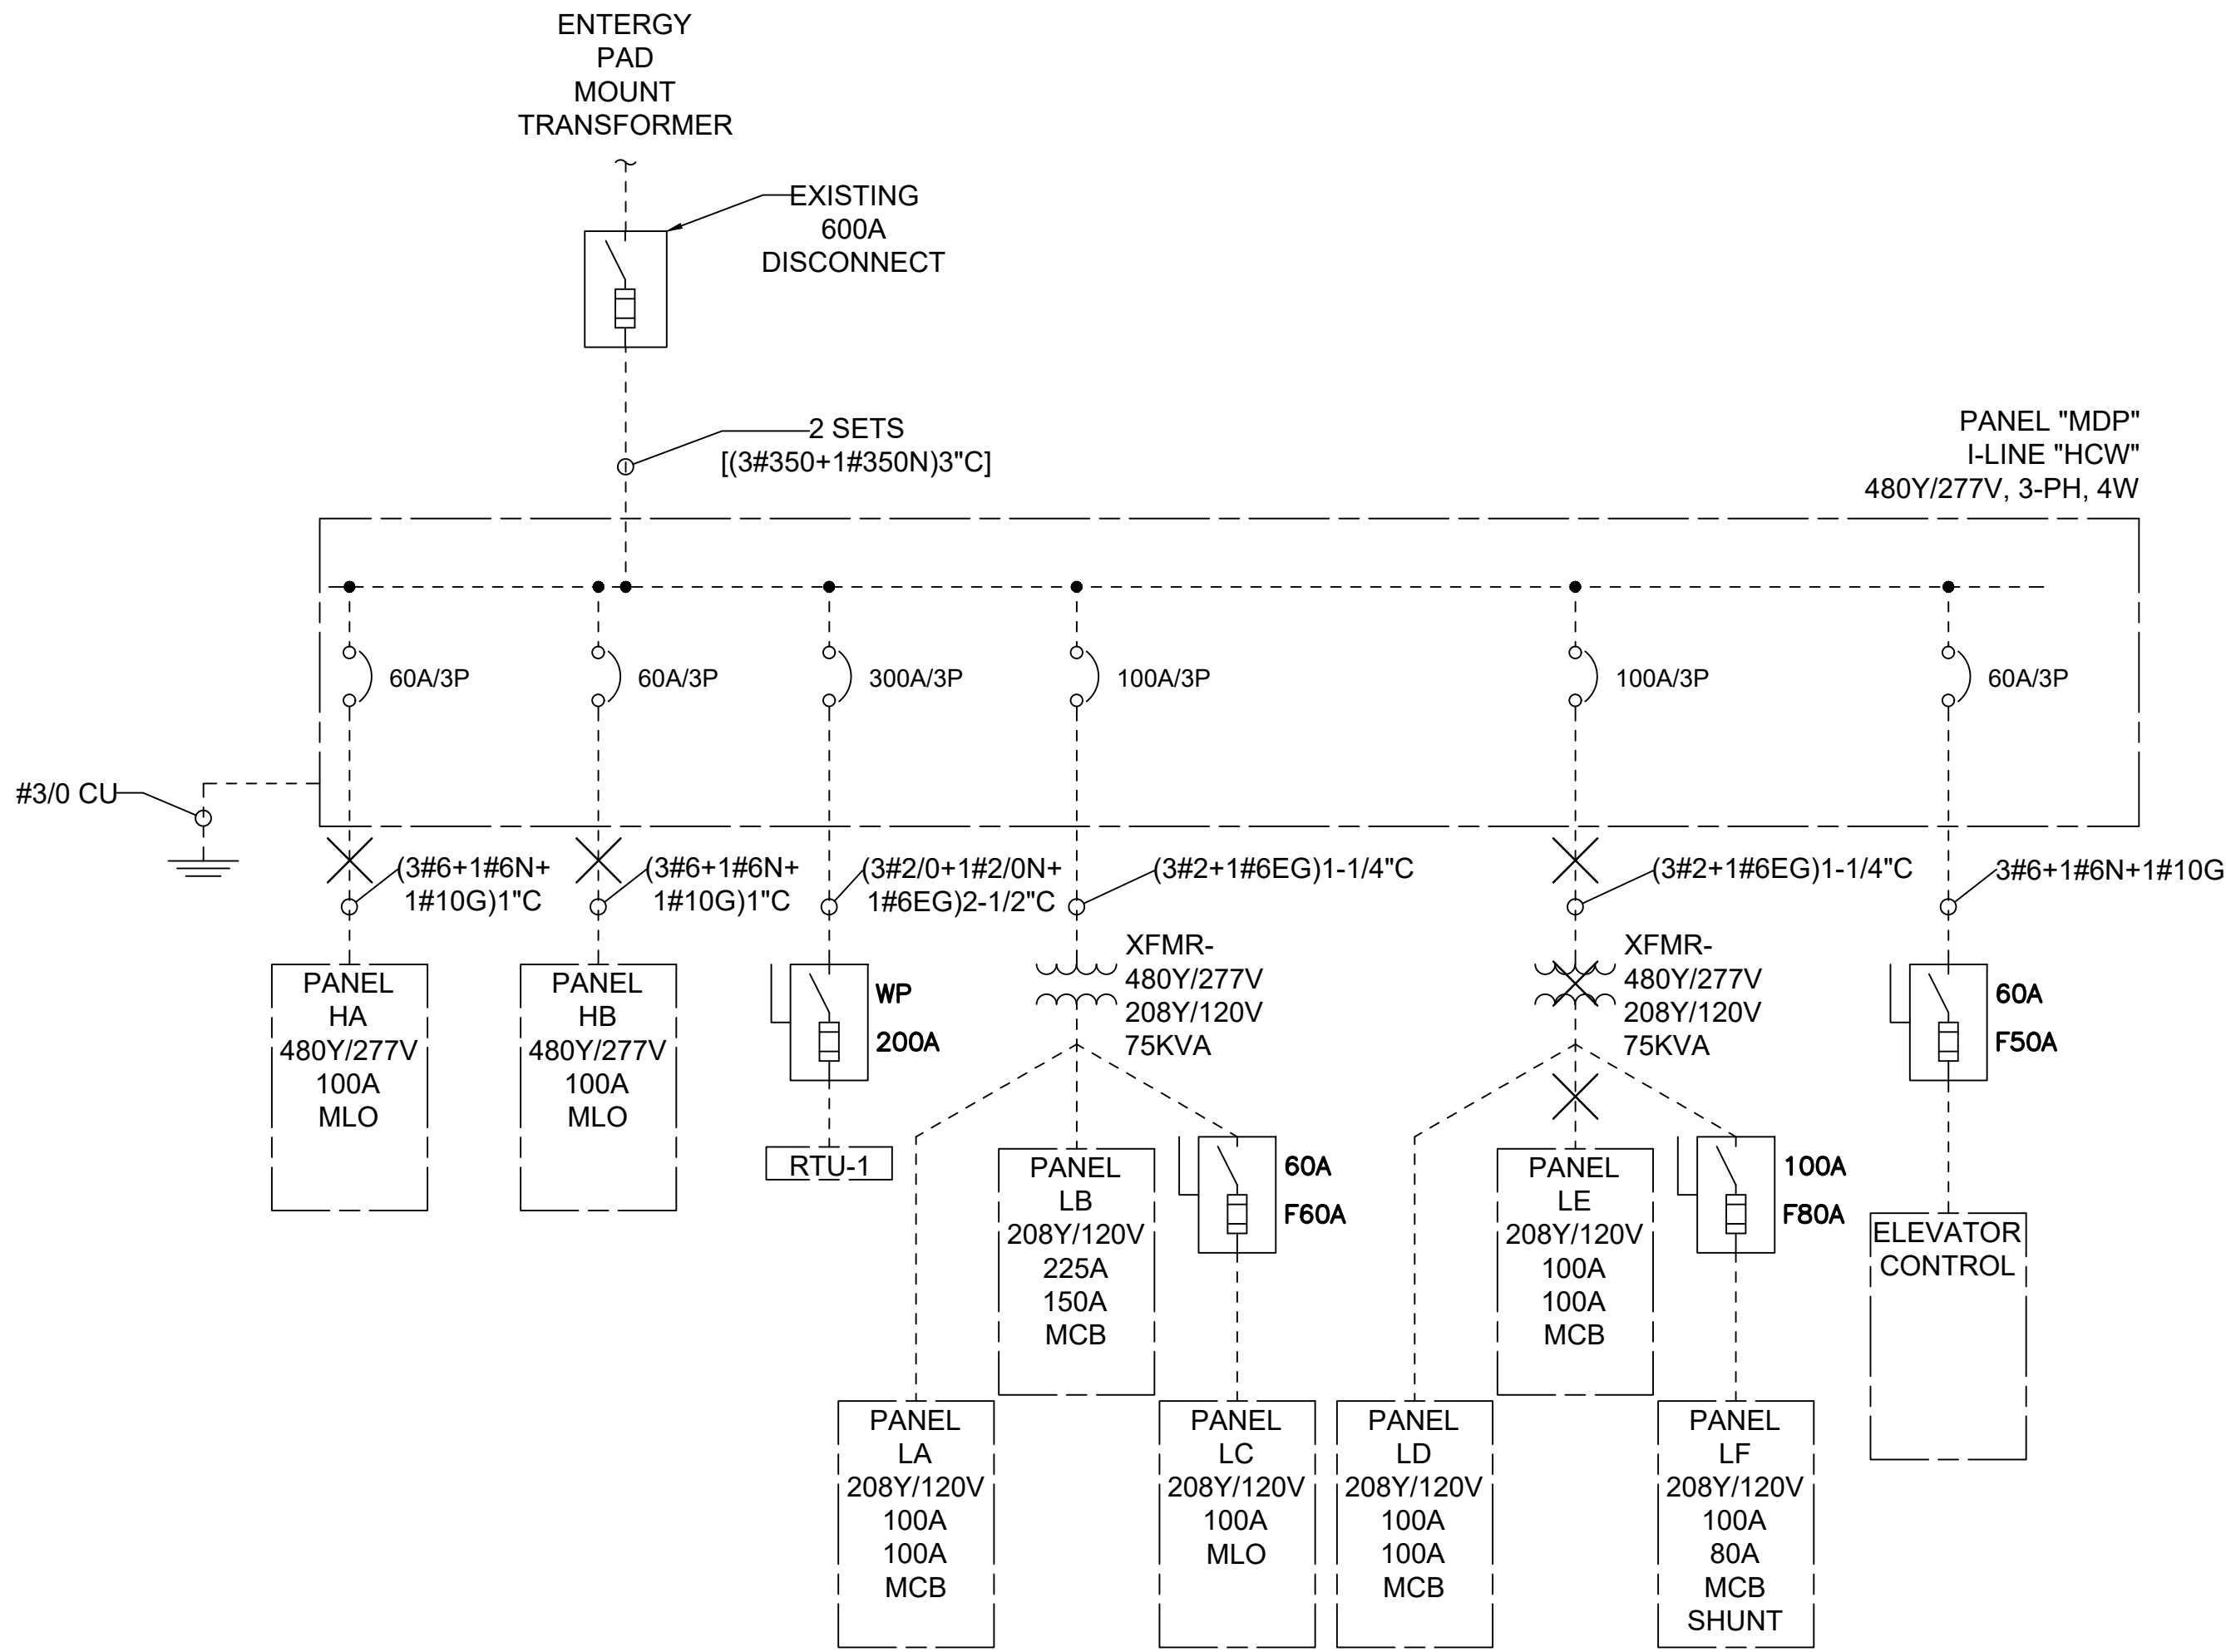

1
EP-601

EXISTING ONE-LINE DIAGRAM - BUILDING 100

SCALE: NONE

LEGEND:

--- EXISTING

— NEW

Ⓜ GENERATOR

≡ GROUND

⚡ TRANSFORMER

•/• SWITCH

⎓ FUSE

⌋ CIRCUIT BREAKER

ATS AUTOMATIC TRANSFER SWITCH


CB CIRCUIT BREAKER

CFCI CONTRACTOR FURNISHED,
CONTRACTOR INSTALLED

CP CONTROL PANEL

OFCI OWNER FURNISHED,
CONTRACTOR INSTALLED

REM EPO REMOTE EMERGENCY POWER OFF

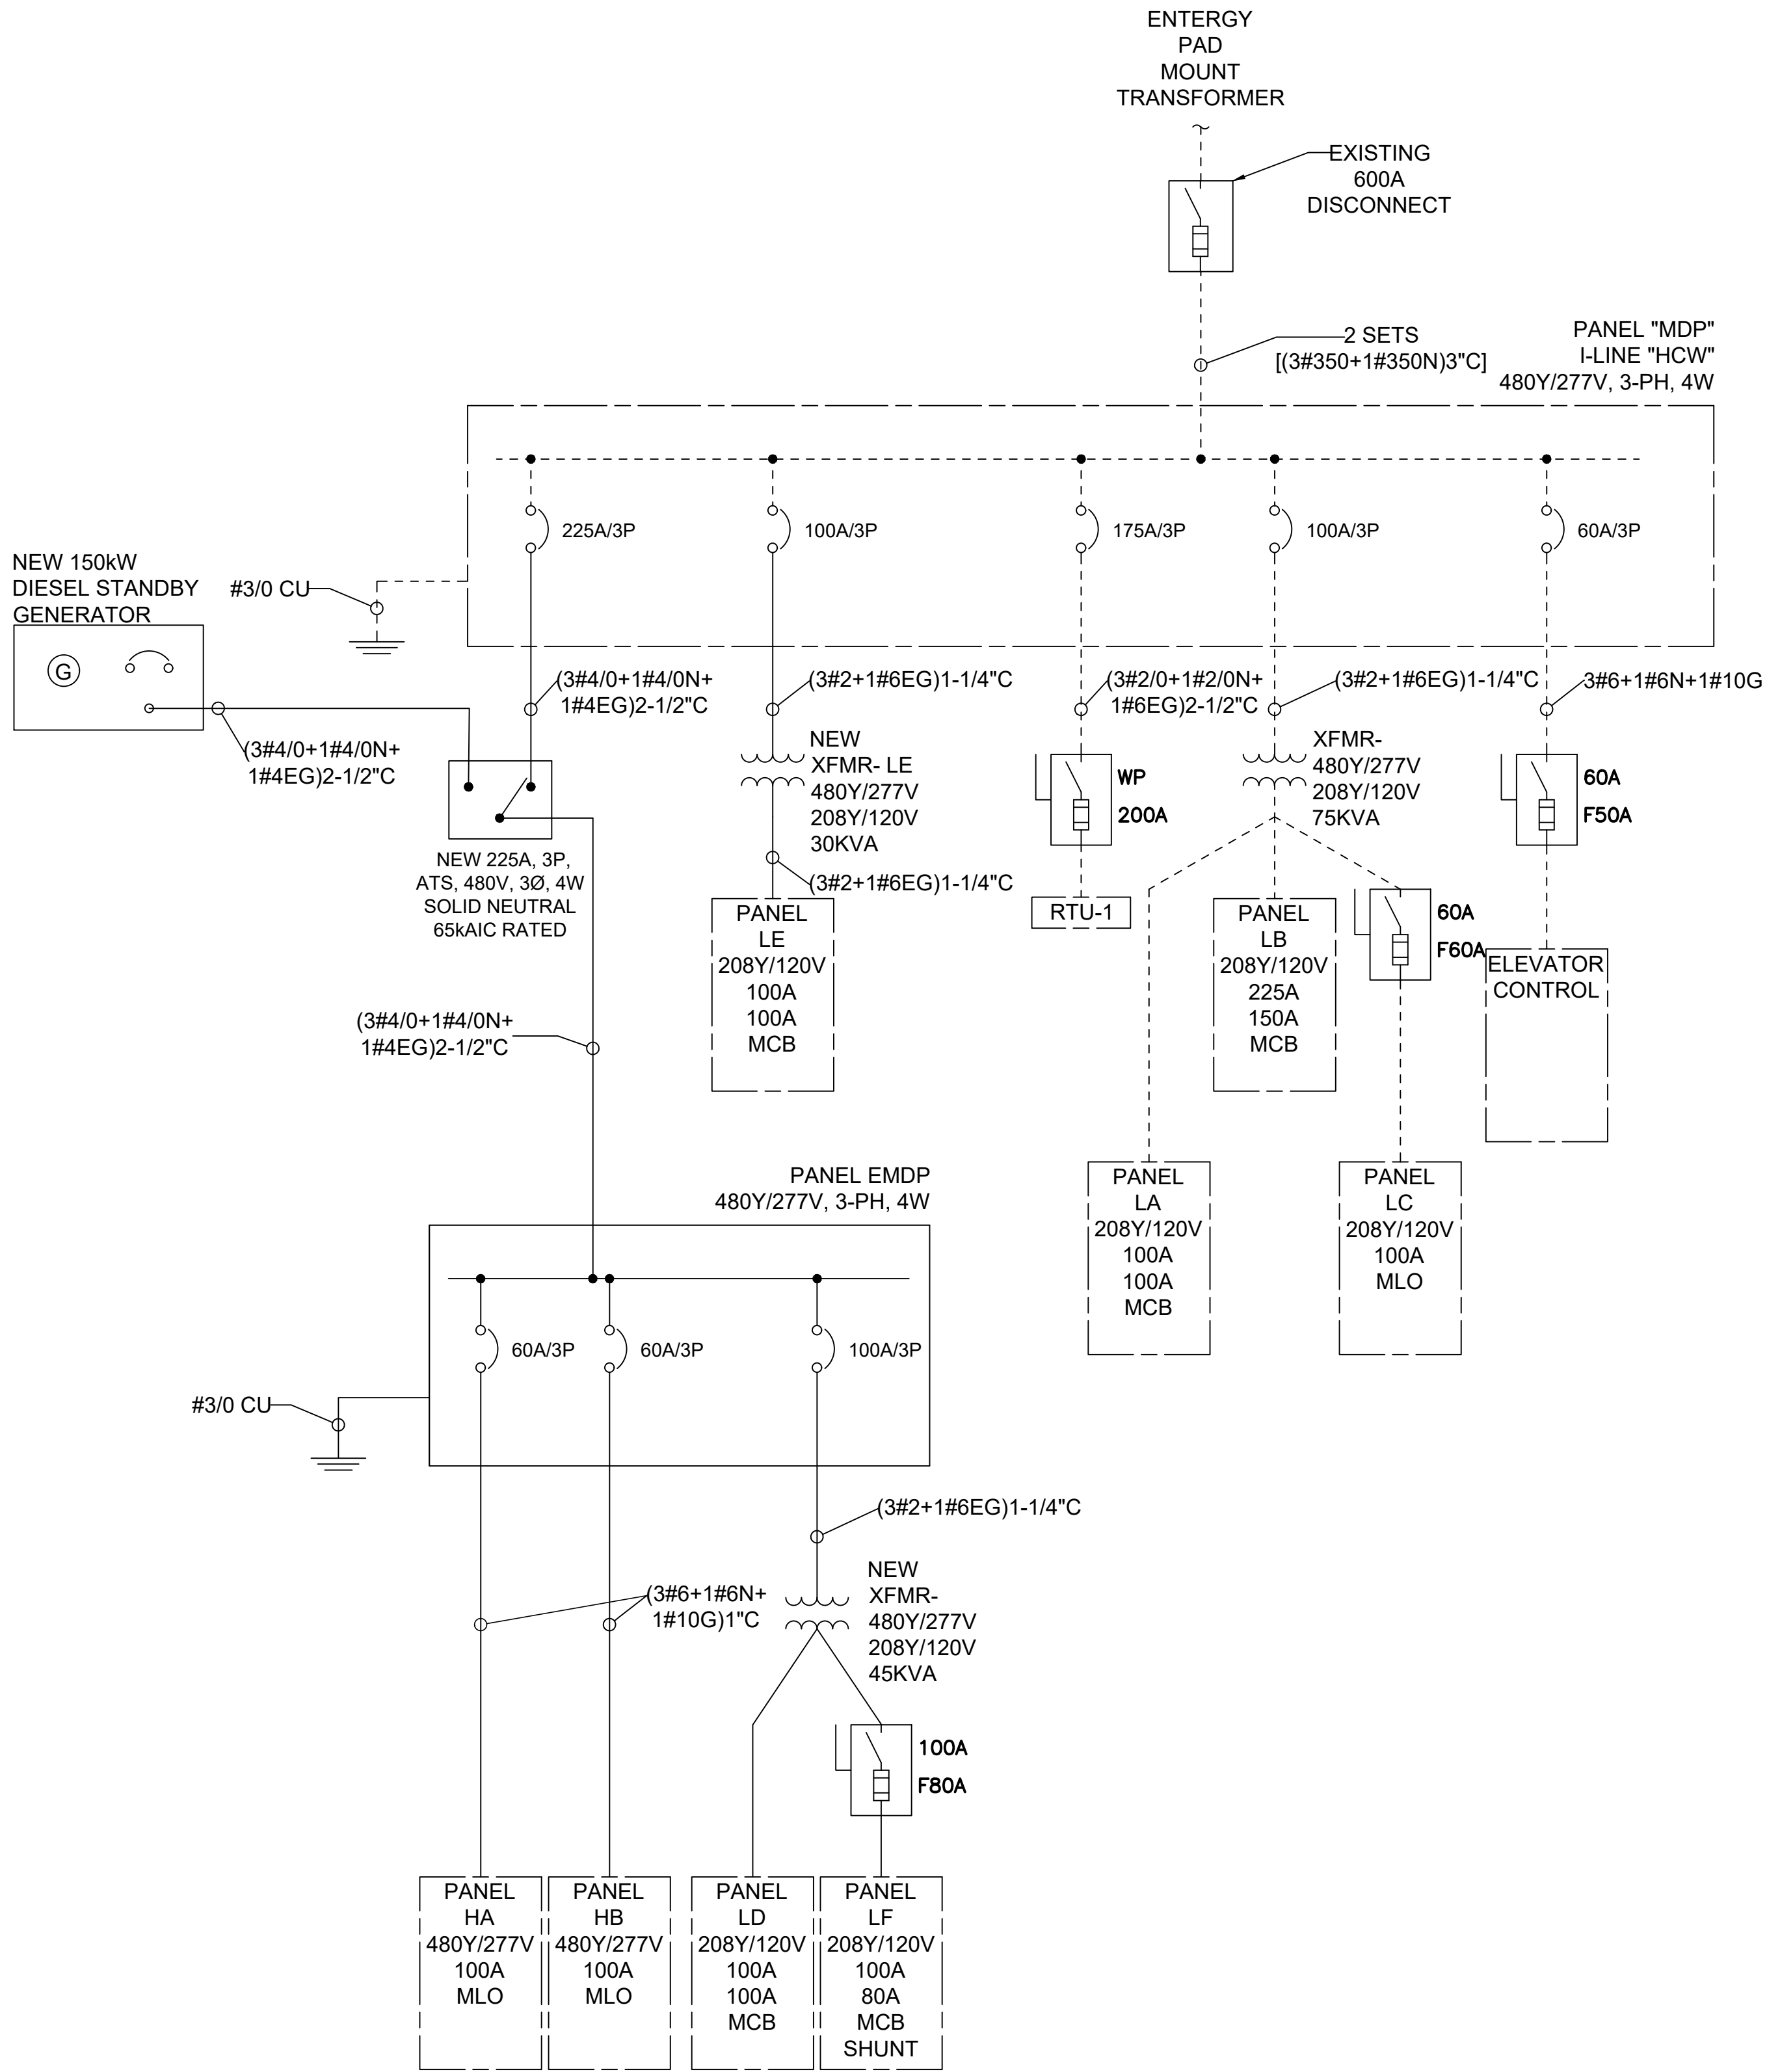

2
EP-601

PROPOSED ONE-LINE DIAGRAM - BUILDING 100

SCALE: NONE



© 2025 GARVER, LLC
THIS DOCUMENT, ALONG WITH THE
IDEAS AND DESIGNS CONVEYED
HEREIN, SHALL BE CONSIDERED
INSTRUMENTS OF PROFESSIONAL
SERVICE AND ARE PROPERTY OF
GARVER, LLC. ANY USE,
REPRODUCTION, OR DISTRIBUTION
OF THIS DOCUMENT, ALONG WITH
THE IDEAS AND DESIGN CONTAINED
HEREIN, IS PROHIBITED UNLESS
AUTHORIZED IN WRITING BY
GARVER, LLC OR EXPLICITLY
ALLOWED IN THE GOVERNING
PROFESSIONAL SERVICES
AGREEMENT FOR THIS WORK.



Digitally Signed 05/02/2025

BY

DESCRIPTION

DATE

REV

BILL AND HILLARY CLINTON
NATIONAL AIRPORT
LITTLE ROCK, AR 72206

FIRE SUPPRESSION
IMPROVEMENTS

ELECTRICAL
ONE-LINE DIAGRAM
BUILDING 100

JOB NO.: 21A10111
DATE: MAY 2025
DESIGNED BY: NAH
DRAWN BY: ICC

BAR IS ONE INCH ON
ORIGINAL DRAWING
0 1"
IF NOT ONE INCH ON THIS SHEET,
ADJUST SCALES ACCORDINGLY.

DRAWING NUMBER

EP-601