


Revit File: Autodesk Docs\21A10111 - LIT Fire Suppression Improvements\23-065 LIT ABP Fire Suppression MEP Model v23.rvt  
Plot Date: 5/2/2025 8:02:04 AM

Autodesk Revit 2023

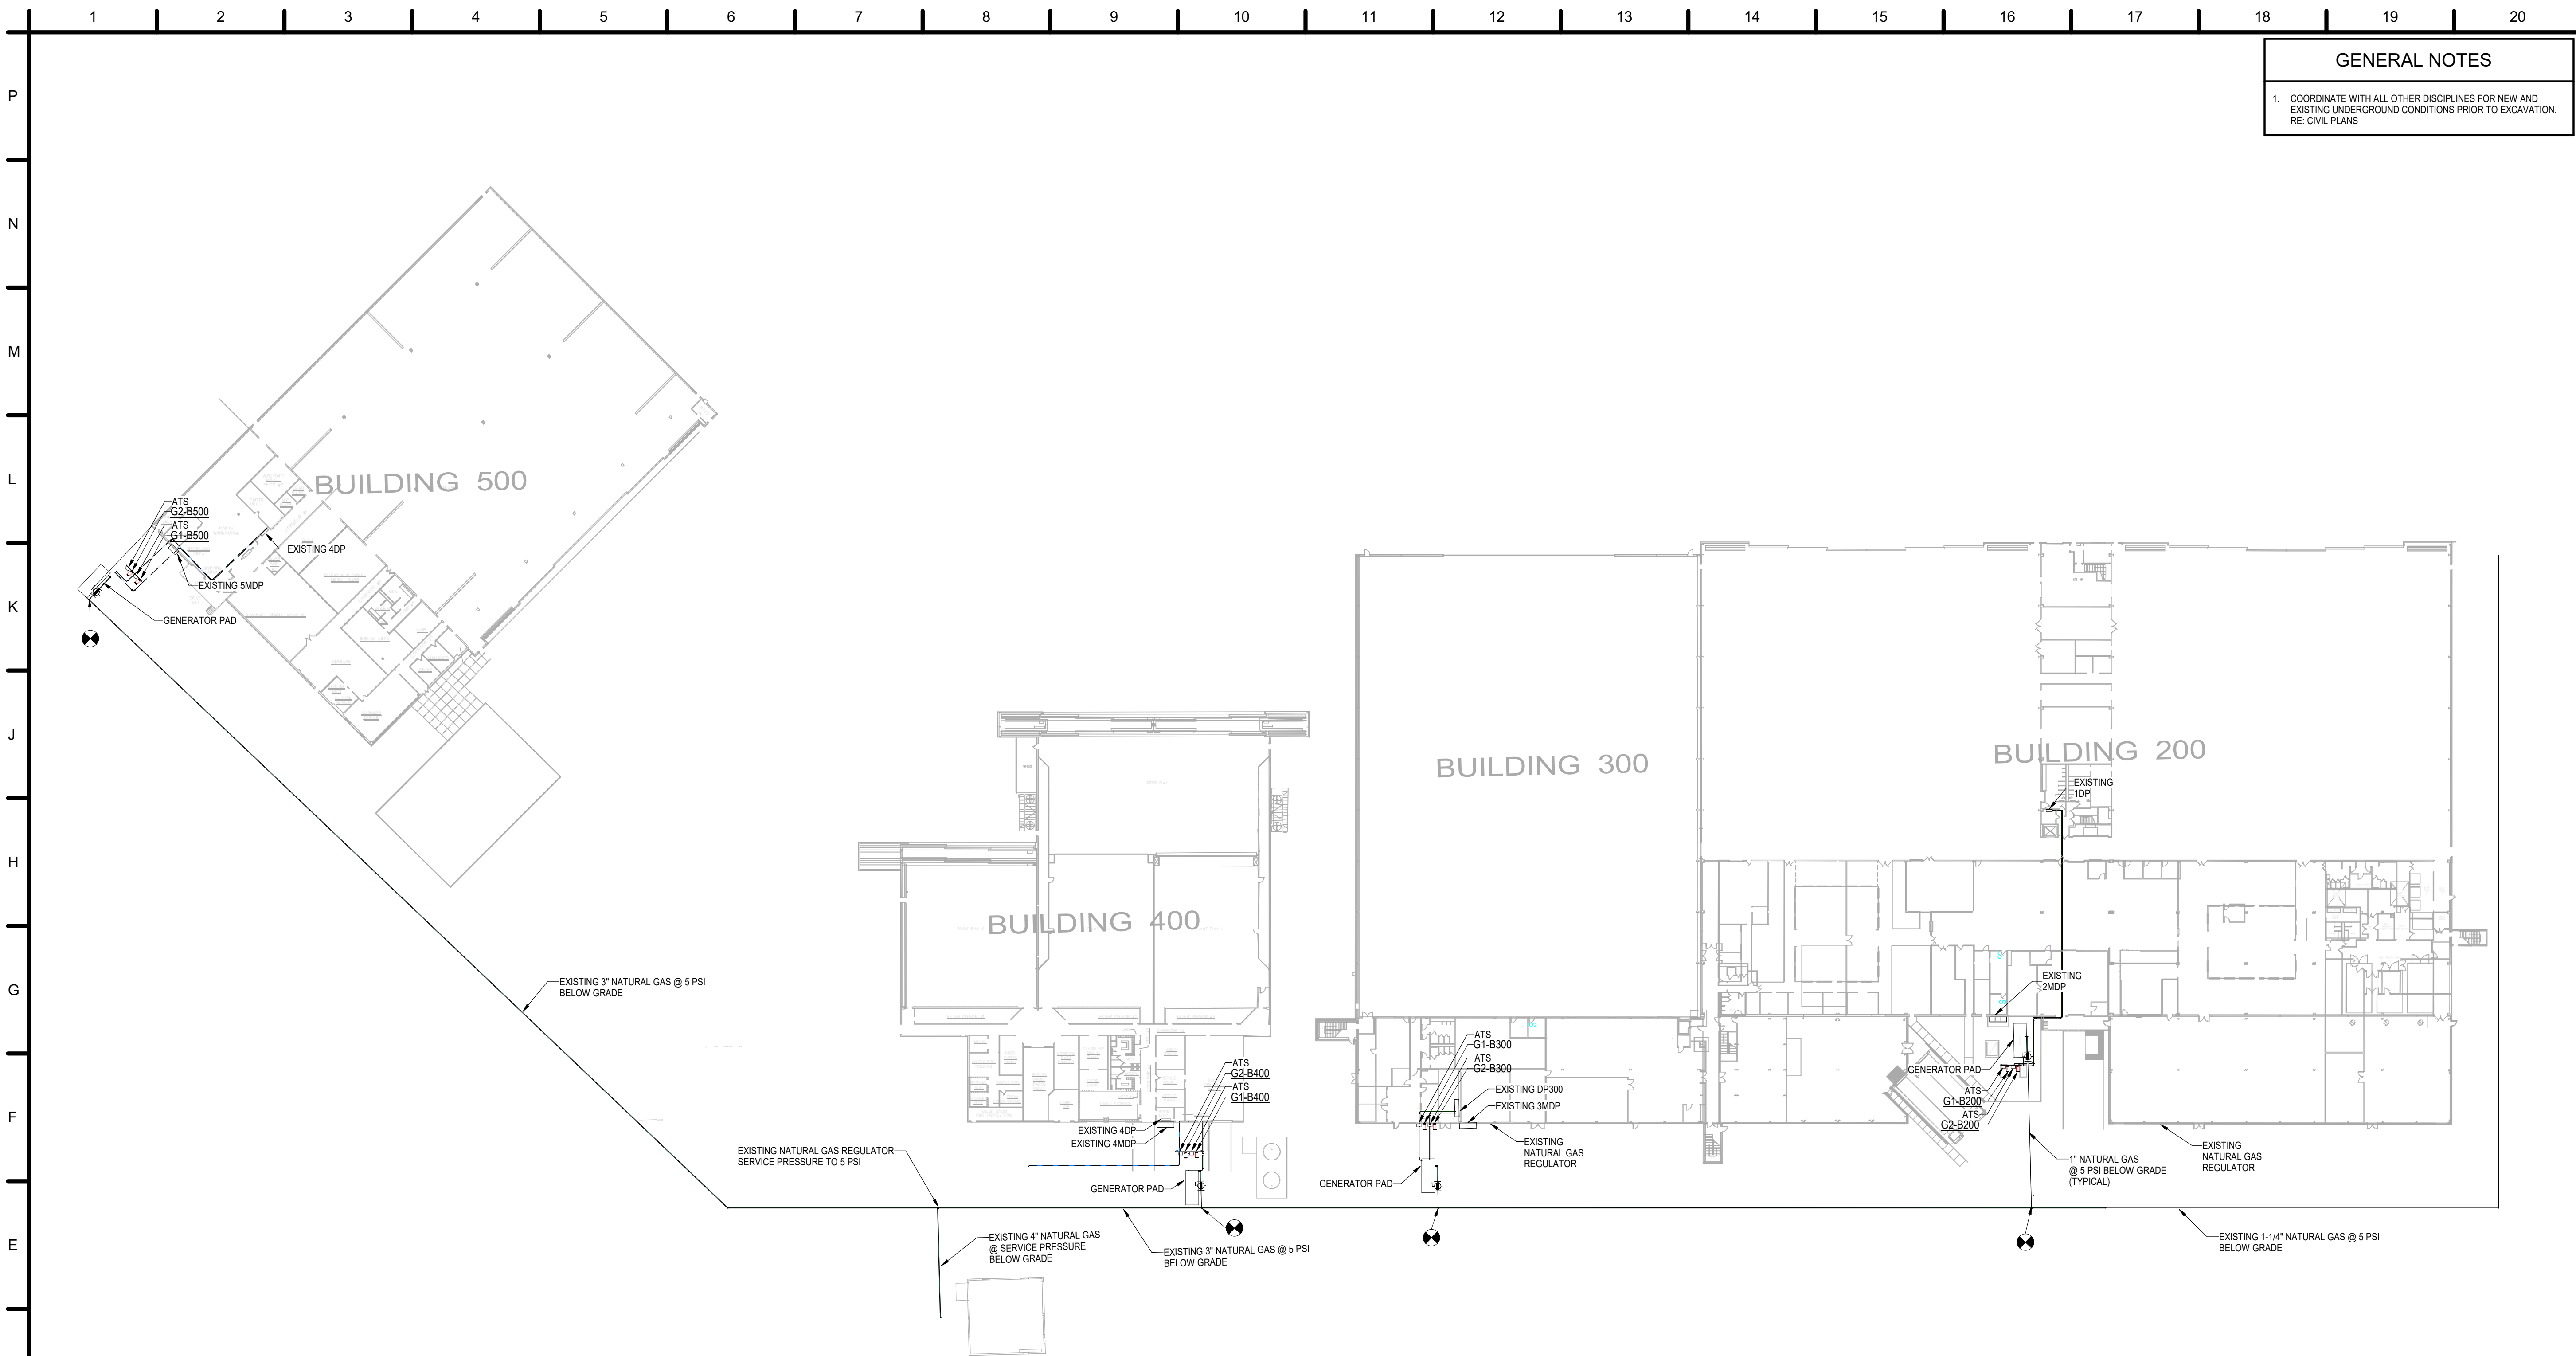

1 OVERALL SITE PLAN - ELECTRICAL - PHASE A  
1" = 50'-0"

GENERAL NOTES

- COORDINATE WITH ALL OTHER DISCIPLINES FOR NEW AND EXISTING UNDERGROUND CONDITIONS PRIOR TO EXCAVATION. RE: CIVIL PLANS



© 2025 GARVER, LLC  
THIS DOCUMENT, ALONG WITH THE IDEAS AND DESIGNS CONVEYED HEREIN, SHALL BE CONSIDERED INSTRUMENTS OF PROFESSIONAL SERVICE AND ARE PROPERTY OF GARVER, LLC. ANY USE, REPRODUCTION, OR DISTRIBUTION OF THIS DOCUMENT, ALONG WITH THE IDEAS AND DESIGN CONTAINED HEREIN, IS PROHIBITED UNLESS AUTHORIZED IN WRITING BY GARVER, LLC OR EXPLICITLY ALLOWED IN THE GOVERNING PROFESSIONAL SERVICES AGREEMENT FOR THIS WORK.

BY

DESCRIPTION

DATE

REV

BILL AND HILLARY CLINTON  
NATIONAL AIRPORT  
LITTLE ROCK, ARKANSAS 72206

FIRE SUPPRESSION  
IMPROVEMENTS

OVERALL SITE PLAN -  
ELECTRICAL

JOB NO.: 21A10111  
DATE: MAY 2, 2025  
DESIGNED BY: JHH  
DRAWN BY: JHH

BAR IS ONE INCH ON  
ORIGINAL DRAWING  
0 1"  
IF NOT ONE INCH ON THIS SHEET,  
ADJUST SCALES ACCORDINGLY.

DRAWING NUMBER  
**ES-101**

