


Revisions		
No.	Date	Description

Stamp

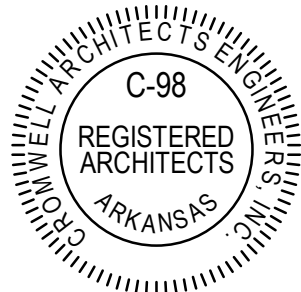

11-13-2024

Notes
1. CROMWELL ARCHITECTS ENGINEERS, INC. ALL RIGHTS RESERVED

2. THIS SHEET DESIGNED FOR COLOR PRINTING. CRITICAL INFORMATION MAY BE LOST WITH BLACK AND WHITE PRINTING.

Project Number 2024-116


Issue Date 11-13-2024

Sheet Title


REFLECTED CEILING
PLAN

Sheet Number

A-102

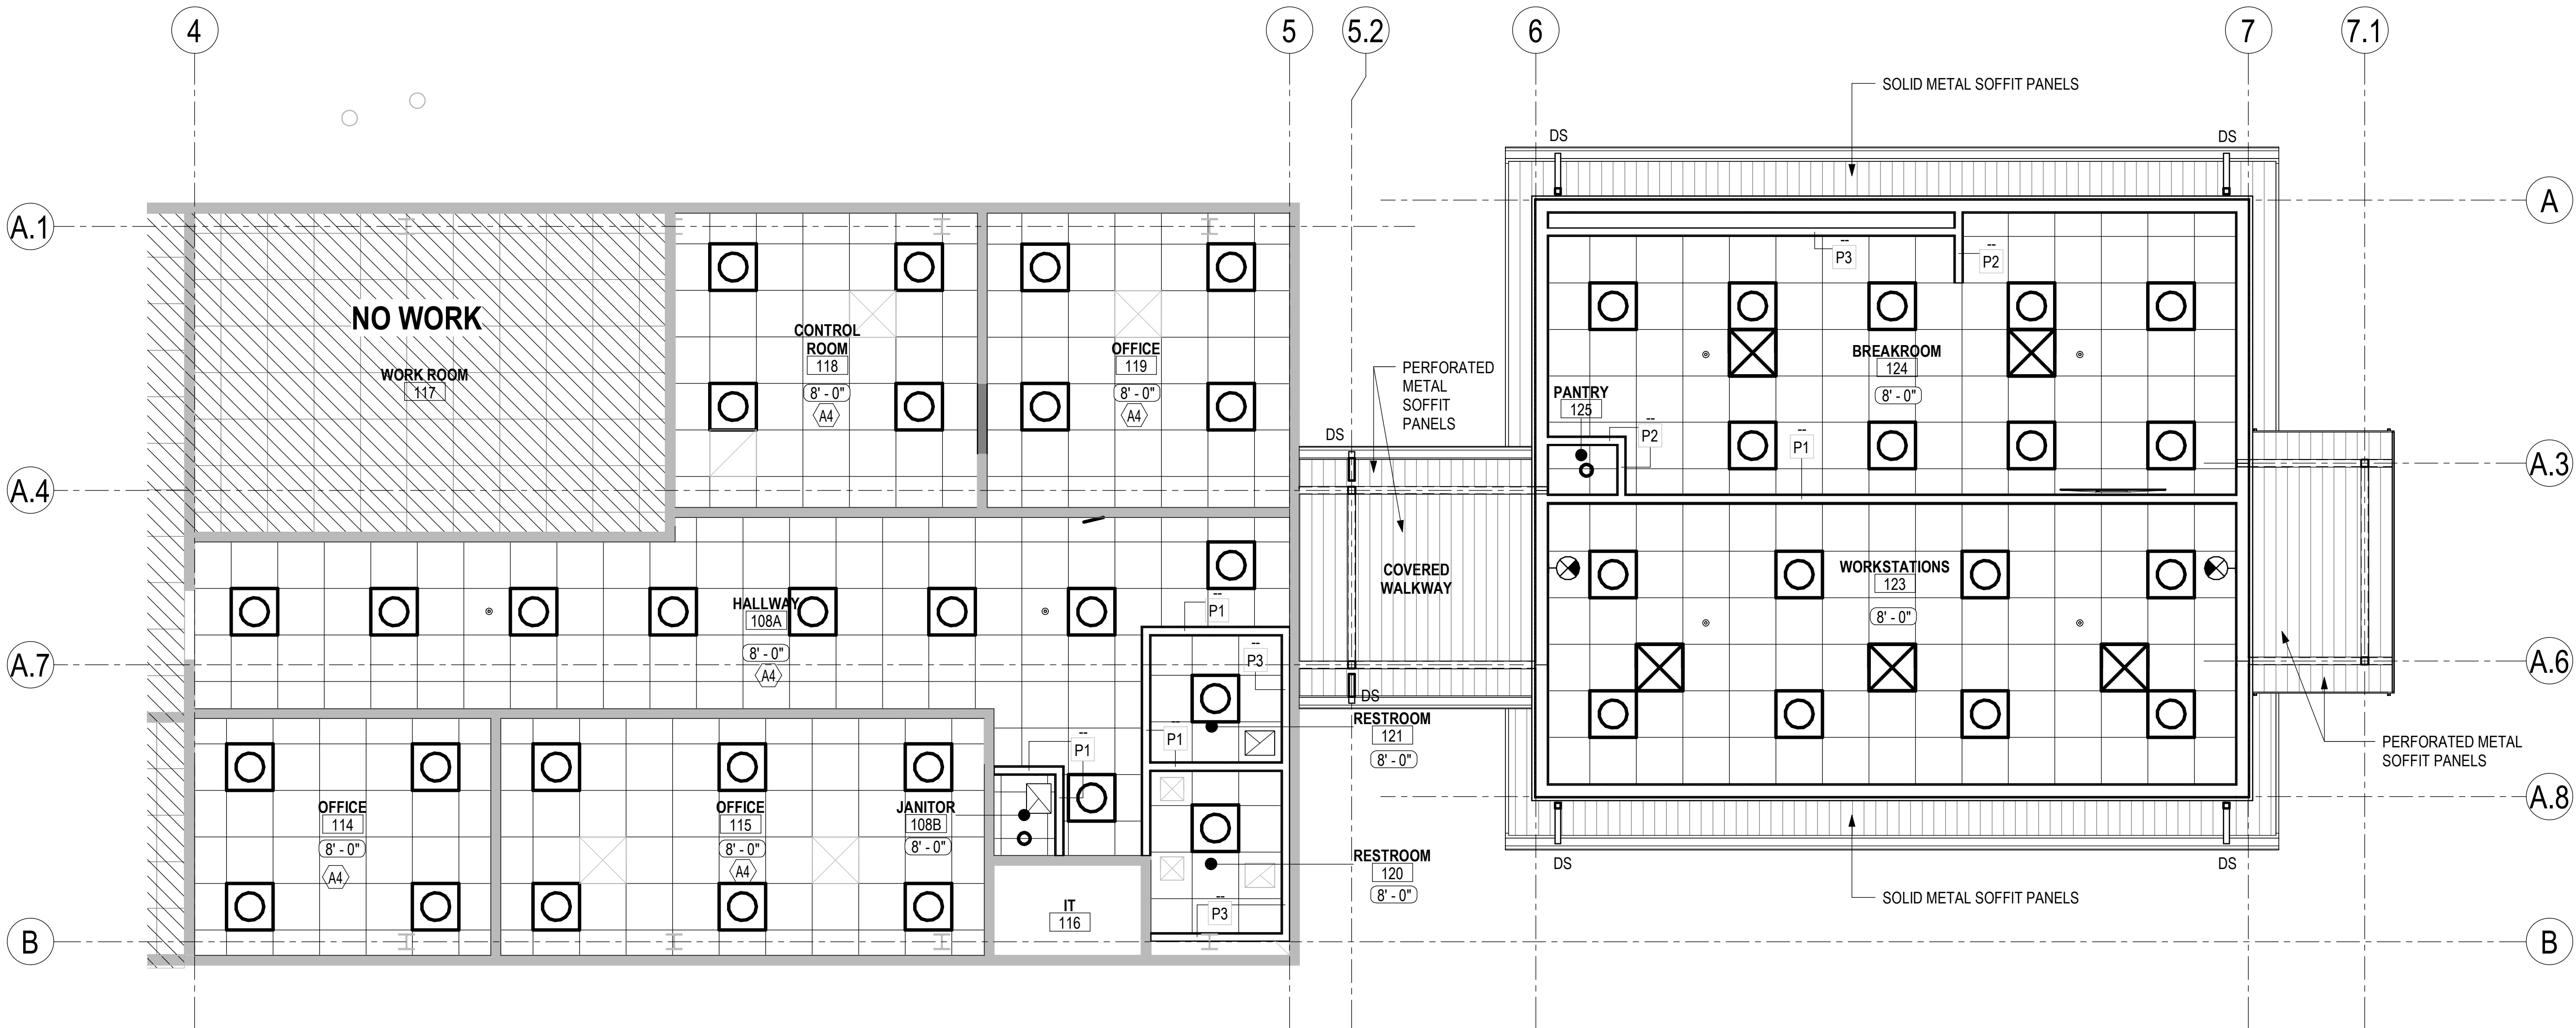

1 REFLECTED CEILING PLAN
1/4" = 1'-0"

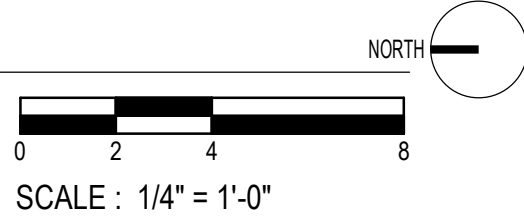

SYMBOLS LEGEND

	EXISTING 24"X24" LAY-IN ACOUSTICAL CEILING GRID TO REMAIN (GREY)		EMERGENCY LIGHT FIXTURE - SEE ELECTRICAL DRAWINGS		CEILING MOUNTED EXIT LIGHT
	NEW 24"X24" LAY-IN ACOUSTICAL CEILING GRID (BLACK)		EMERGENCY LIGHT FIXTURE W/BATTERY PACK - SEE ELECTRICAL DRAWINGS		SUPPLY AIR GRILLE
	LIGHT FIXTURE - SEE ELECTRICAL DRAWINGS		RETURN AIR GRILLE		PARTITION TYPE - SEE SHEET A-801

GENERAL NOTES
1. REFER TO LIFE SAFETY, MECHANICAL AND ELECTRICAL DRAWINGS FOR ADDITIONAL INFORMATION NOT SHOWN.

#	DESCRIPTION
A4	PROVIDE NEW 2X2 CEILING TILE & GRID. SEE ELECT DWGS FOR NEW LIGHT FIXTURES