

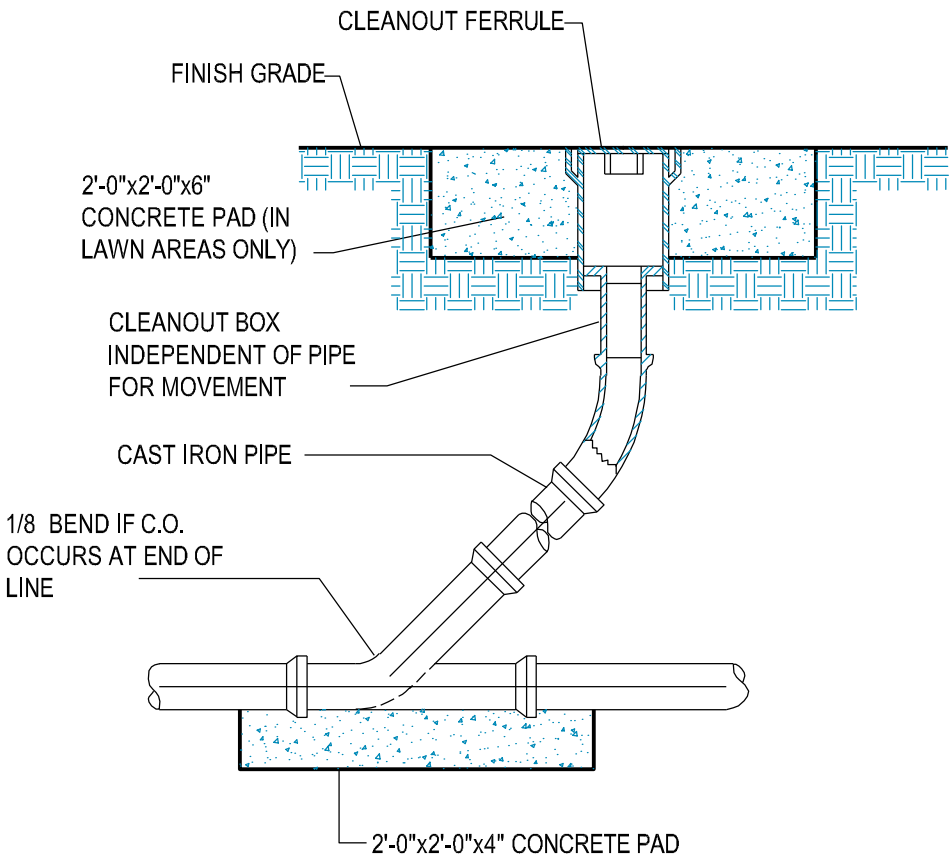


LEGEND

- EXISTING UTILITY LINE
- W=WATER
- SS=SANITARY SEWER
- O.H.E.=OVERHEAD ELECTRIC
- NEW UTILITY LINE
- W=WATER
- SS=SANITARY SEWER

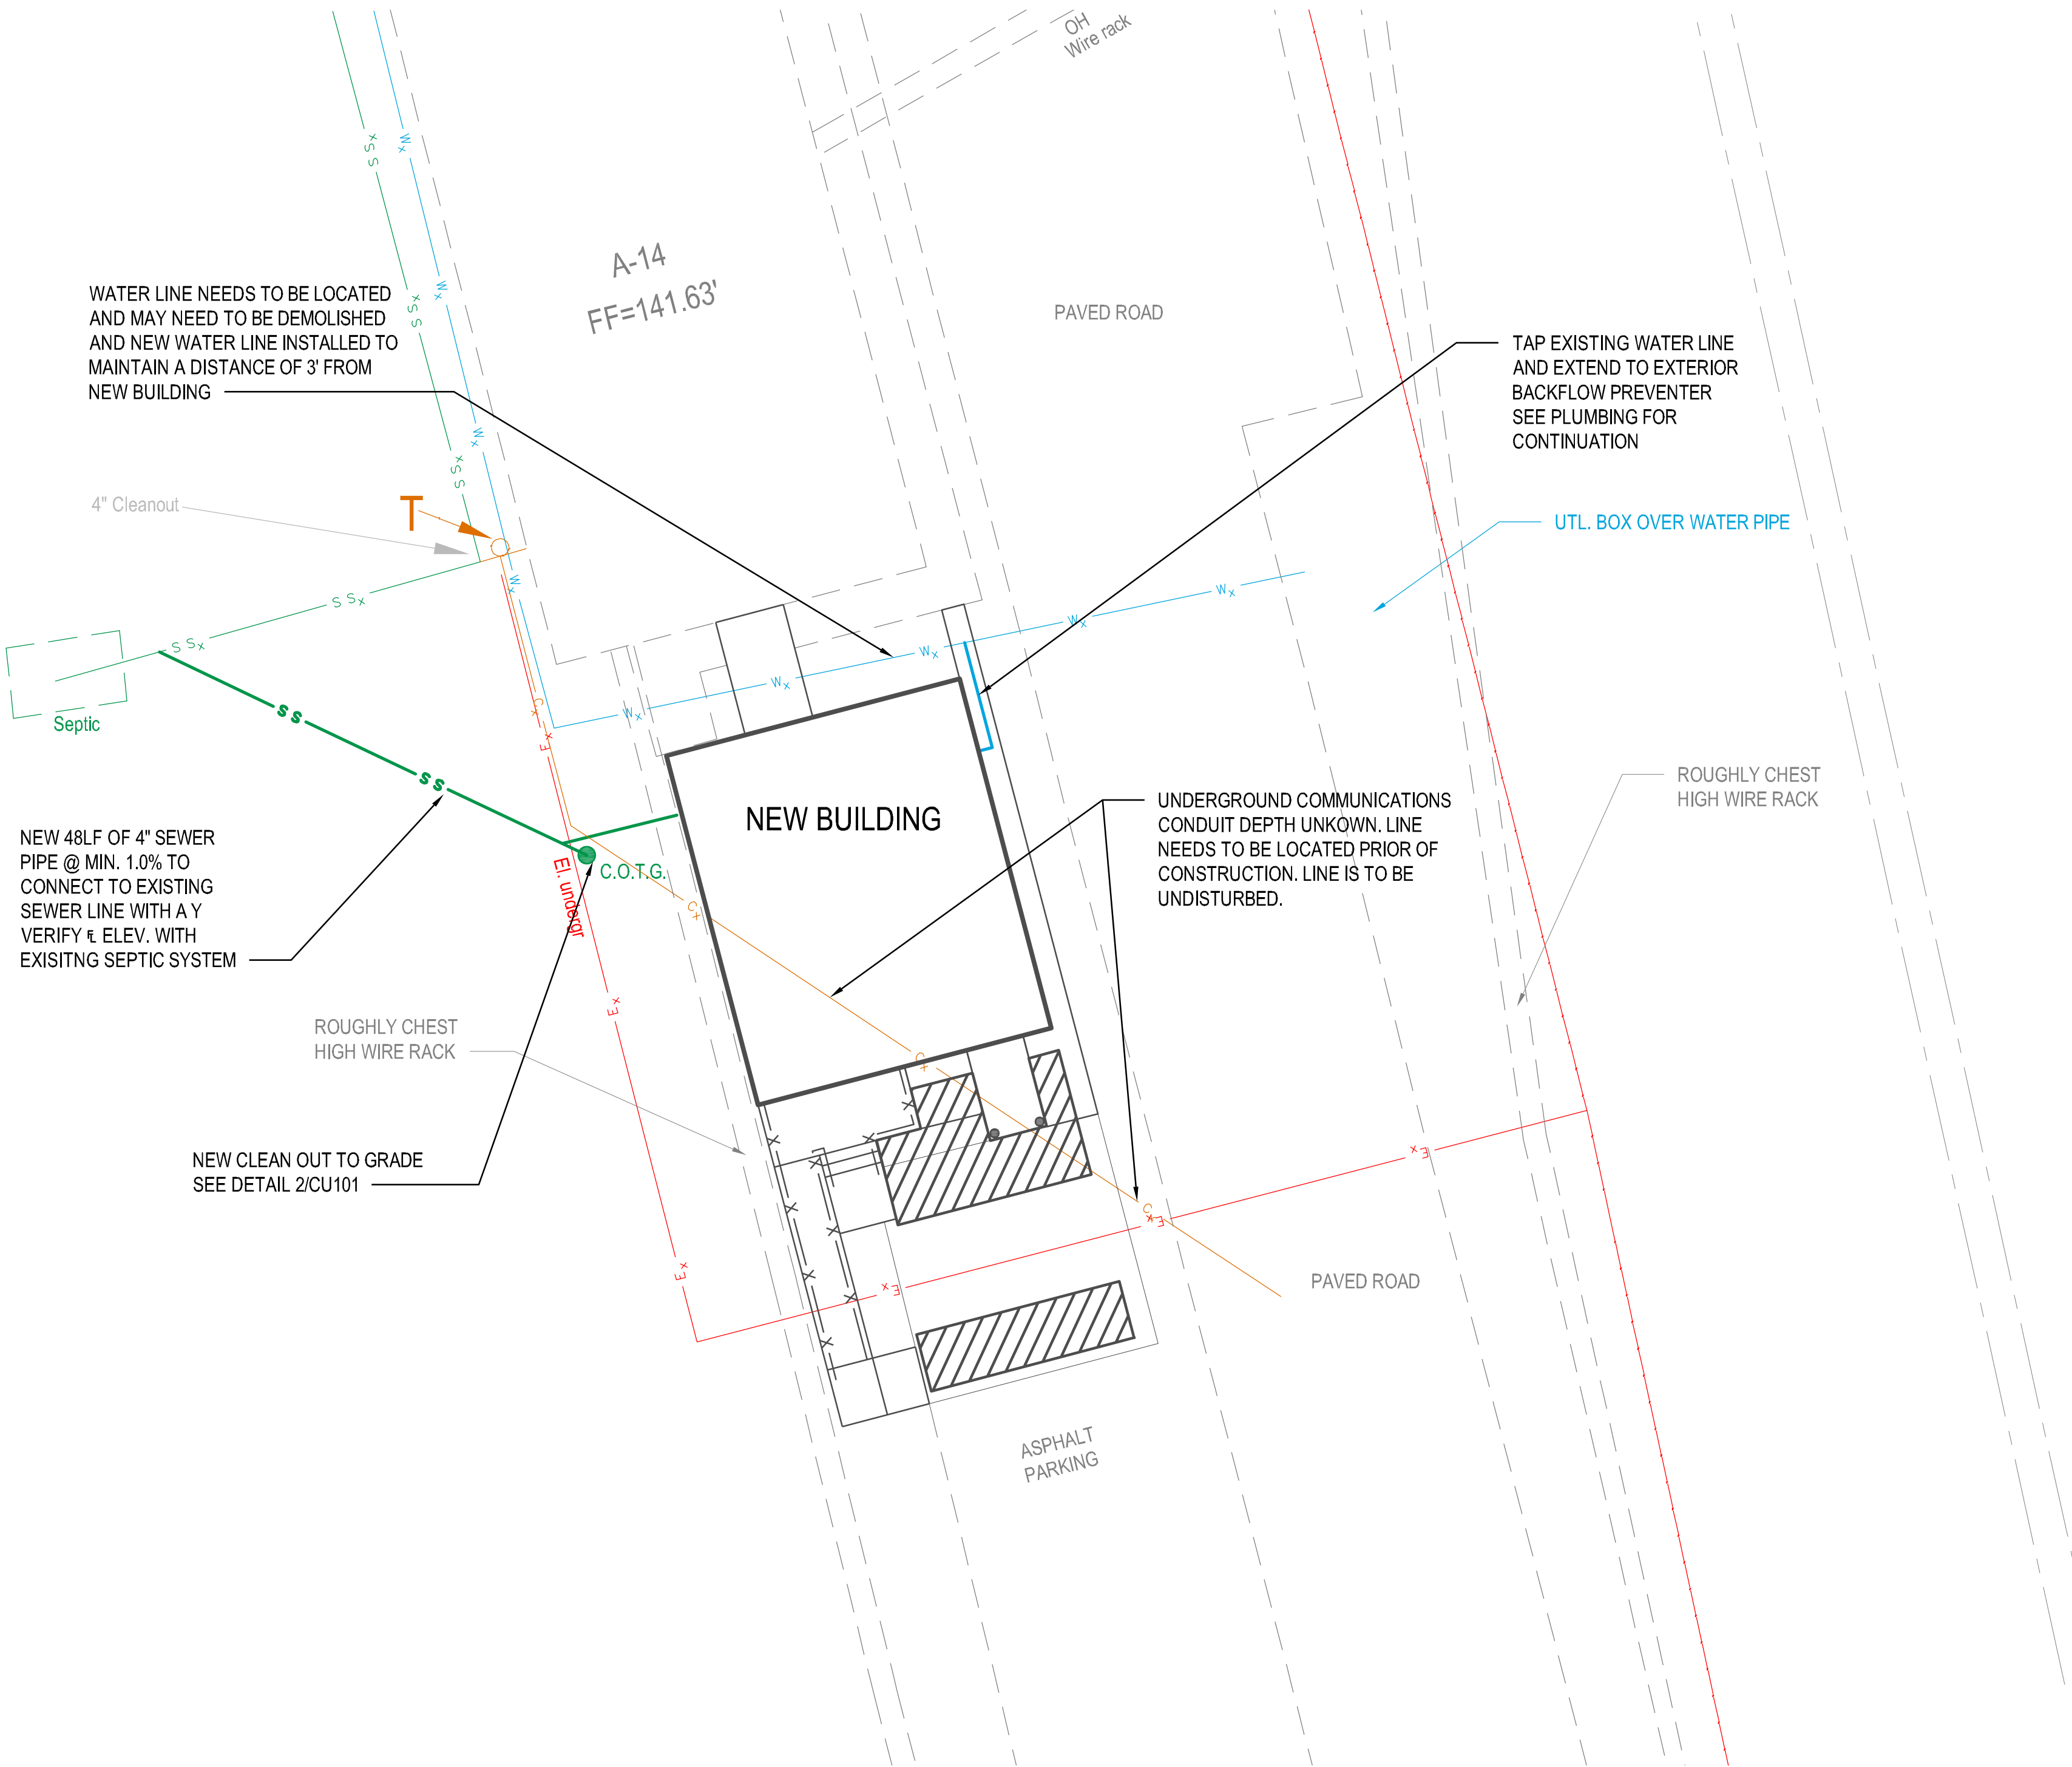

2 SANITARY SEWER CLEANOUT TO GRADE DETAIL (C.O.T.G.) NOT TO SCALE

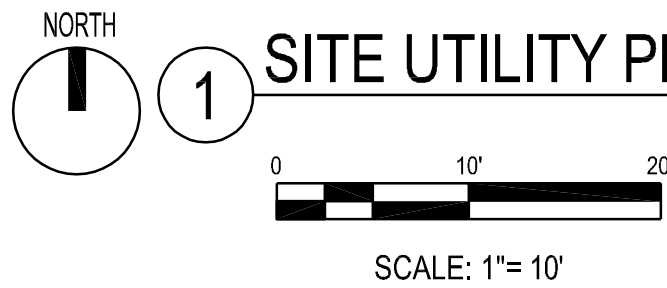

Project

AER JET ROCKETDYNE

BUILDING A14

TOILET RENOVATION & BREAKROOM ADDITION

EAST CAMDEN, ARKANSAS

CONSTRUCTION DOCUMENTS

Revisions		
No.	Date	Description

Stamp

CROMWELL ARCHITECTS/ENGINEERS #5

STATE OF ARKANSAS REGISTERED PROFESSIONAL ENGINEER No. 15927 CHARLES WISE 11-13-2024

- Notes
1. CROMWELL ARCHITECTS ENGINEERS, INC. ALL RIGHTS RESERVED
2. THIS SHEET DESIGNED FOR COLOR PRINTING. CRITICAL INFORMATION MAY BE LOST WITH BLACK AND WHITE PRINTING.

Project Number 2024-116

Issue Date 11-13-2024

Sheet Title

SITE UTILITY PLAN

Sheet Number

CU101