




1 DOMESTIC WATER BUILDING SERVICE
NOT TO SCALE

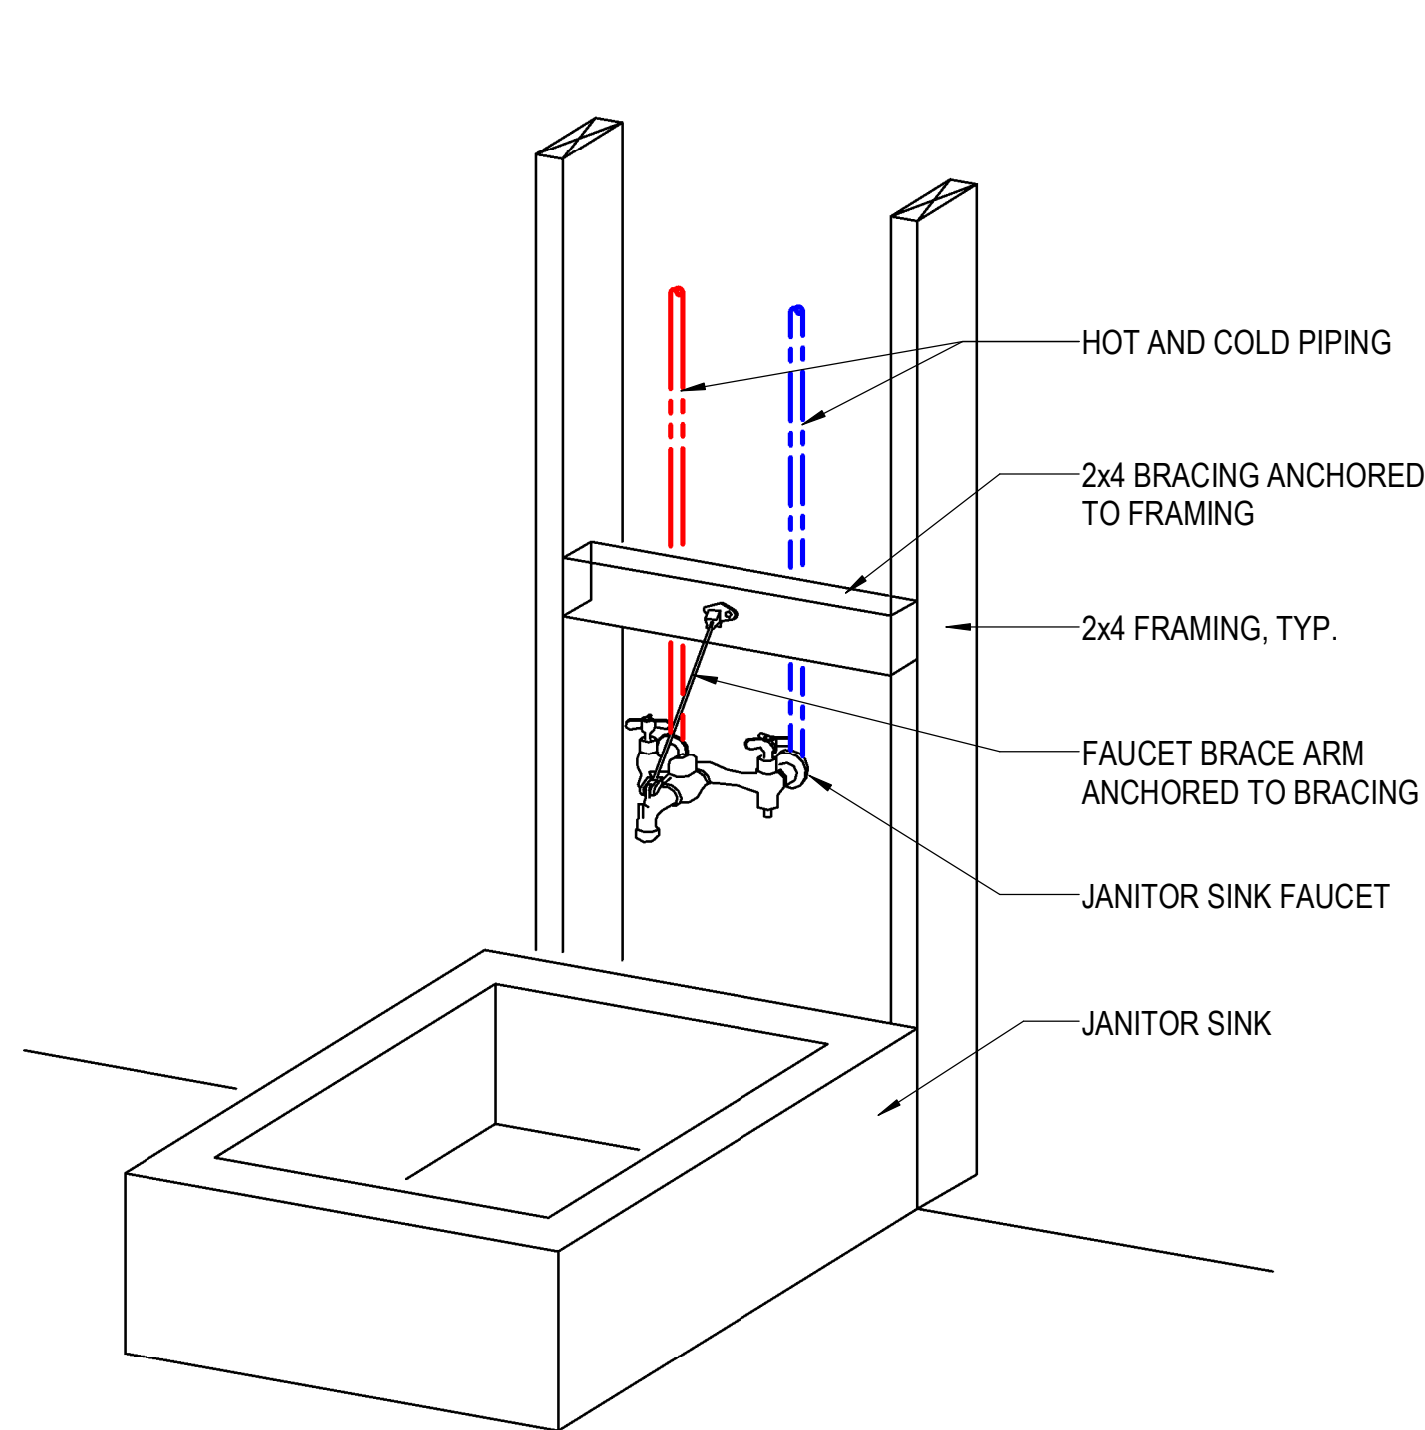

2 JANITOR SINK FAUCET BRACING
NOT TO SCALE

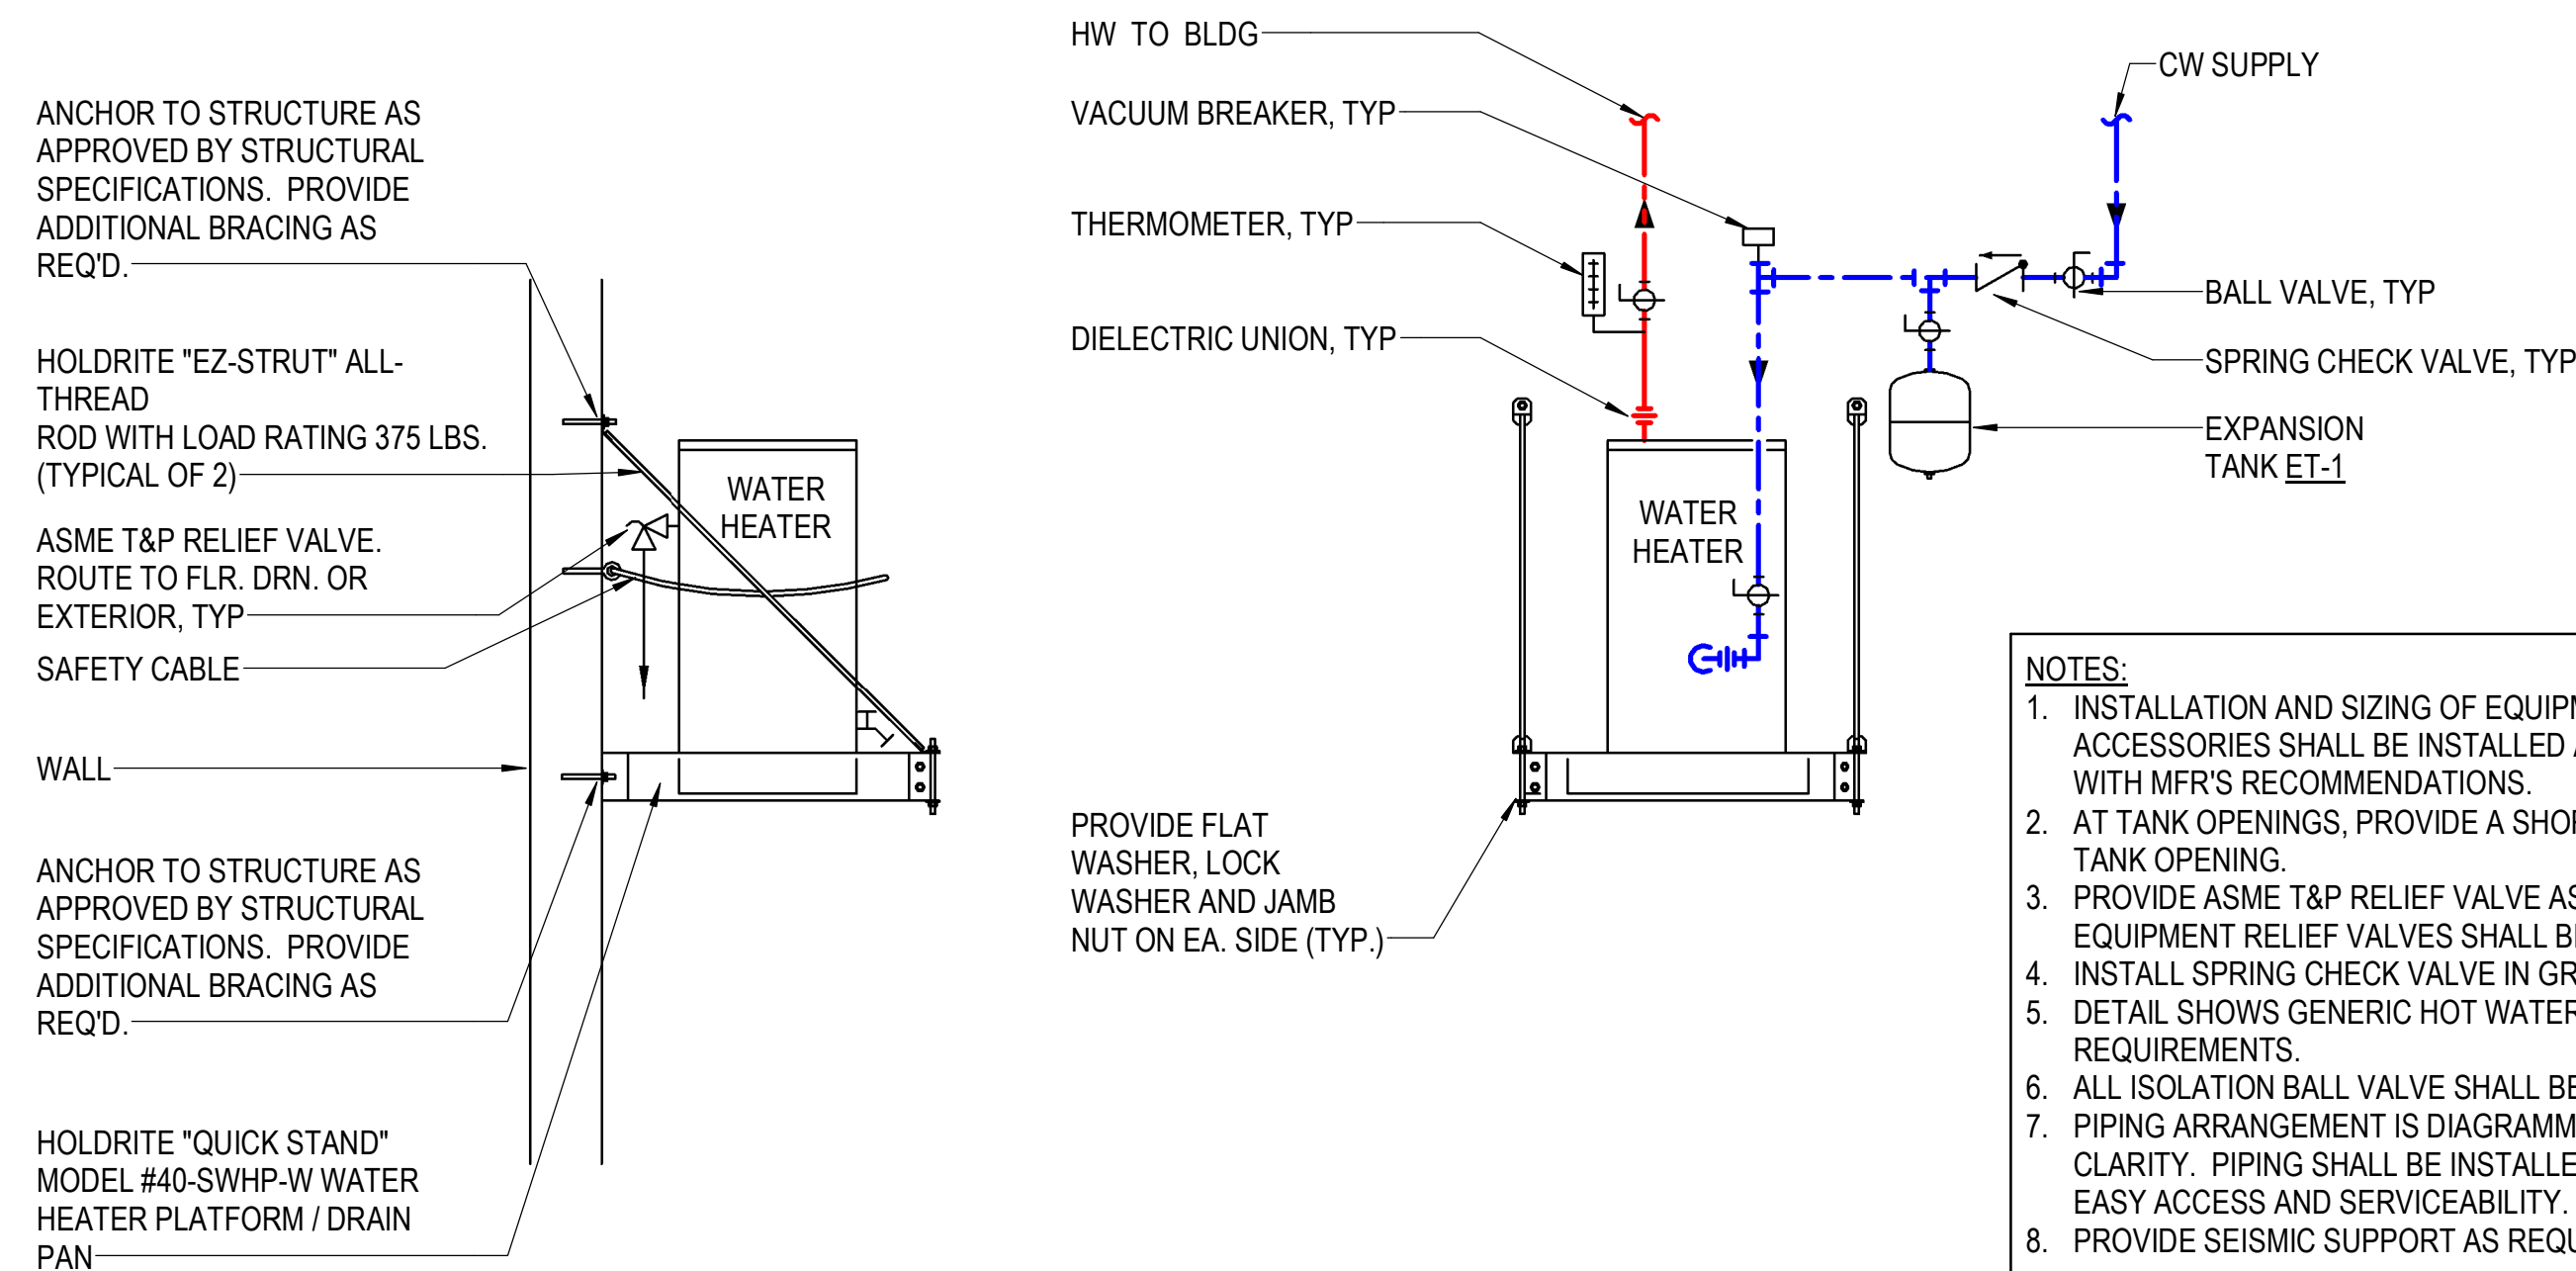

4 WATER HEATER INSTALLATION - EWH-2
NOT TO SCALE

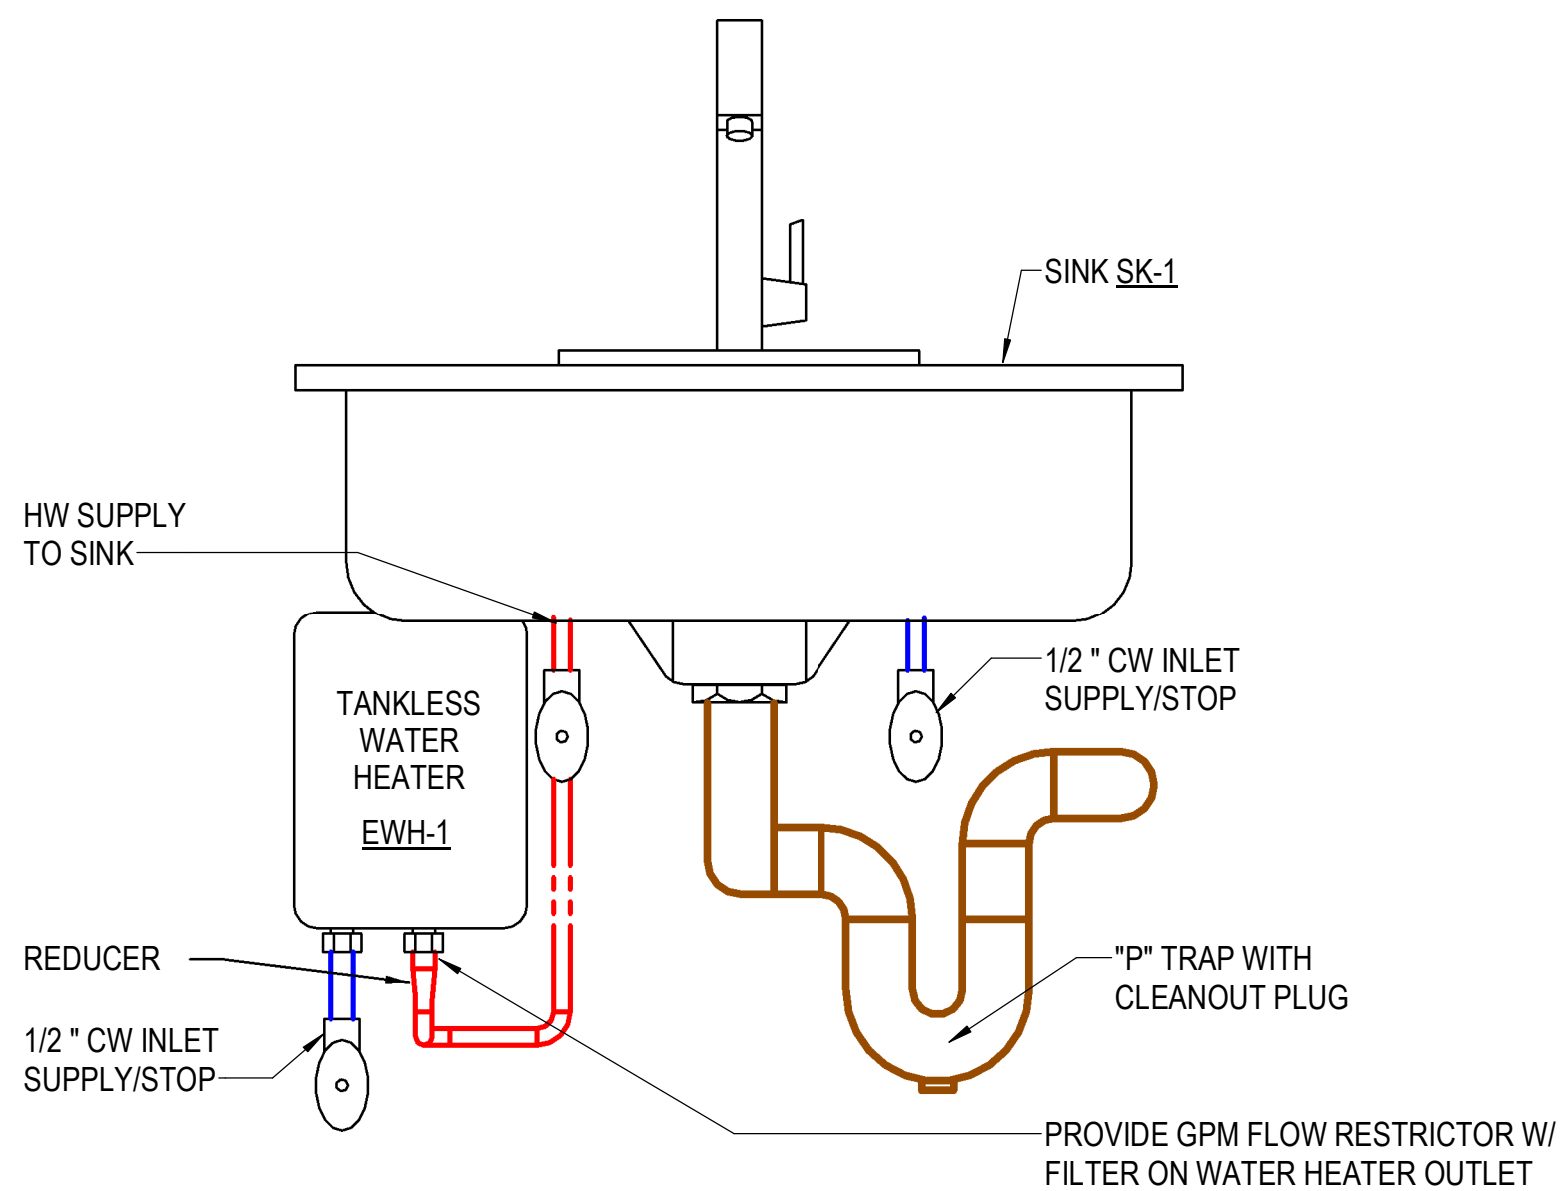

3 WATER HEATER INSTALLATION - EWH-1
NOT TO SCALE

Project

AER JET
ROCKETDYNE



BUILDING A14
TOILET RENOVATION &
BREAKROOM ADDITION
EAST CAMDEN, ARKANSAS

Design Phase

CONSTRUCTION
DOCUMENTS

Revisions		
No.	Date	Description

Stamp

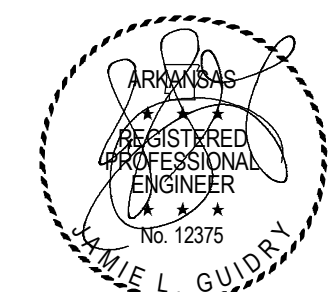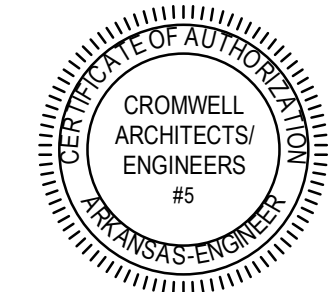

Notes

- CROMWELL ARCHITECTS ENGINEERS, INC. ALL RIGHTS RESERVED
- THIS SHEET DESIGNED FOR COLOR PRINTING. CRITICAL INFORMATION MAY BE LOST WITH BLACK AND WHITE PRINTING.

Project Number

2024-116

Issue Date

11-13-2024

Sheet Title

PLUMBING DETAILS

Sheet Number

P-501