


CONSTRUCTION  
DOCUMENTS

Revisions		
No.	Date	Description

Stamp

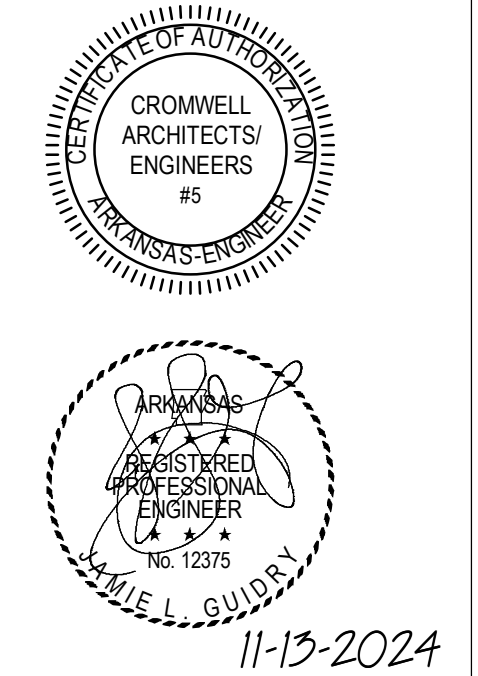


Notes  
1. CROMWELL ARCHITECTS ENGINEERS, INC. ALL RIGHTS RESERVED  
2. THIS SHEET DESIGNED FOR COLOR PRINTING. CRITICAL INFORMATION MAY BE LOST WITH BLACK AND WHITE PRINTING.

Project Number 2024-116  
Issue Date 11-13-2024  
Sheet Title


PLUMBING DETAILS

Sheet Number


P-502

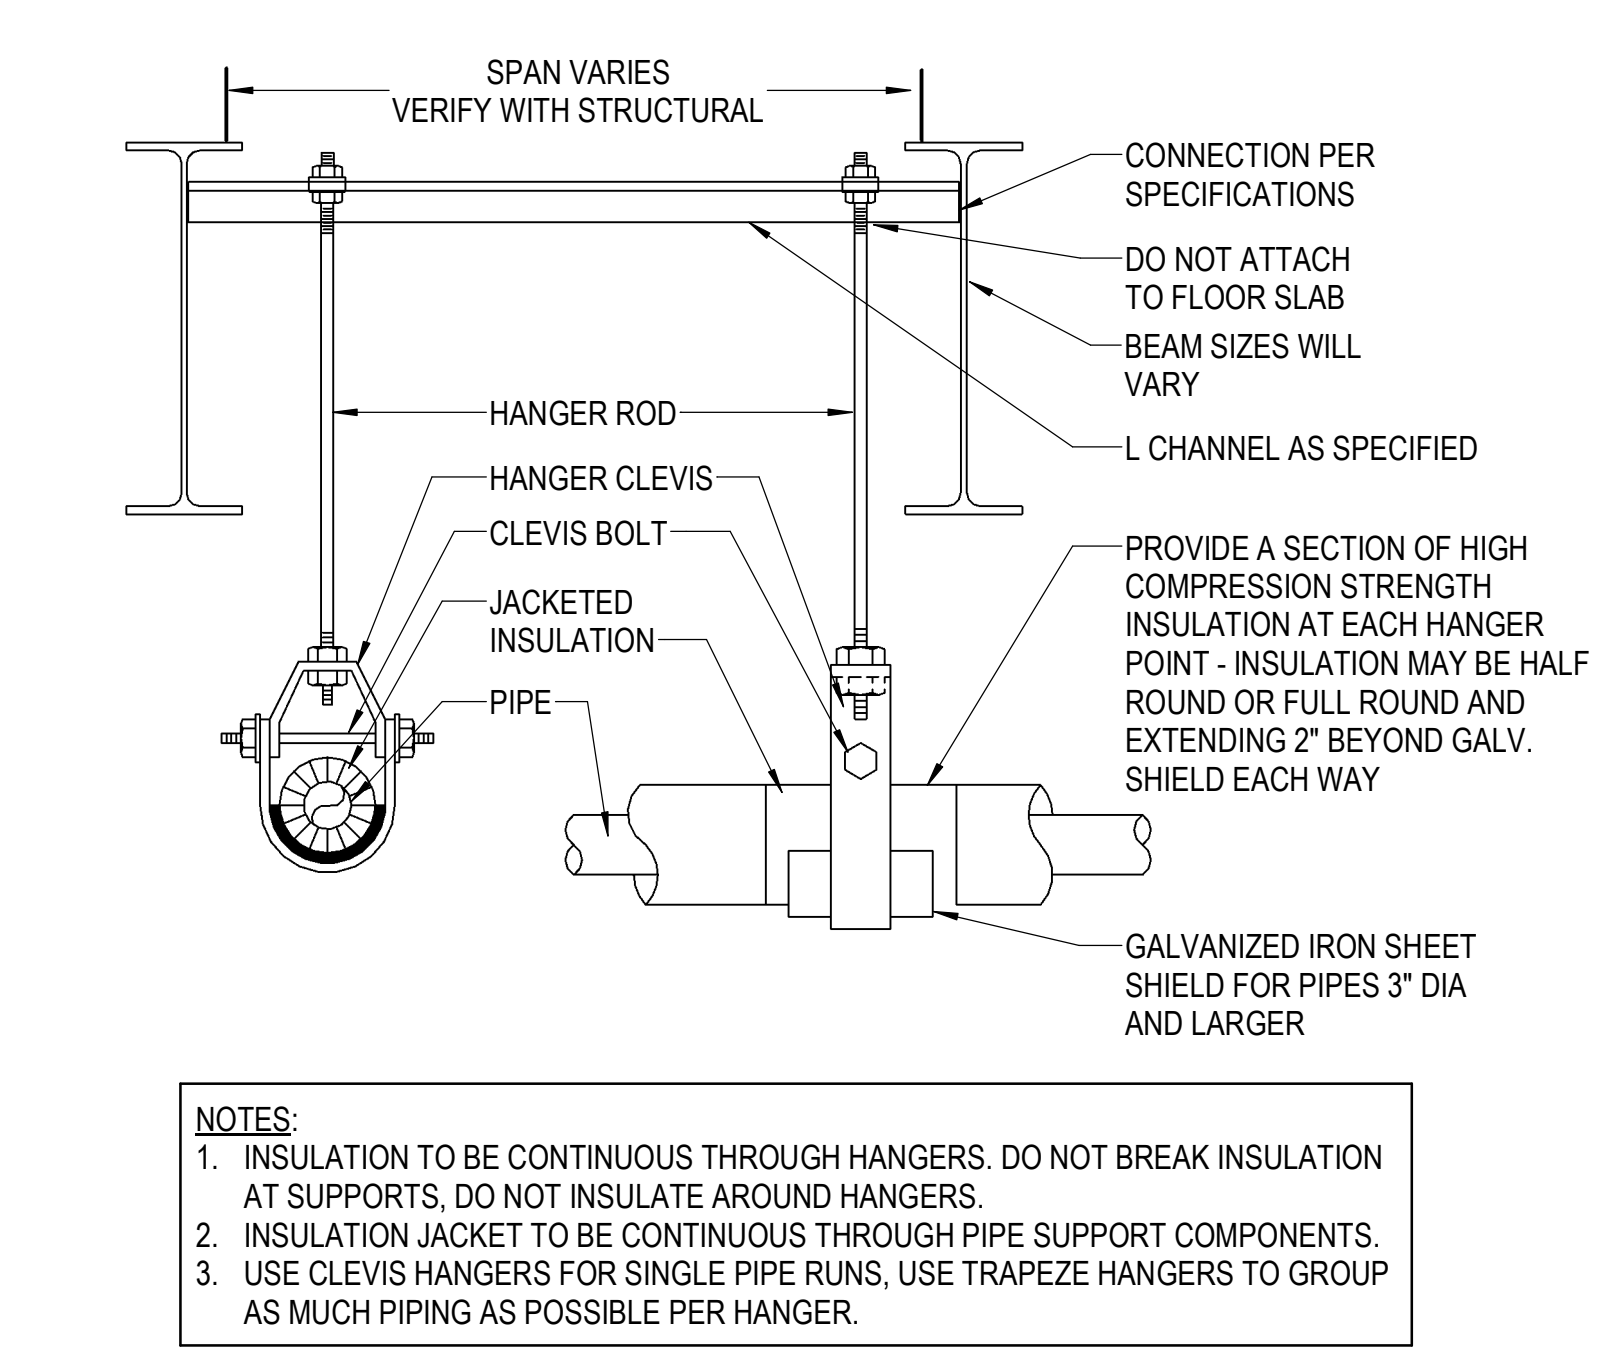





1 ADJUSTABLE CLEVIS HANGER  
NOT TO SCALE

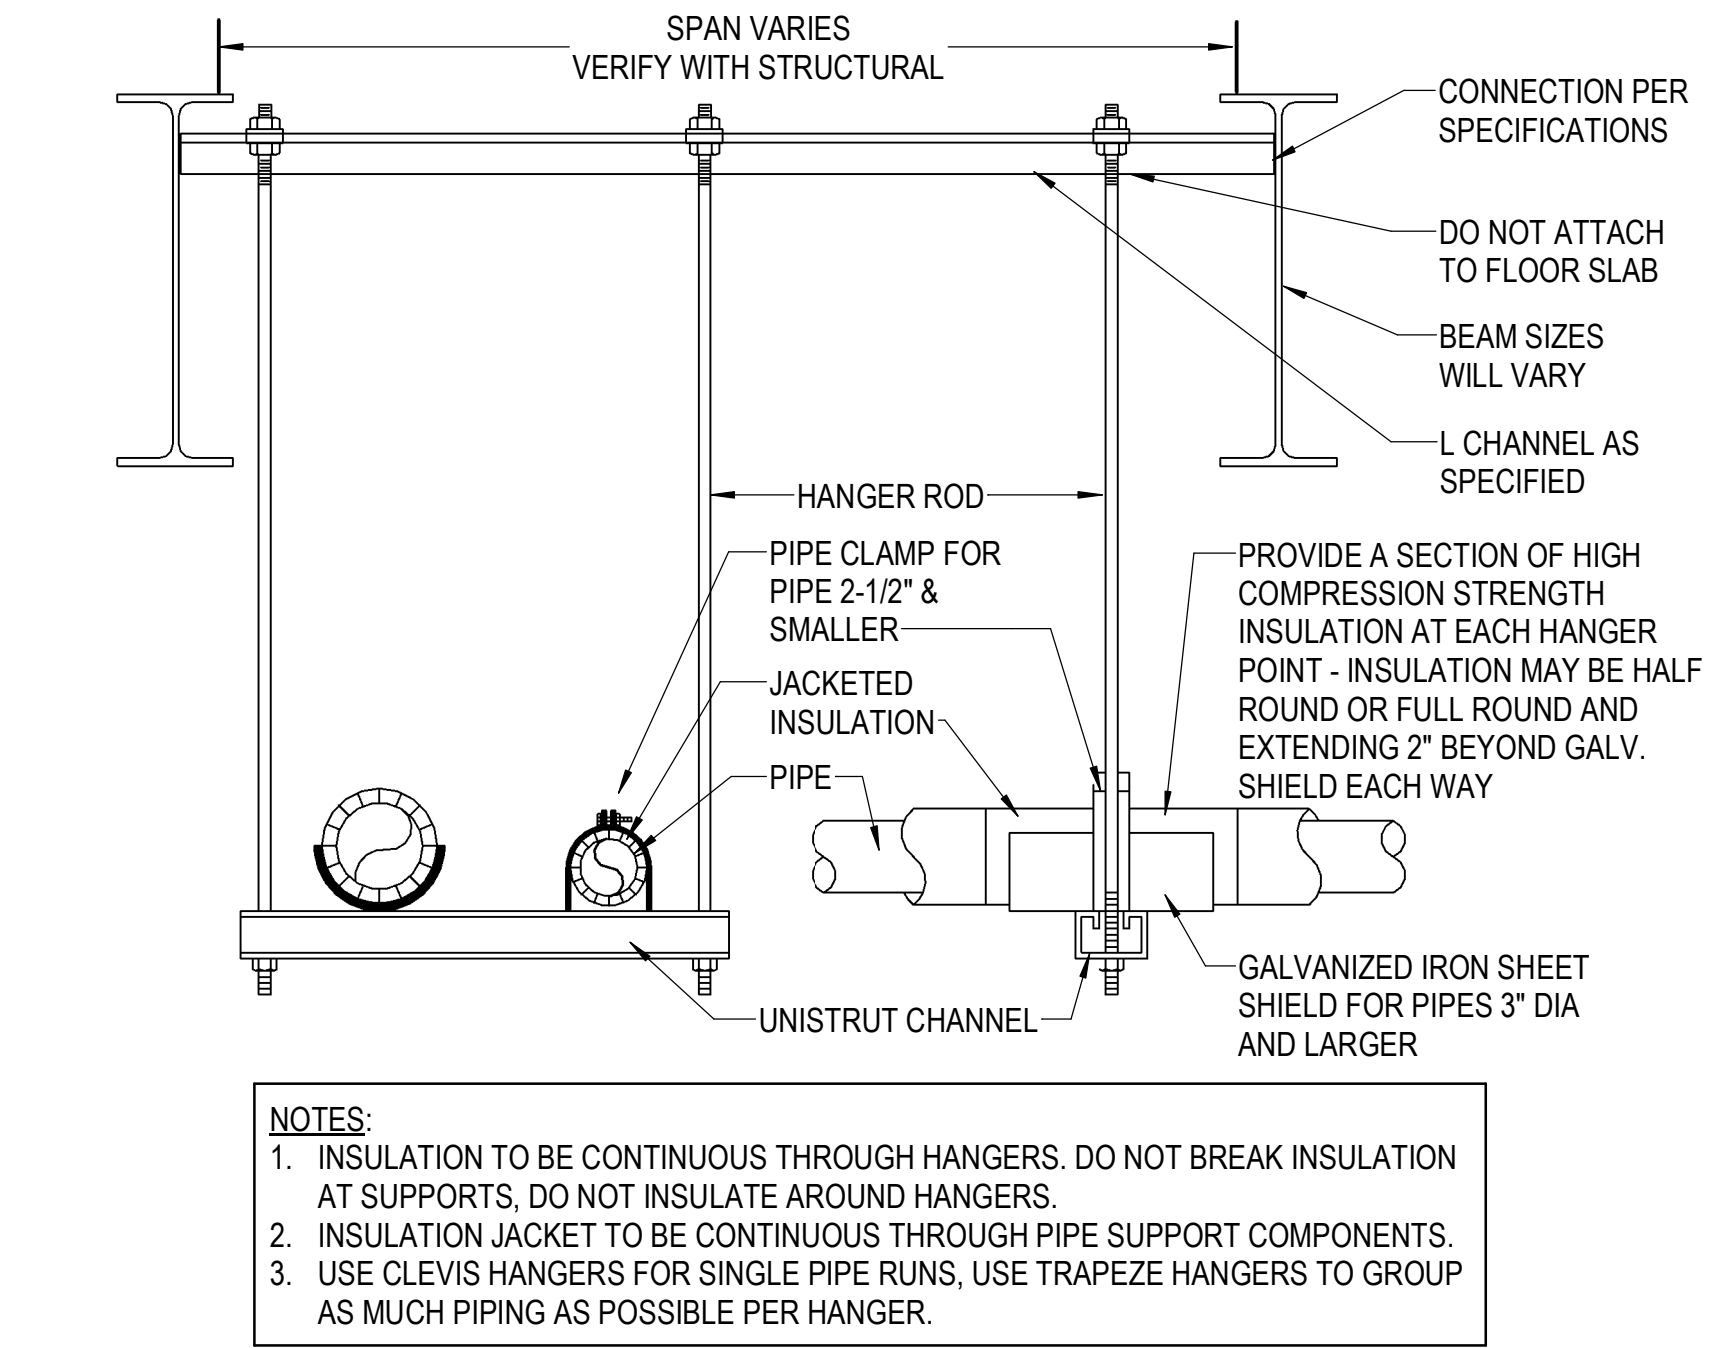

2 TRAPEZE PIPE HANGER  
NOT TO SCALE

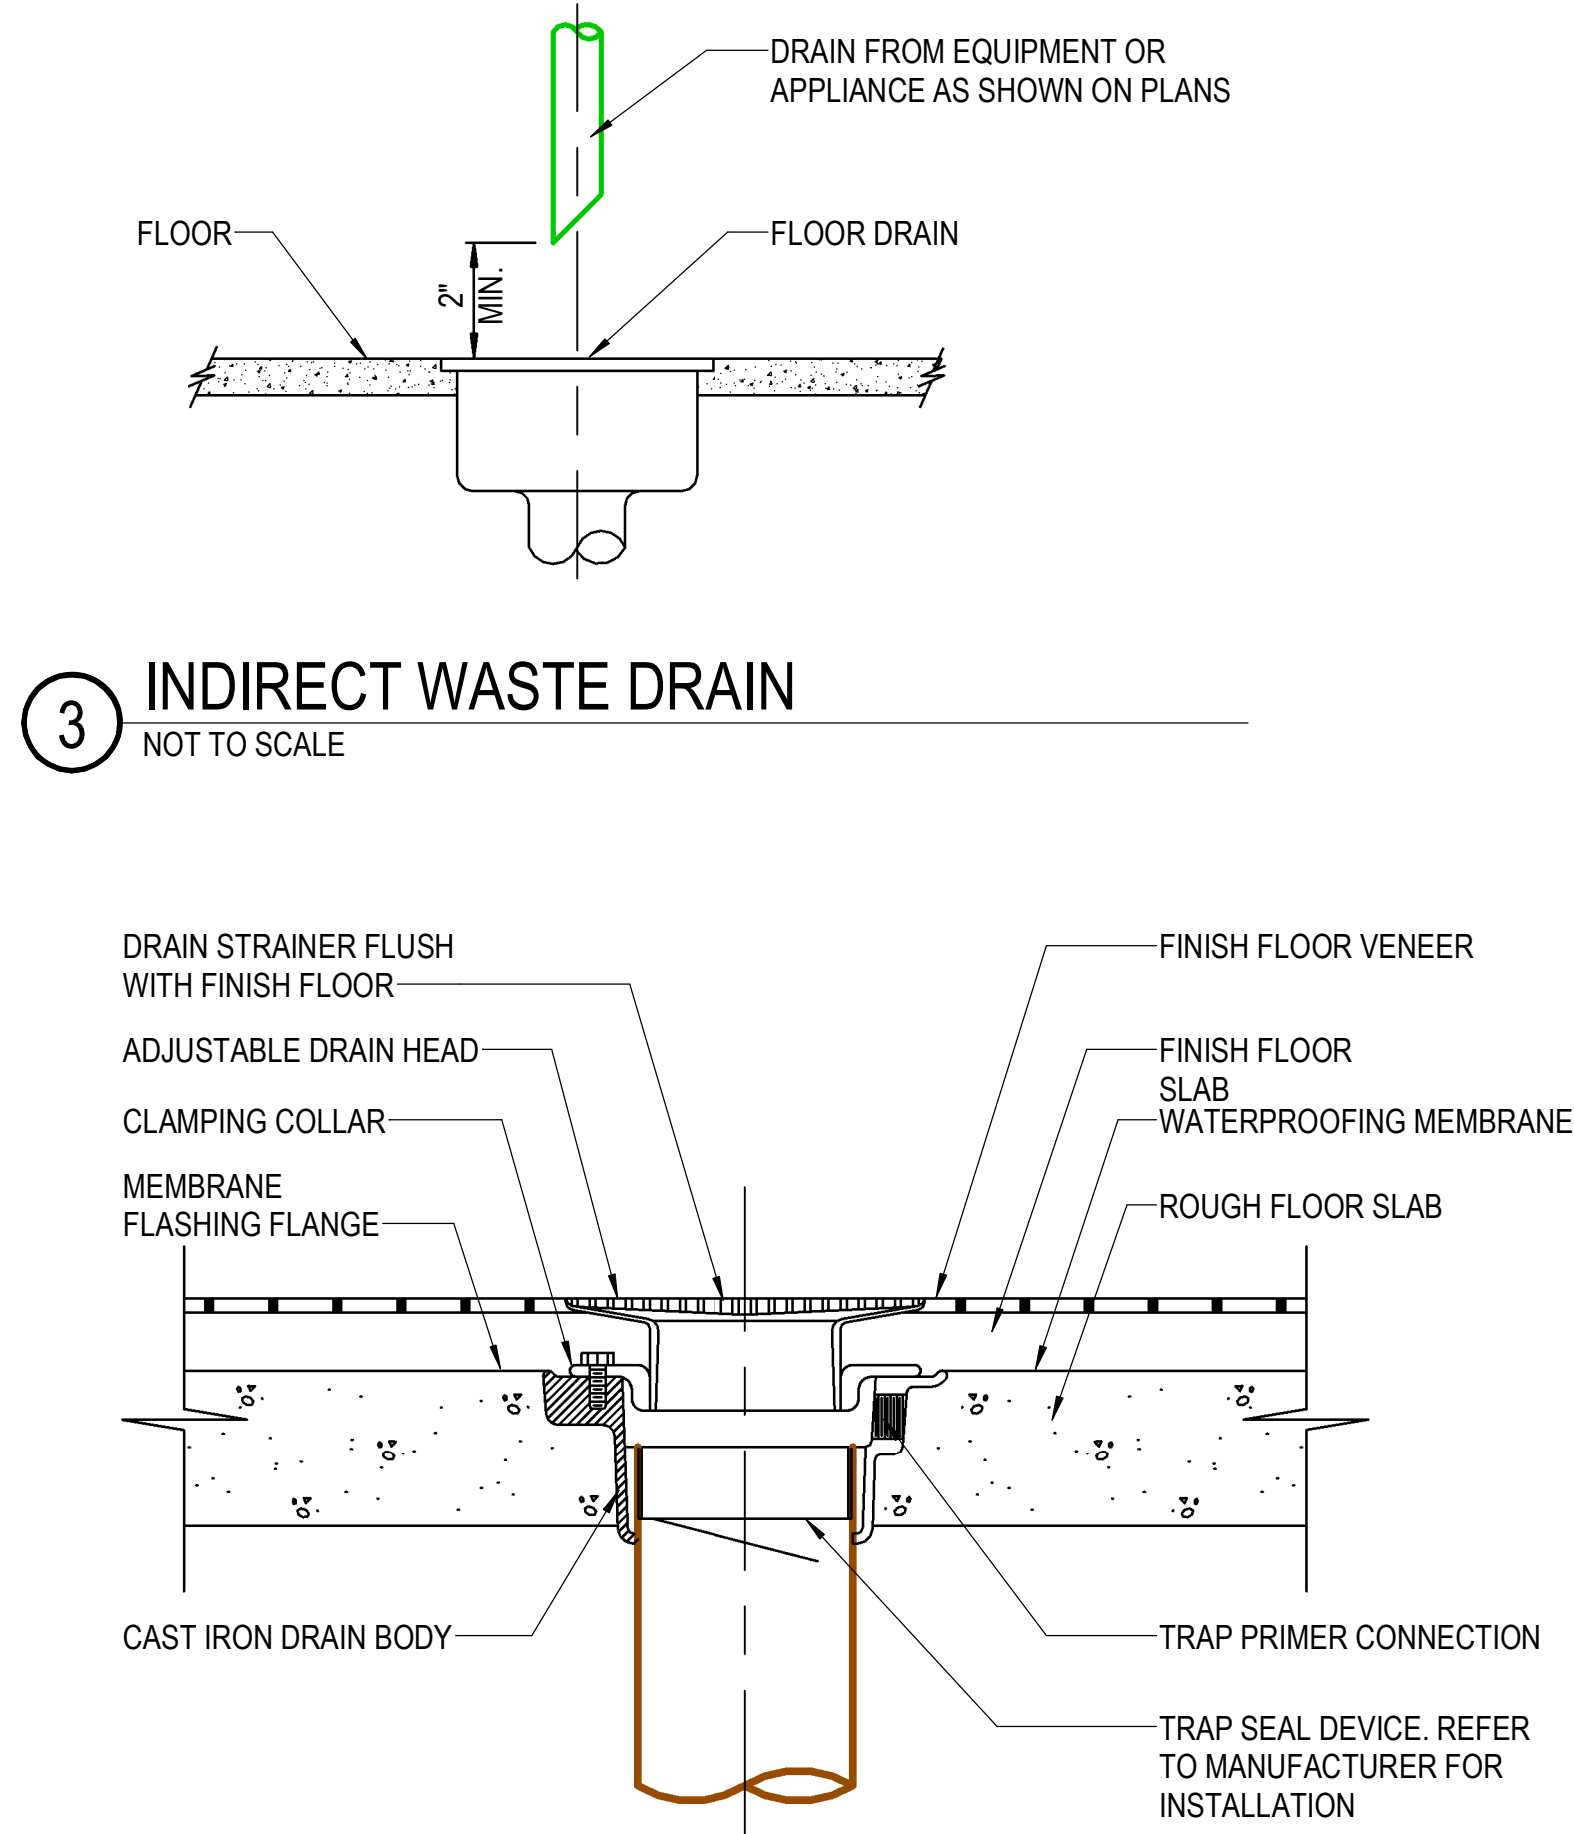

4 TRAP SEAL DEVICE INSTALLATION  
NOT TO SCALE

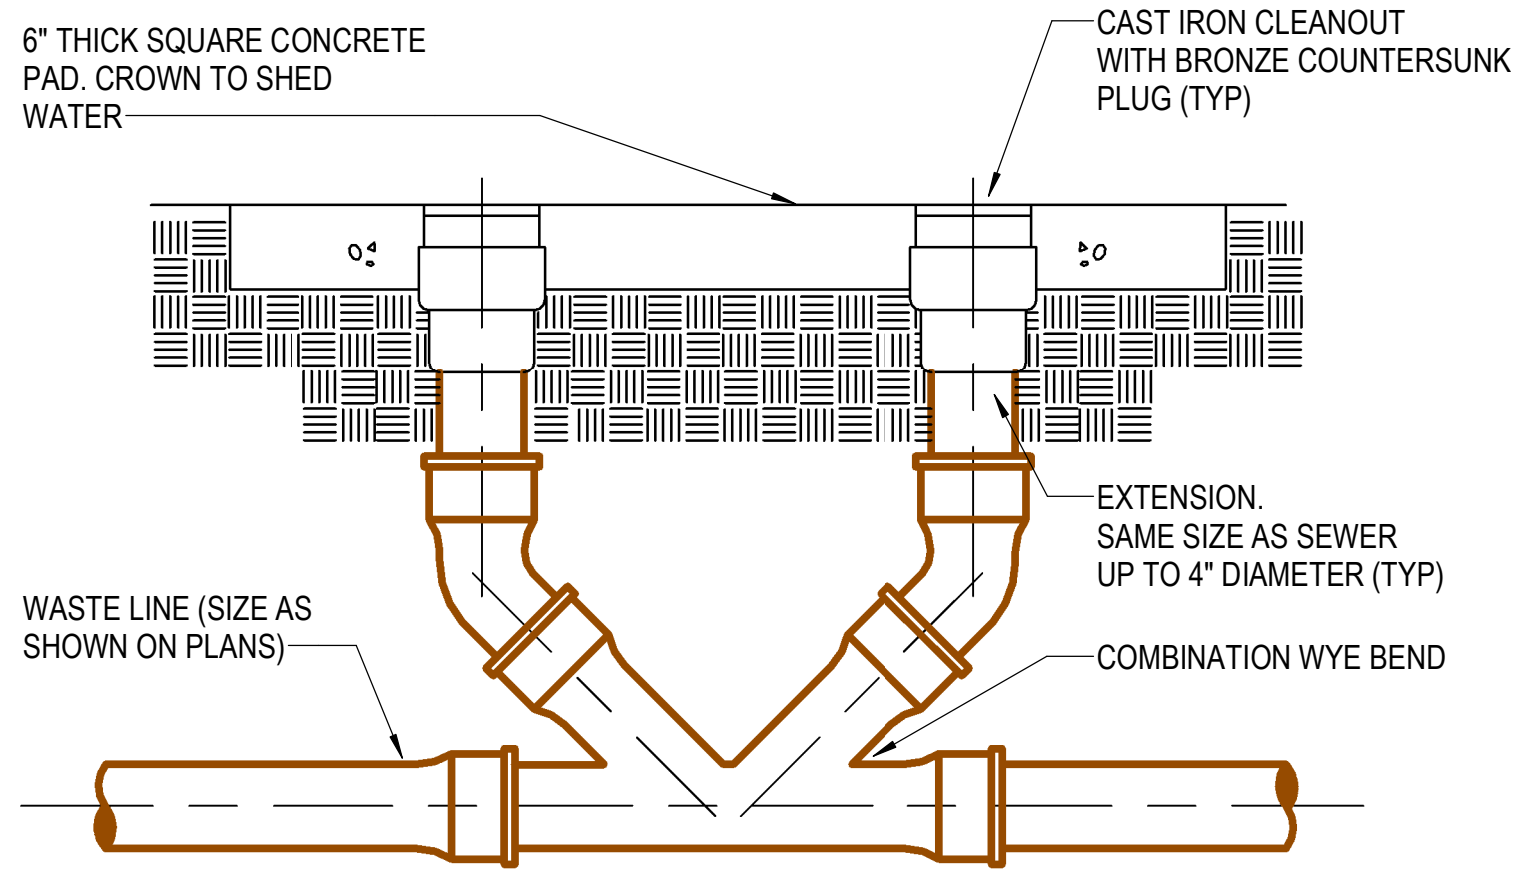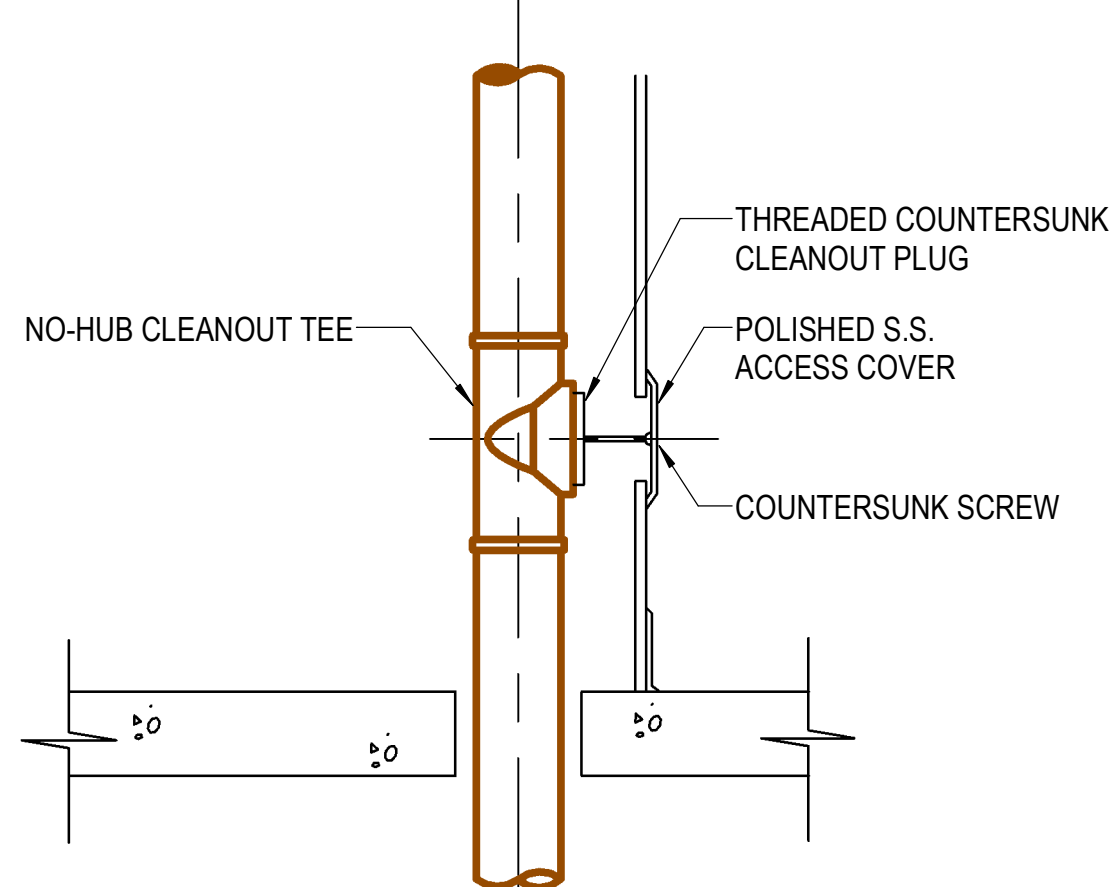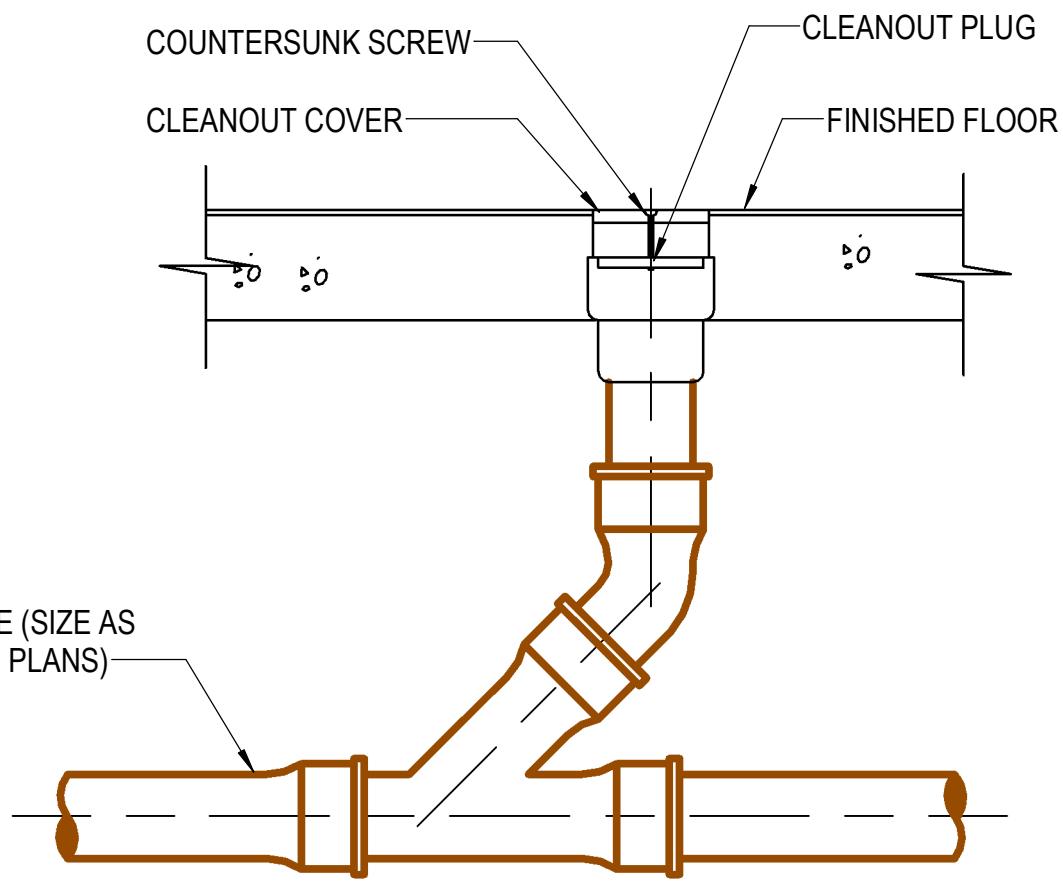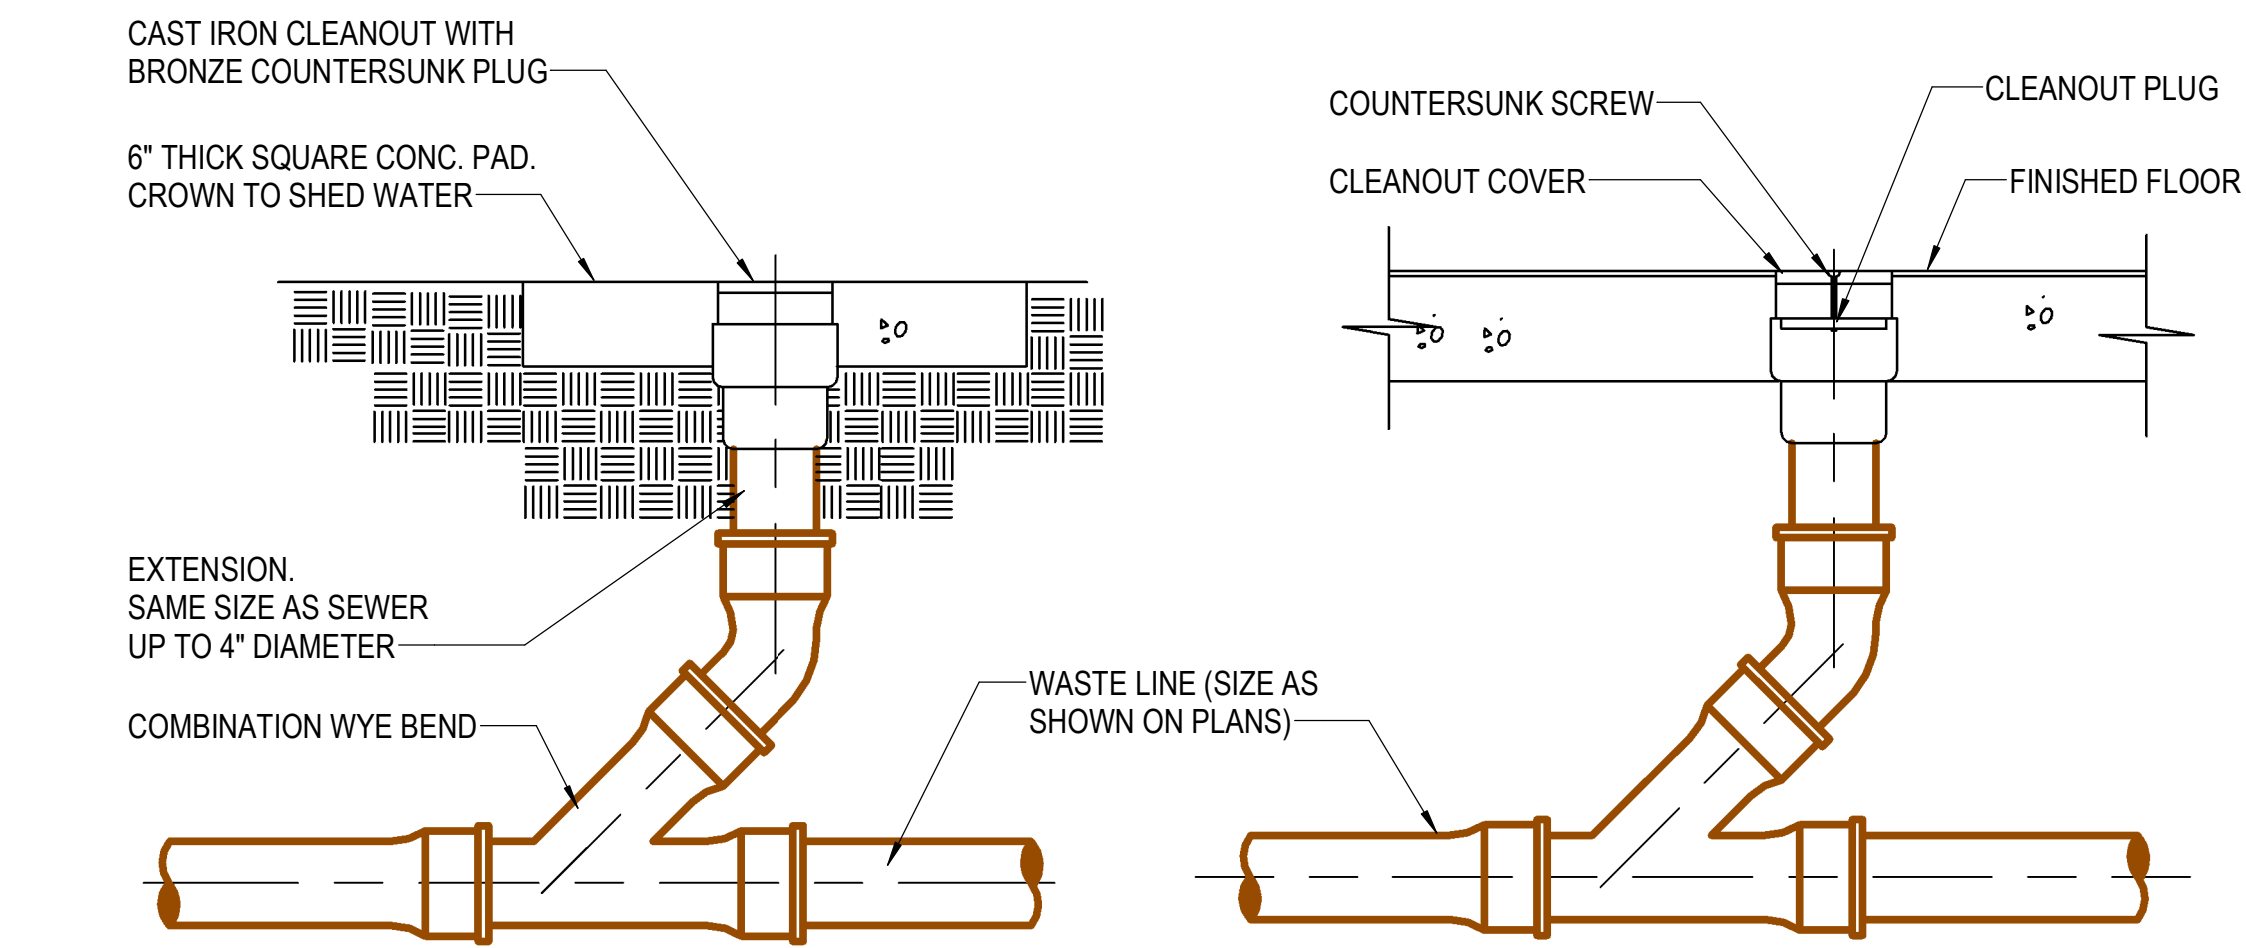

5 TYPICAL CLEANOUTS  
NOT TO SCALE