

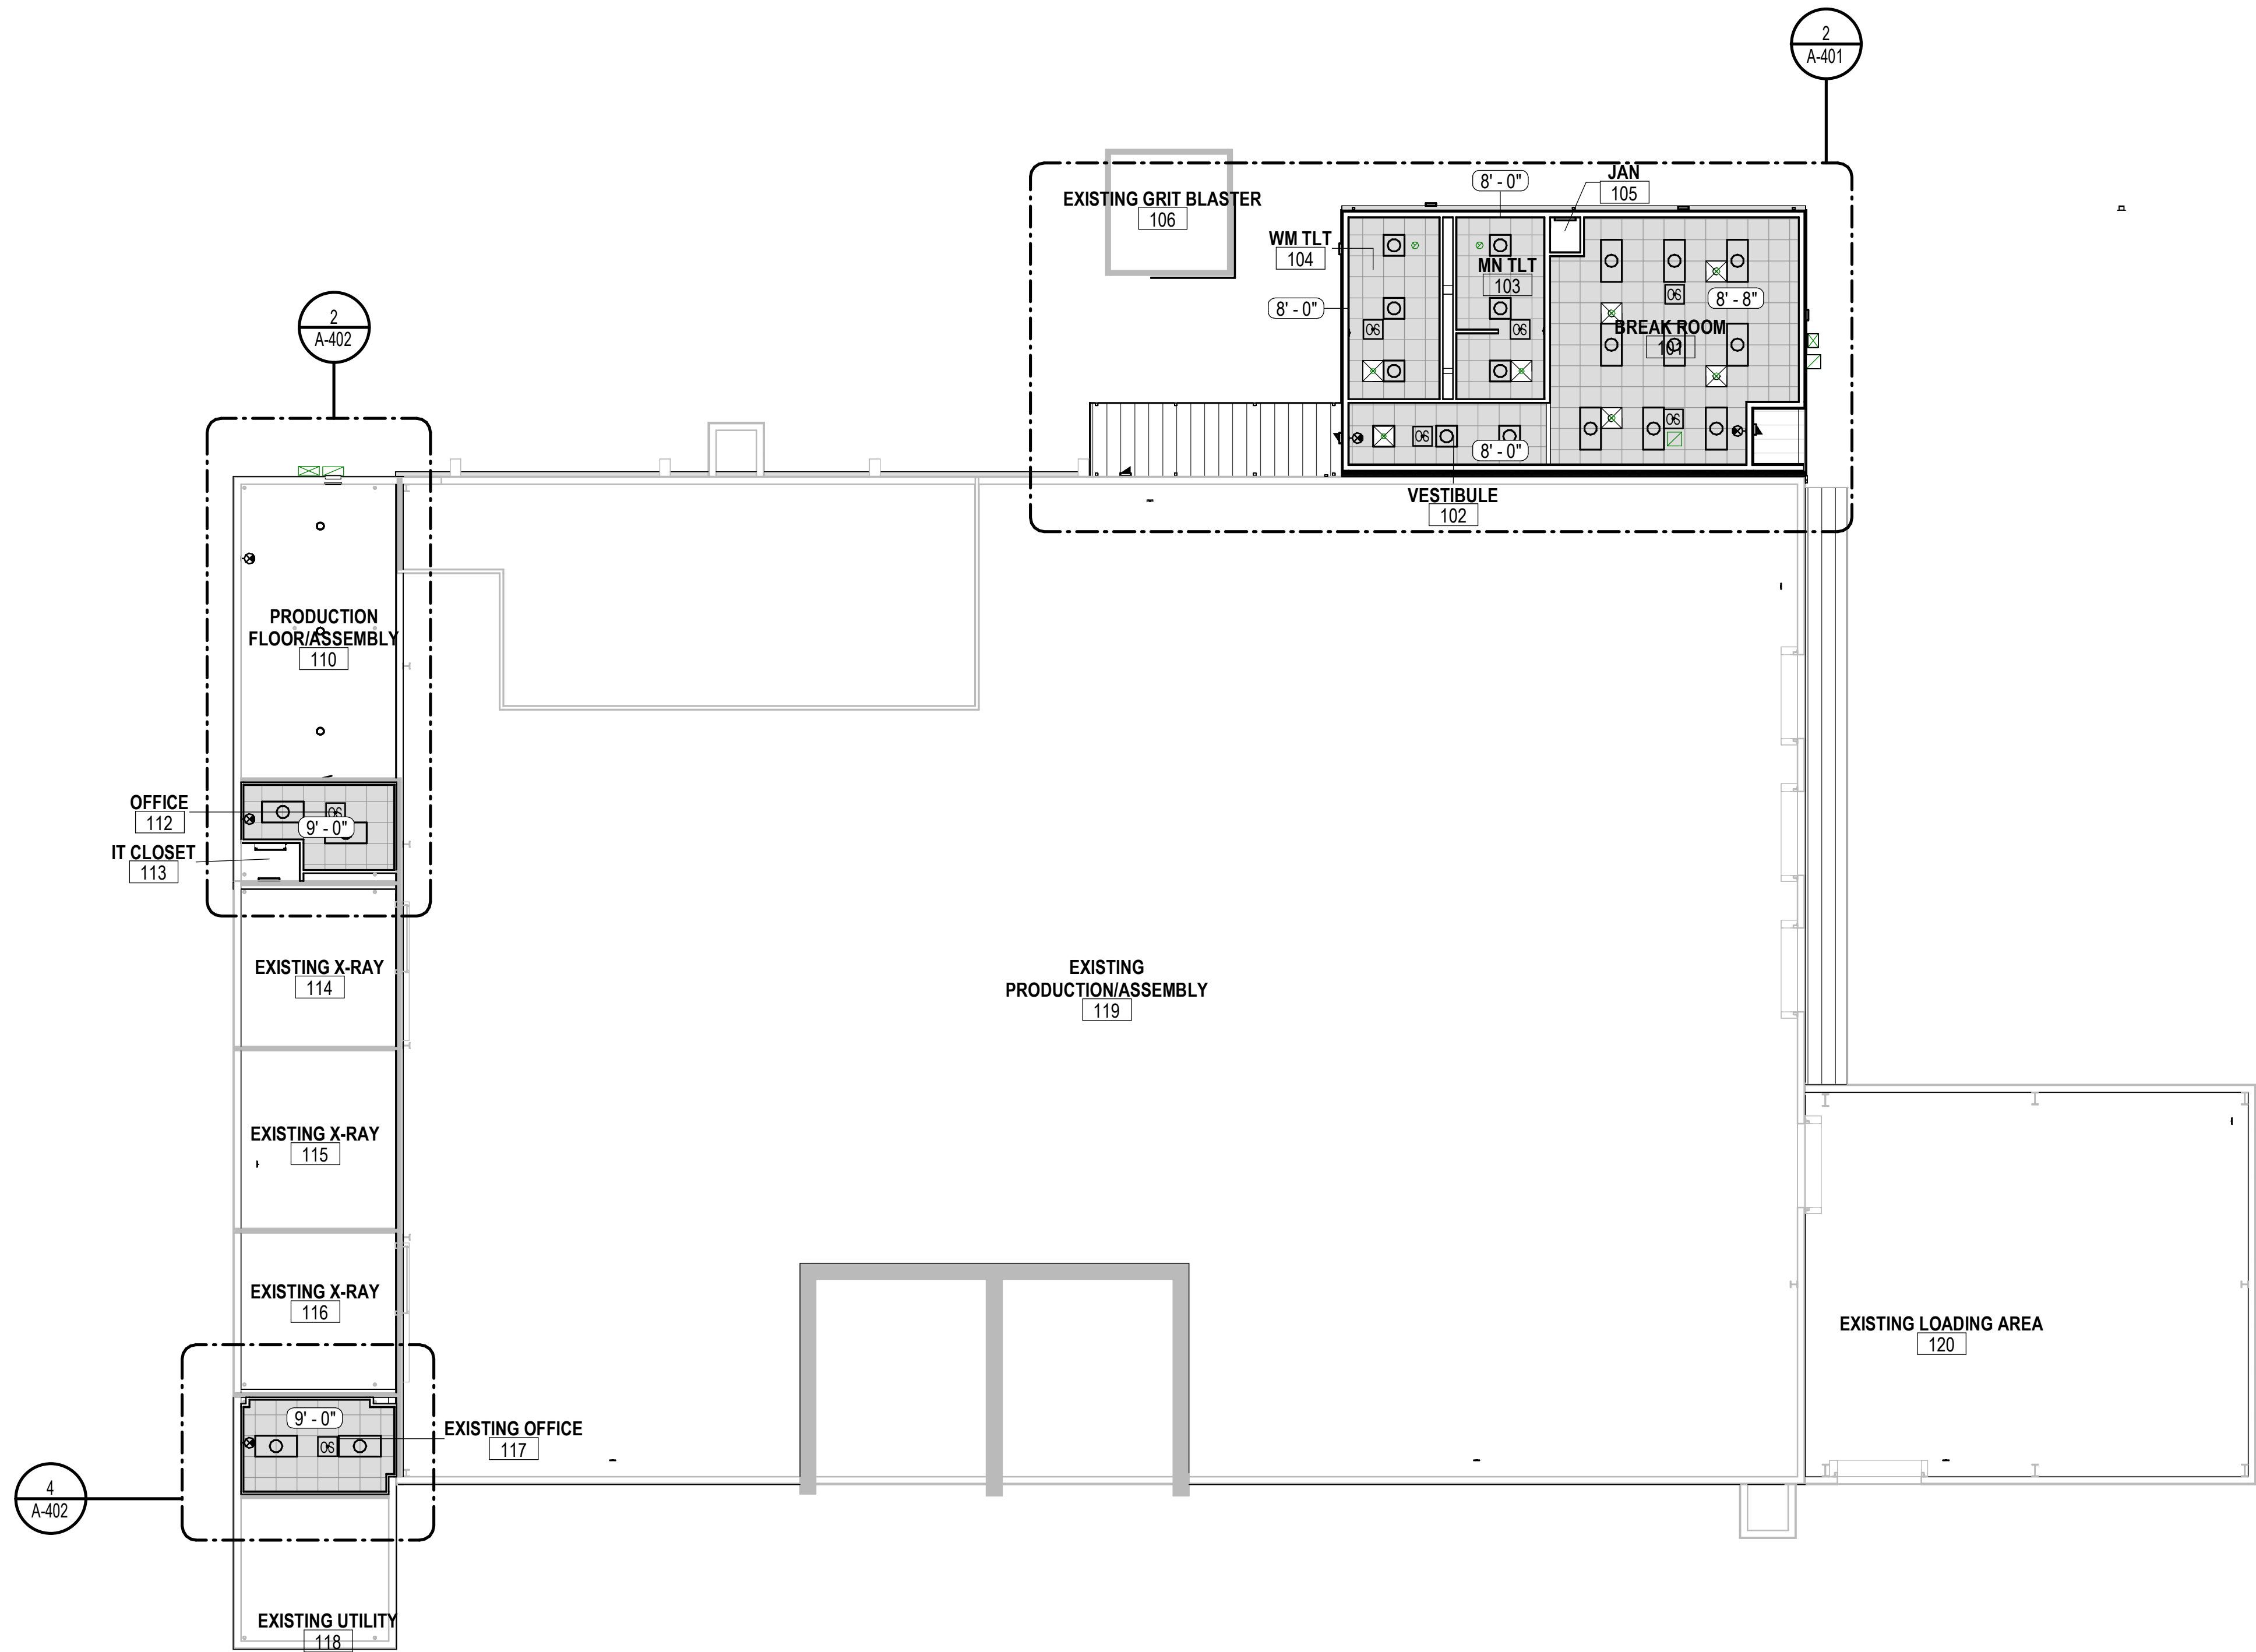


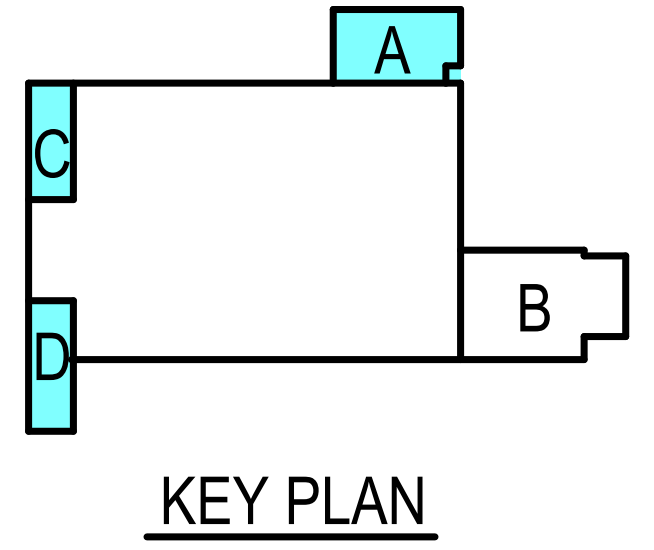

1 OVERALL REFLECTED CEILING PLAN
3/32" = 1'-0"

0 8 16 32
SCALE : 3/32" = 1'-0"

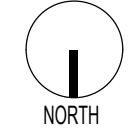

SYMBOLS LEGEND

- LAY-IN ACOUSTICAL CEILING GRID
- GYP. BOARD CEILING - FINISH AS SCHEDULED
- LIGHT FIXTURE - SEE ELECTRICAL DRAWINGS
- EMERGENCY LIGHT FIXTURE - SEE ELECTRICAL DRAWINGS
- EMERGENCY LIGHT FIXTURE W/BATTERY PACK - SEE ELECTRICAL DRAWINGS
- CEILING MOUNTED EXIT LIGHT
- SUPPLY AIR GRILLE
- RETURN AIR GRILLE

REFER TO LIFE SAFETY, MECHANICAL AND ELECTRICAL DRAWINGS FOR ADDITIONAL INFORMATION NOT SHOWN.

Project **AEROJET BUILDING E33 OFFICE EXPANSION, EAST CAMDEN, ARKANSAS**

Design Phase

CONSTRUCTION DOCUMENTS

Revisions		
No.	Date	Description

Stamp

12-19-2024

Notes

- CROMWELL ARCHITECTS ENGINEERS, INC. ALL RIGHTS RESERVED
- THIS SHEET DESIGNED FOR COLOR PRINTING. CRITICAL INFORMATION MAY BE LOST WITH BLACK AND WHITE PRINTING.

Project Number **2024-134**

Issue Date **12-19-2024**

Sheet Title **OVERALL REFLECTED CEILING PLAN**

Sheet Number **A-101R**