

Project

AEROJET BUILDING E33
OFFICE EXPANSION
EAST CAMDEN,
ARKANSAS


Design Phase

CONSTRUCTION
DOCUMENTS

Revisions

No.	Date	Description

Stamp

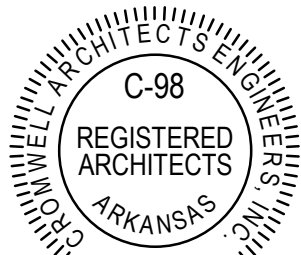

12-19-2024

Notes

- CROMWELL ARCHITECTS ENGINEERS, INC.
ALL RIGHTS RESERVED
- THIS SHEET DESIGNED FOR COLOR PRINTING.
CRITICAL INFORMATION MAY BE LOST WITH
BLACK AND WHITE PRINTING.

Project Number

2024-134

Issue Date


12-19-2024

Sheet Title

DEMOLITION PLAN


Sheet Number

AD101

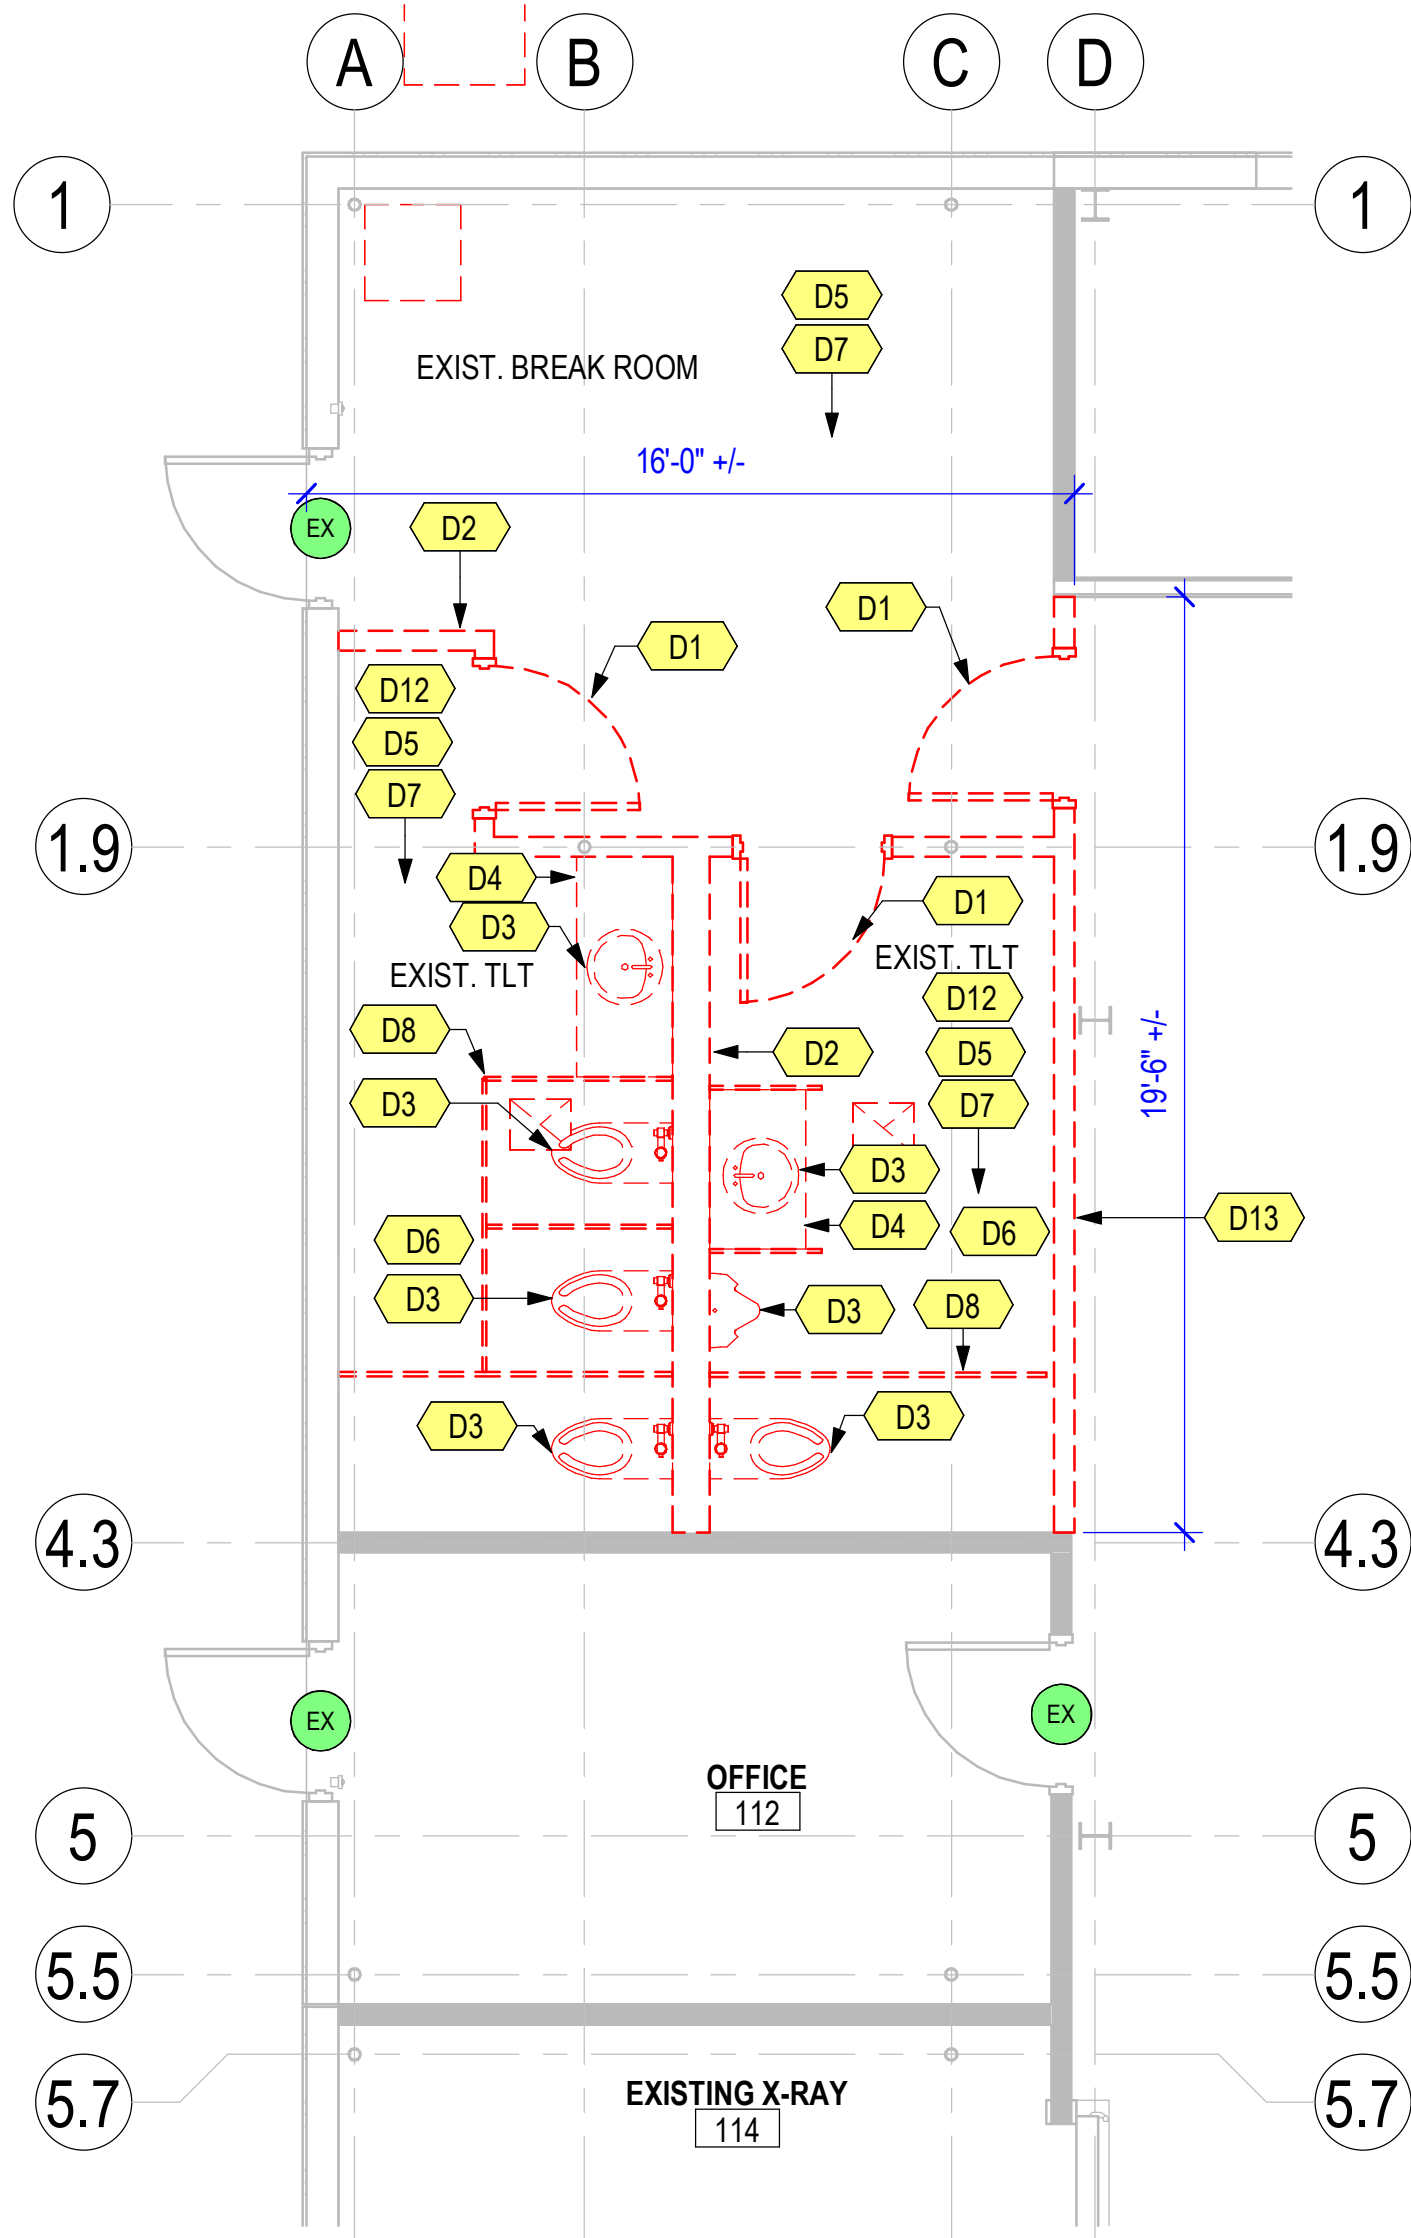

1 AREA C DEMOLITION PLAN



1/4" = 1'-0"

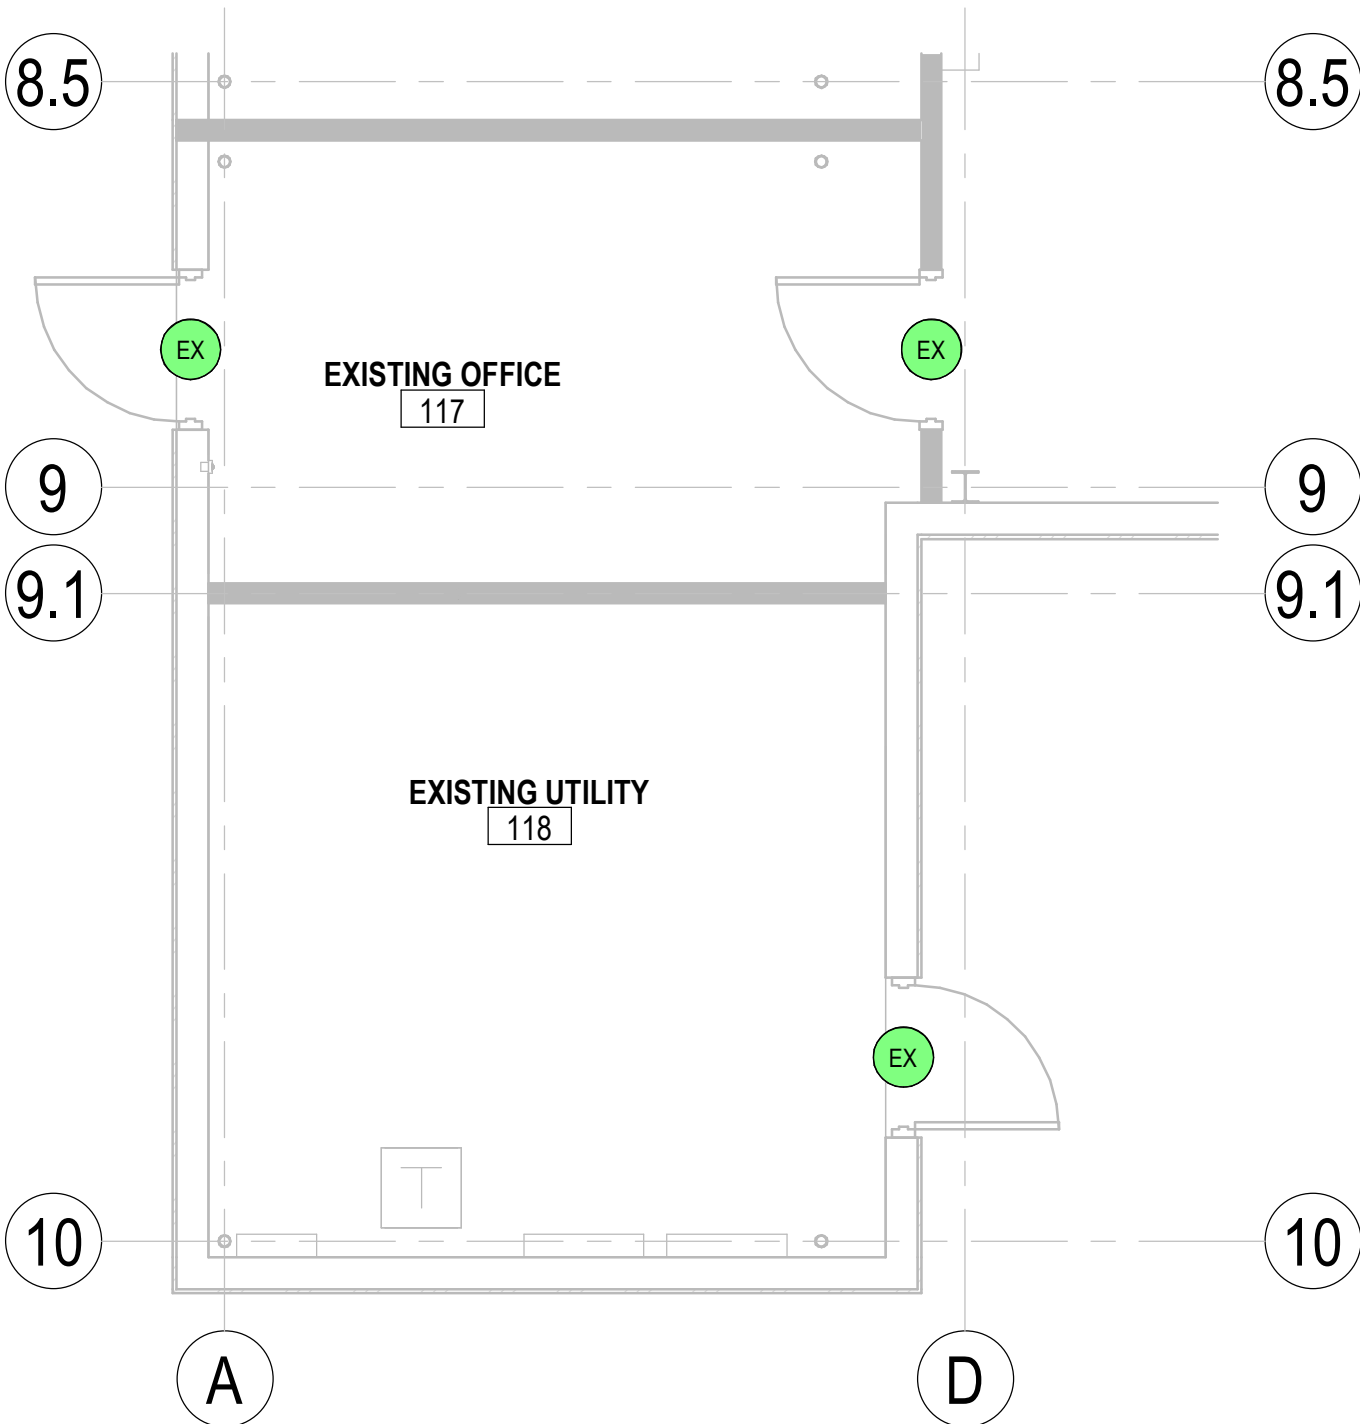

2 AREA D DEMOLITION PLAN

1/4" = 1'-0"

DEMOLITION KEYNOTE LEGEND	
KEY VALUE	DESCRIPTION
D1	REMOVE DOOR, HARDWARE AND FRAME. REMIT TO OWNER FOR REUSE.
D2	DEMO WALL
D3	REMOVE PLUMBING FIXTURE, CAP PLUMBING LINES.
D4	DEMO MILLWORK
D5	DEMO CEILING, LIGHT FIXTURES AND GRILLS
D6	REMOVE TOILET ACCESSORIES. REMIT TO OWNER FOR REUSE.(TYPICAL)
D7	DEMO FLOOR FINISH
D8	DEMO TOILET PARTITION
D12	DEMO WALL MOUNTED EXHAUST FAN. PATCH WALL PENETRATION TO MATCH EXISTING.
D13	DEMO WALL TO BOTTOM OF LOW ROOF STRUCTURE

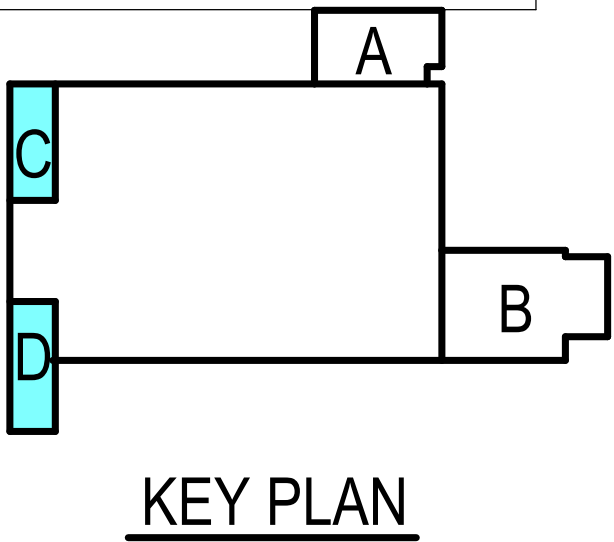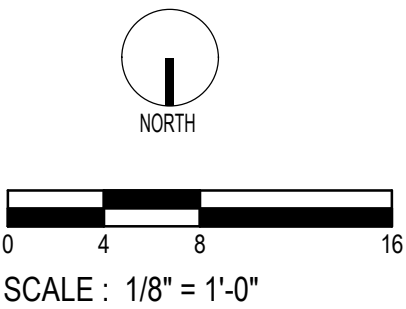

KEY PLAN