



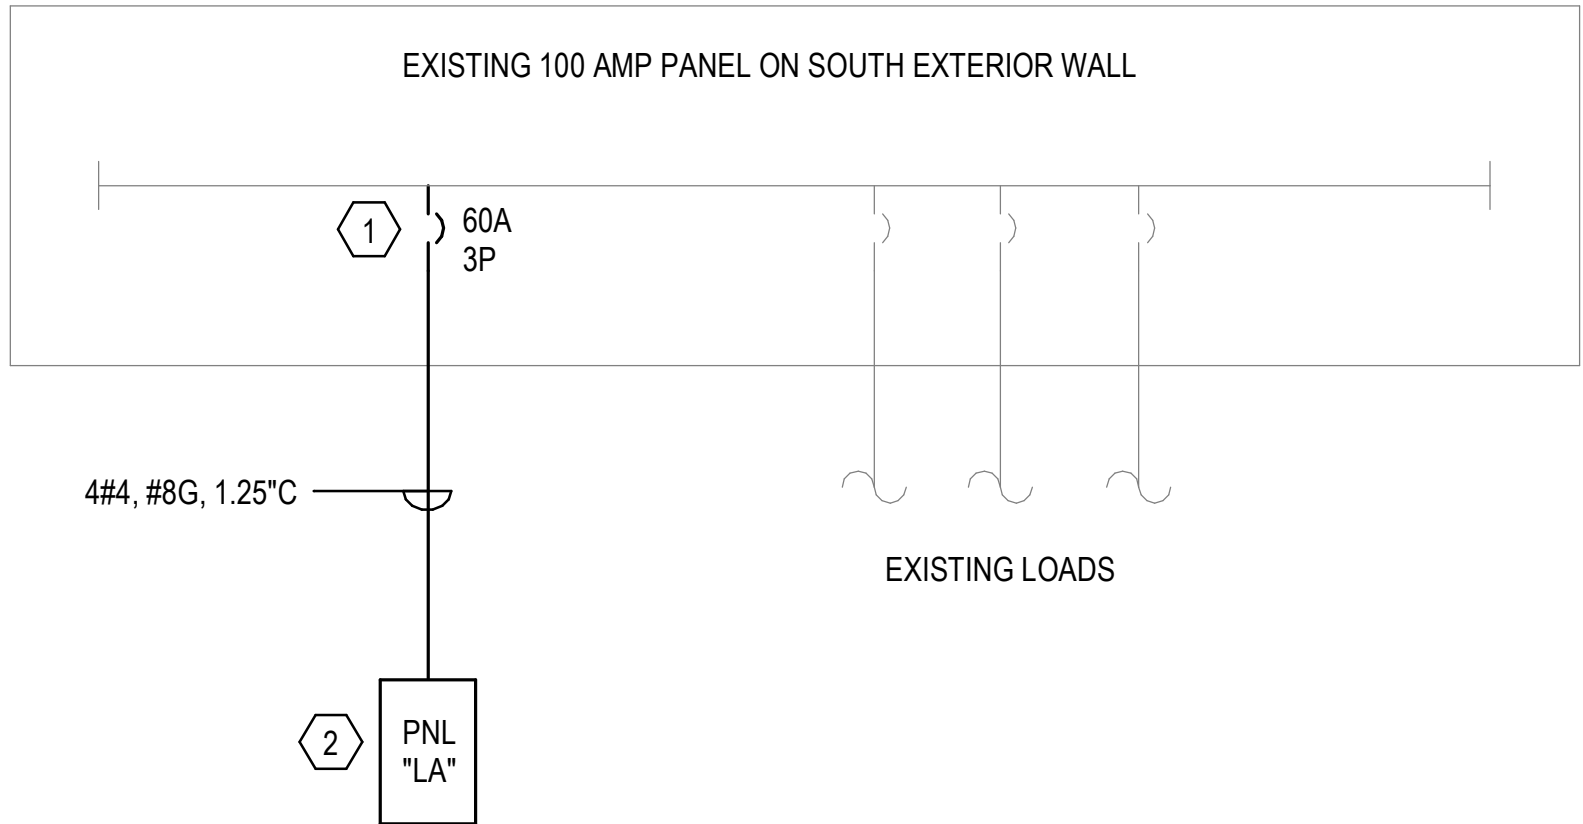

1 PARTIAL SINGLE - LINE DIAGRAM - NEW BREAK ROOM
N.T.S.

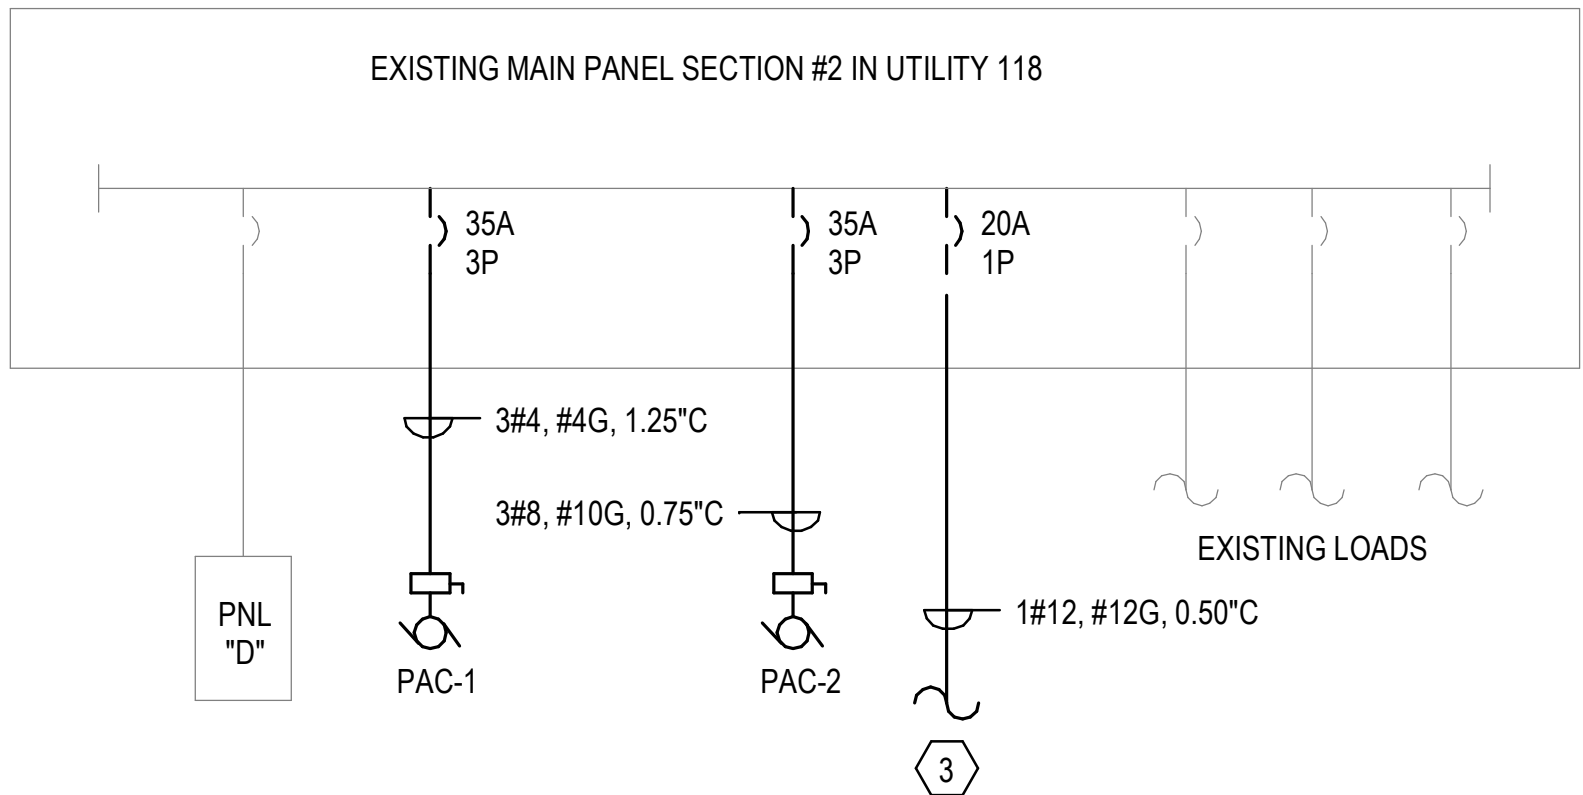

2 PARTIAL SINGLE - LINE DIAGRAM - UTILITY 118
N.T.S.

KEYED NOTES:

- 1 PROVIDE NEW COMPATIBLE 60 AMP, 3P CIRCUIT BREAKER IN EXISTING PANELBOARD. MATCH KAIC RATING OF EXISTING PANELBOARD.
- 2 NEW PANELBOARD. SEE PANEL SCHEDULE ON SHEET E-602 FOR PANEL RATING.
- 3 PROVIDE NEW COMPATIBLE 20 AMP, 1P CIRCUIT BREAKER IN EXISTING PANELBOARD FOR LIGHTS IN NEW PRODUCTION AREA. MATCH KAIC RATING OF EXISTING PANELBOARD.

Project

AEROJET BUILDING E33
OFFICE EXPANSION
EAST CAMDEN,
ARKANSAS

Design Phase



CONSTRUCTION
DOCUMENTS

Revisions

No. Date Description

No.	Date	Description

Stamp

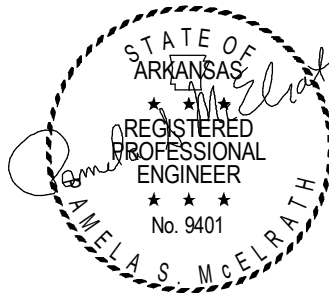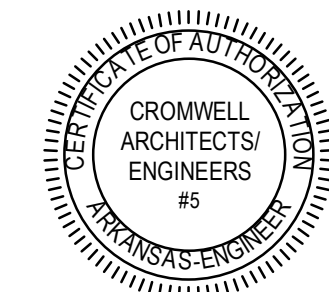

Notes

1. CROMWELL ARCHITECTS ENGINEERS, INC. ALL RIGHTS RESERVED
2. THIS SHEET DESIGNED FOR COLOR PRINTING. CRITICAL INFORMATION MAY BE LOST WITH BLACK AND WHITE PRINTING.

Project Number

2024-134

Issue Date

12-19-2024

Sheet Title

ELECTRICAL
SINGLE-LINE DIAGRAM

Sheet Number

E-601