


1 POWER PLAN - AREA A  
1/4" = 1'-0"

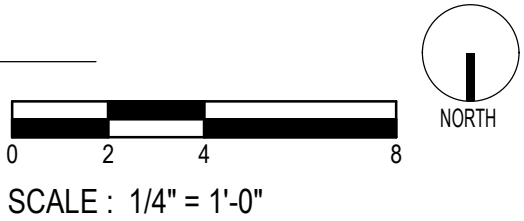


GENERAL NOTES:

- A. LOCATIONS INDICATED IN DRAWINGS ARE APPROXIMATE. COORDINATE WITH INSTALLER ON EXACT LOCATIONS.
- B. CONTRACTOR SHALL WIRE EQUIPMENT PER MANUFACTURER INSTRUCTIONS. ALL WIRING AND CONNECTIONS SHALL BE PER MANUFACTURER'S RECOMMENDATIONS.
- C. COORDINATE ALL CONDUIT LOCATIONS WITH OTHER DISCIPLINES.
- D. POWER INDICATED ON PLANS IS BASED ON BASIS OF DESIGN. IF DIFFERENT EQUIPMENT IS USED CONTRACTOR SHALL PROVIDE POWER PER MANUFACTURER'S RECOMMENDATIONS AT NO EXTRA CHARGE.

KEYED NOTES:

- 1 NEW PANELBOARD TO BE NAMED FOLLOWING EXISTING AEROJET NOMENCLATURE.
- 2 EXISTING 208/120V, 100 AMP PANEL.
- 3 EXISTING 50KVA TRANSFORMER.
- 4 EXISTING 480V PANEL.
- 5 DISCONNECT POWERS EWH-1 WATER HEATER. COORDINATE EXACT LOCATION WITH PLUMBING.

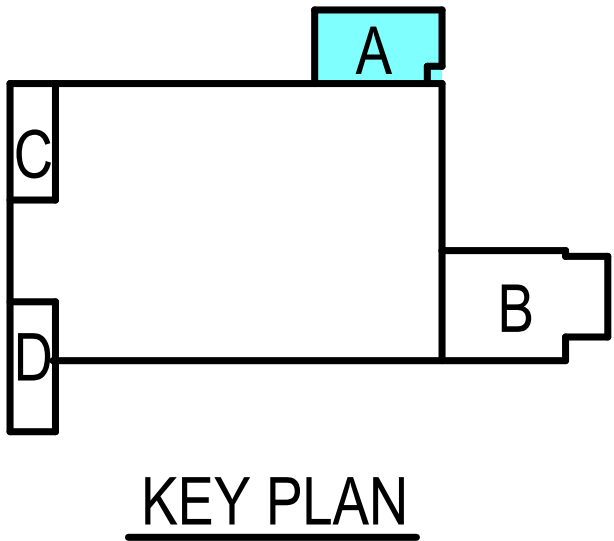

Project

AEROJET BUILDING E33  
OFFICE EXPANSION  
EAST CAMDEN,  
ARKANSAS

Design Phase

CONSTRUCTION  
DOCUMENTS

Revisions		
No.	Date	Description

Stamp

CROMWELL ARCHITECTS/ENGINEERS #5

STATE OF ARKANSAS  
REGISTERED PROFESSIONAL ENGINEER  
No. 9401  
AMELIA S. McELRATH

12-19-2024

Notes

1. CROMWELL ARCHITECTS ENGINEERS, INC. ALL RIGHTS RESERVED

2. THIS SHEET DESIGNED FOR COLOR PRINTING. CRITICAL INFORMATION MAY BE LOST WITH BLACK AND WHITE PRINTING.

Project Number 2024-134

Issue Date 12-19-2024

Sheet Title

POWER PLAN - AREA A

Sheet Number

EP101A