

Project



AEROJET BUILDING E33
OFFICE EXPANSION
EAST CAMDEN,
ARKANSAS

Design Phase

CONSTRUCTION
DOCUMENTS

Revisions		
No.	Date	Description

Stamp

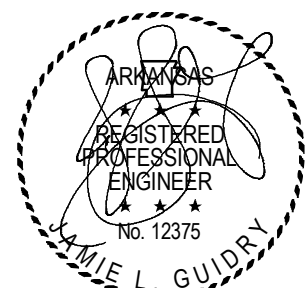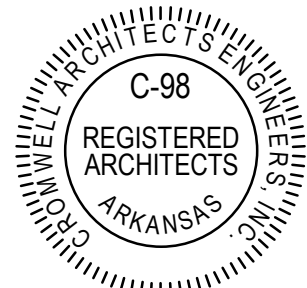

12-19-2024

Notes

- CROMWELL ARCHITECTS ENGINEERS, INC. ALL RIGHTS RESERVED
- THIS SHEET DESIGNED FOR COLOR PRINTING. CRITICAL INFORMATION MAY BE LOST WITH BLACK AND WHITE PRINTING.

Project Number

2024-134

Issue Date


12-19-2024

Sheet Title


MECHANICAL DETAILS

Sheet Number


M-501

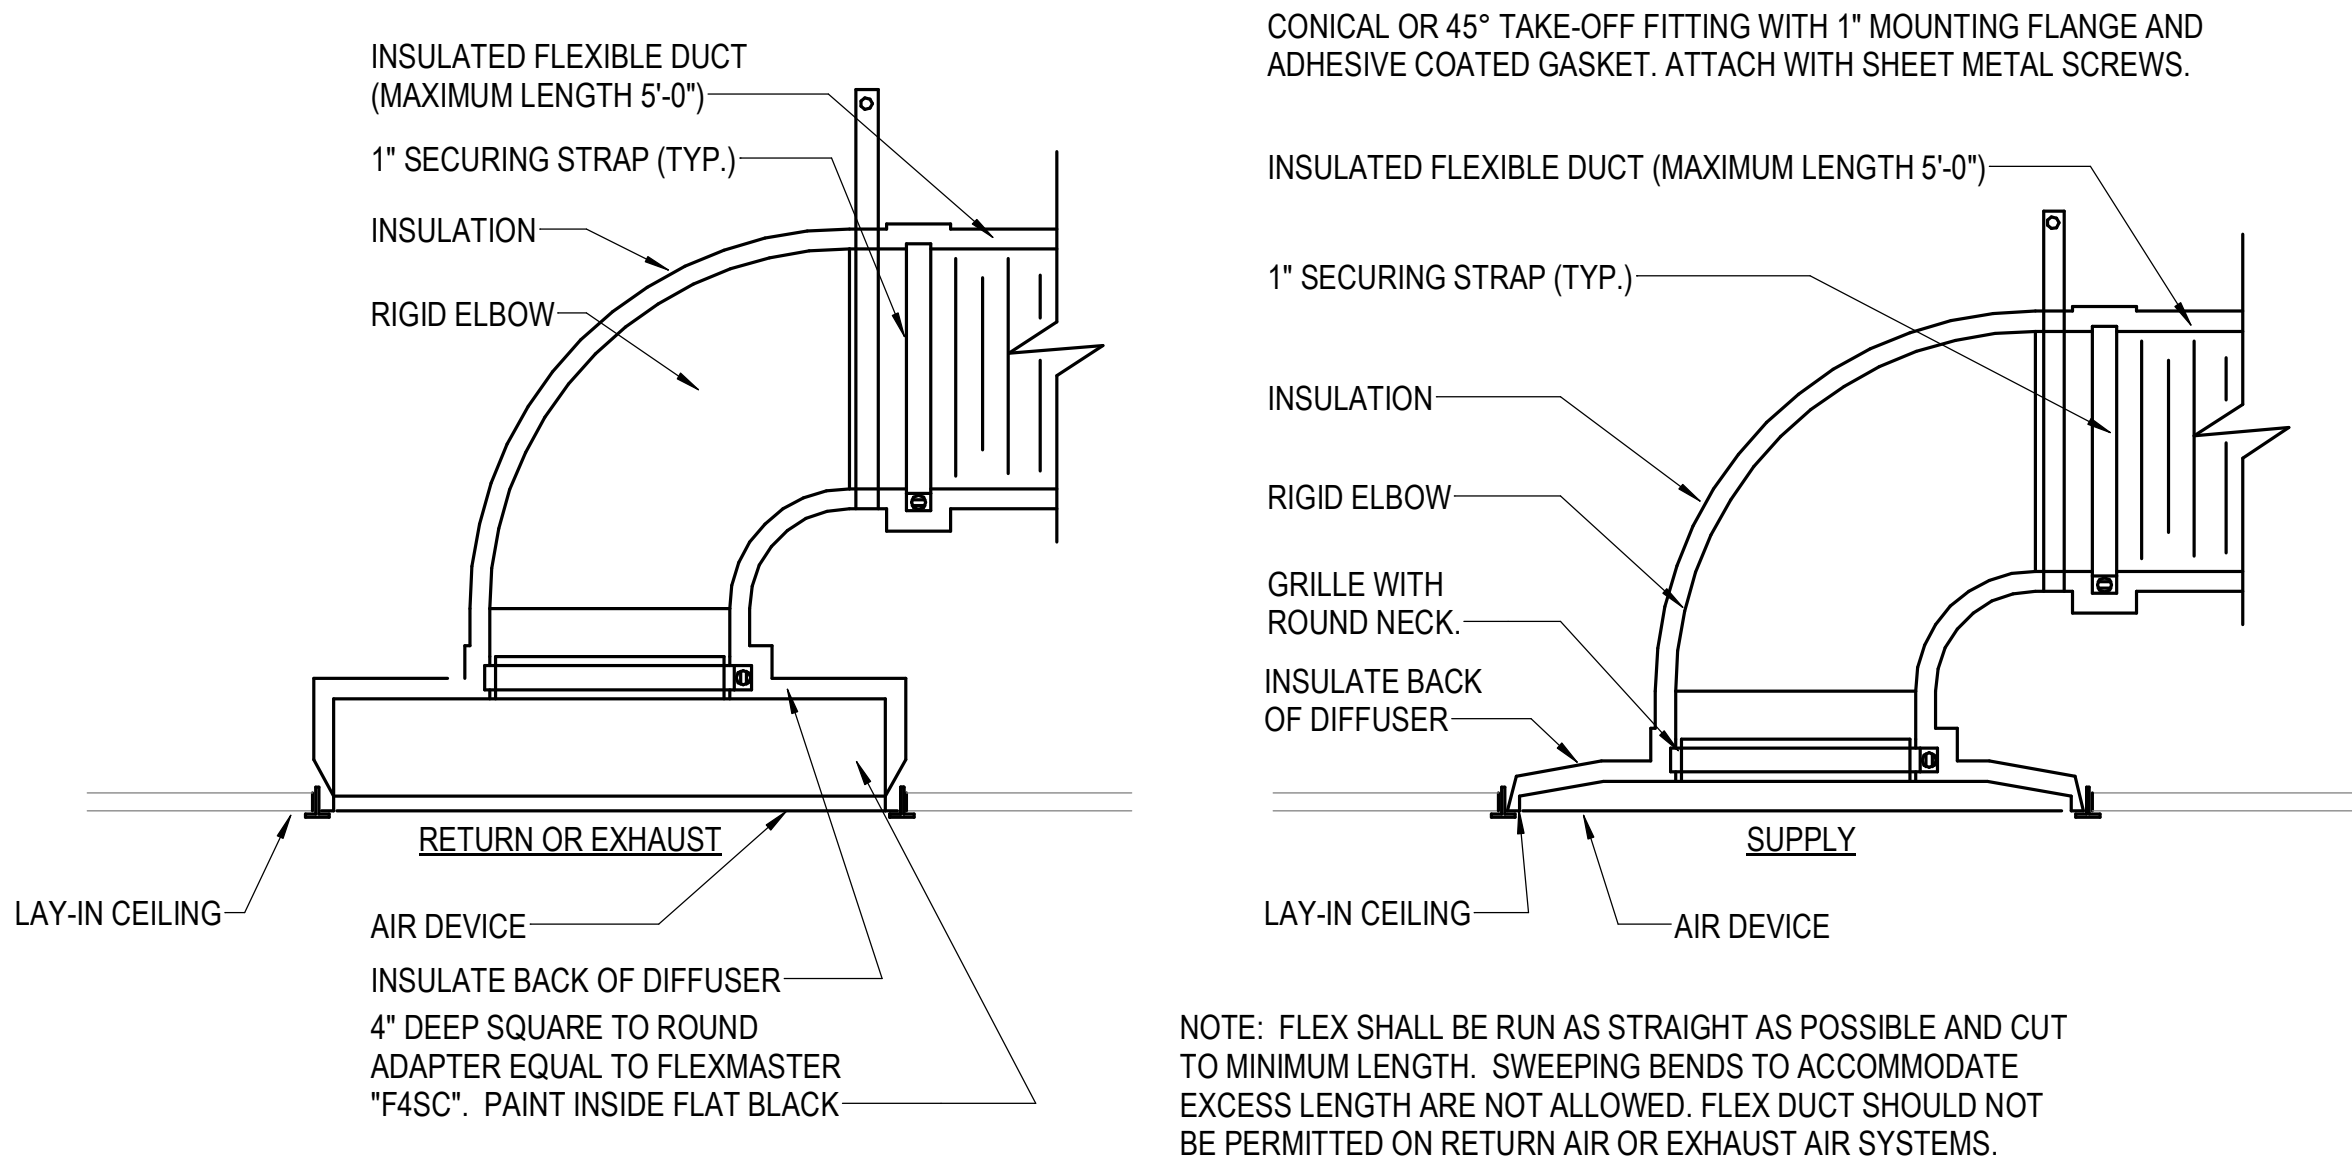


1 AIR DEVICE CONNECTION
NOT TO SCALE

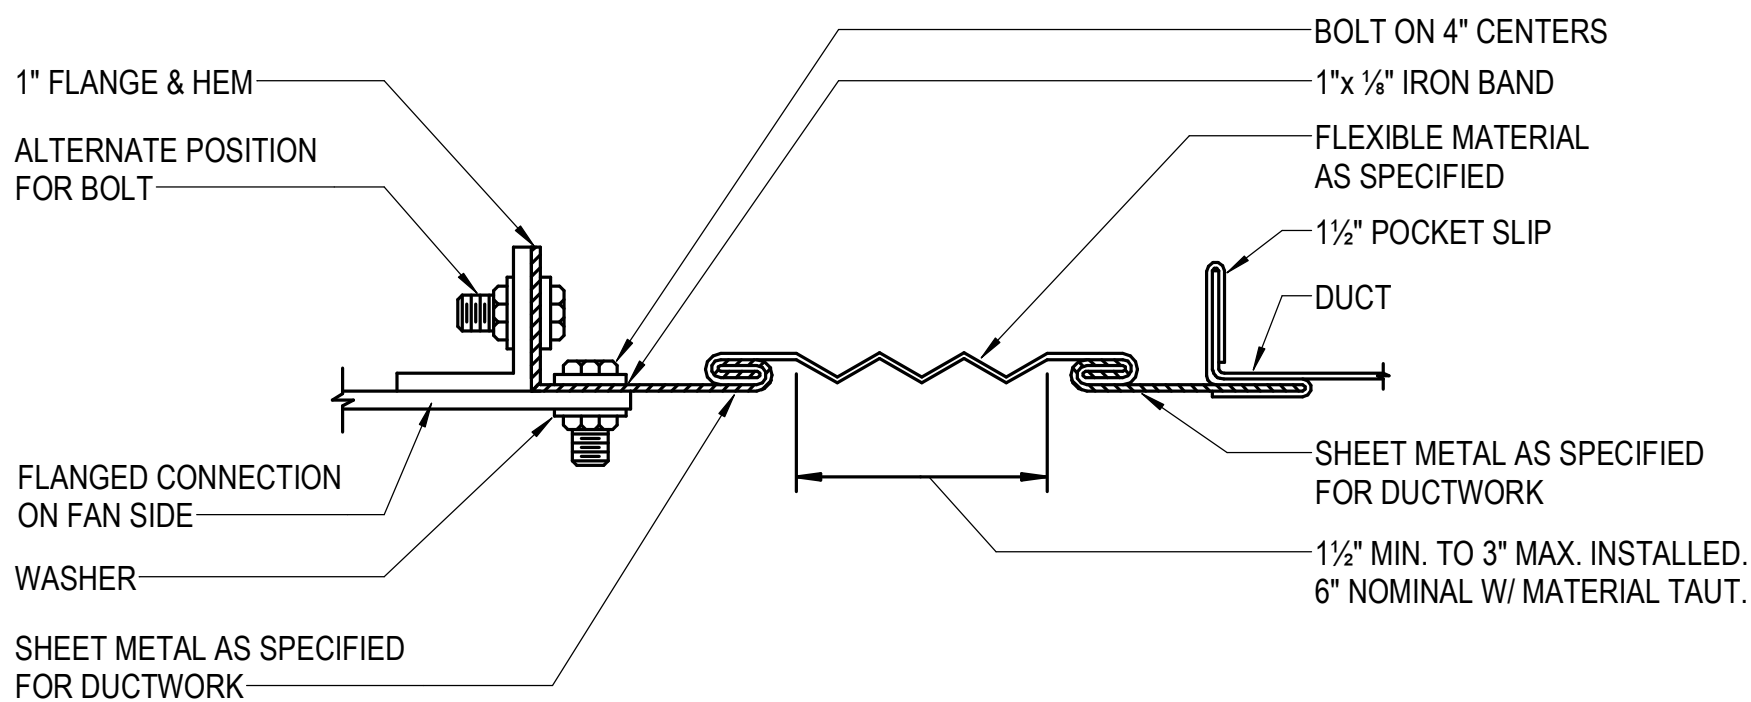

2 FLEXIBLE CONNECTION RECTANGULAR
NOT TO SCALE


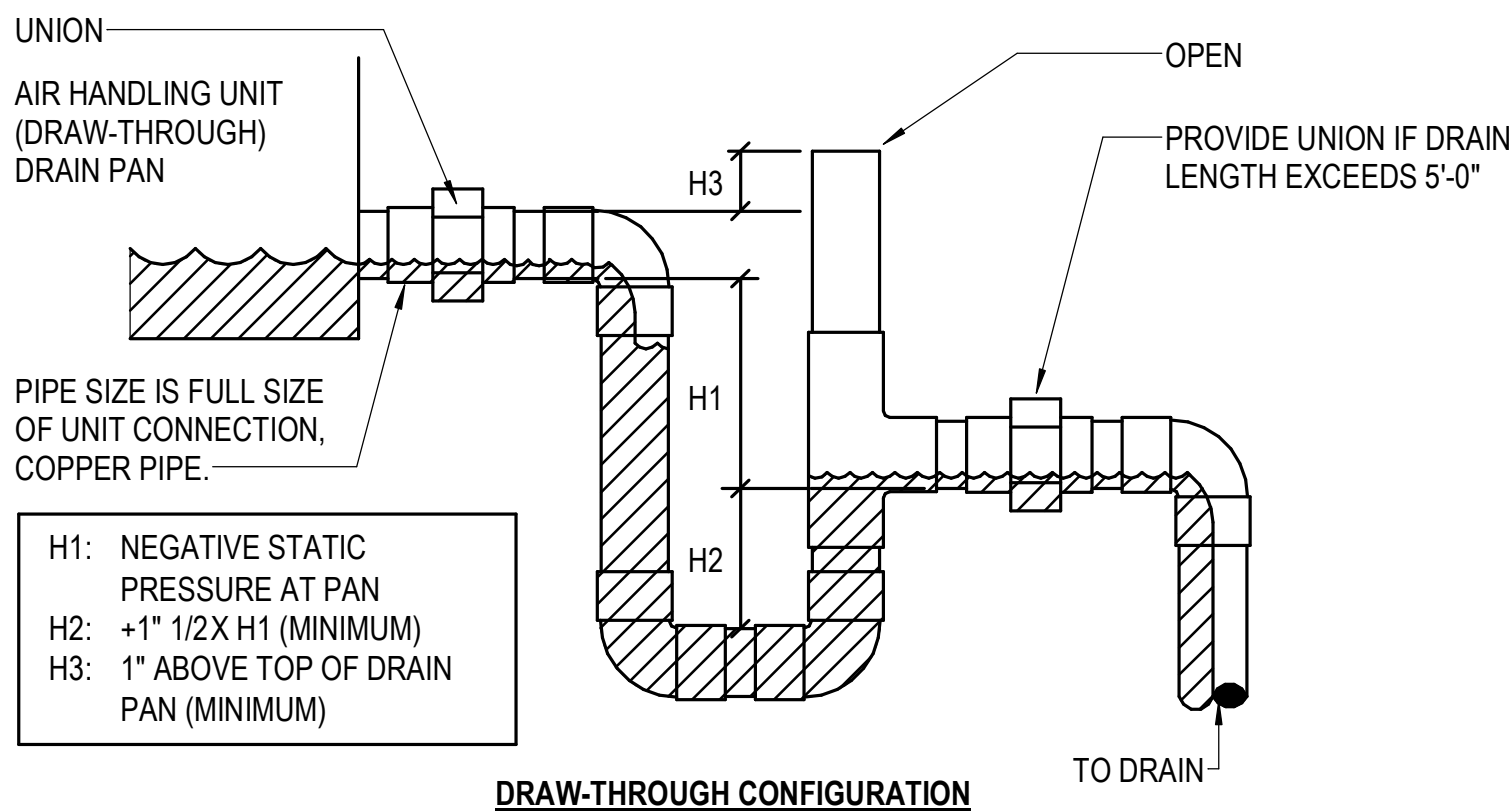


3 CONDENSATE PIPING - DRAIN TRAP - DRAW THROUGH
1/8" = 1'-0" 0 8 16 32

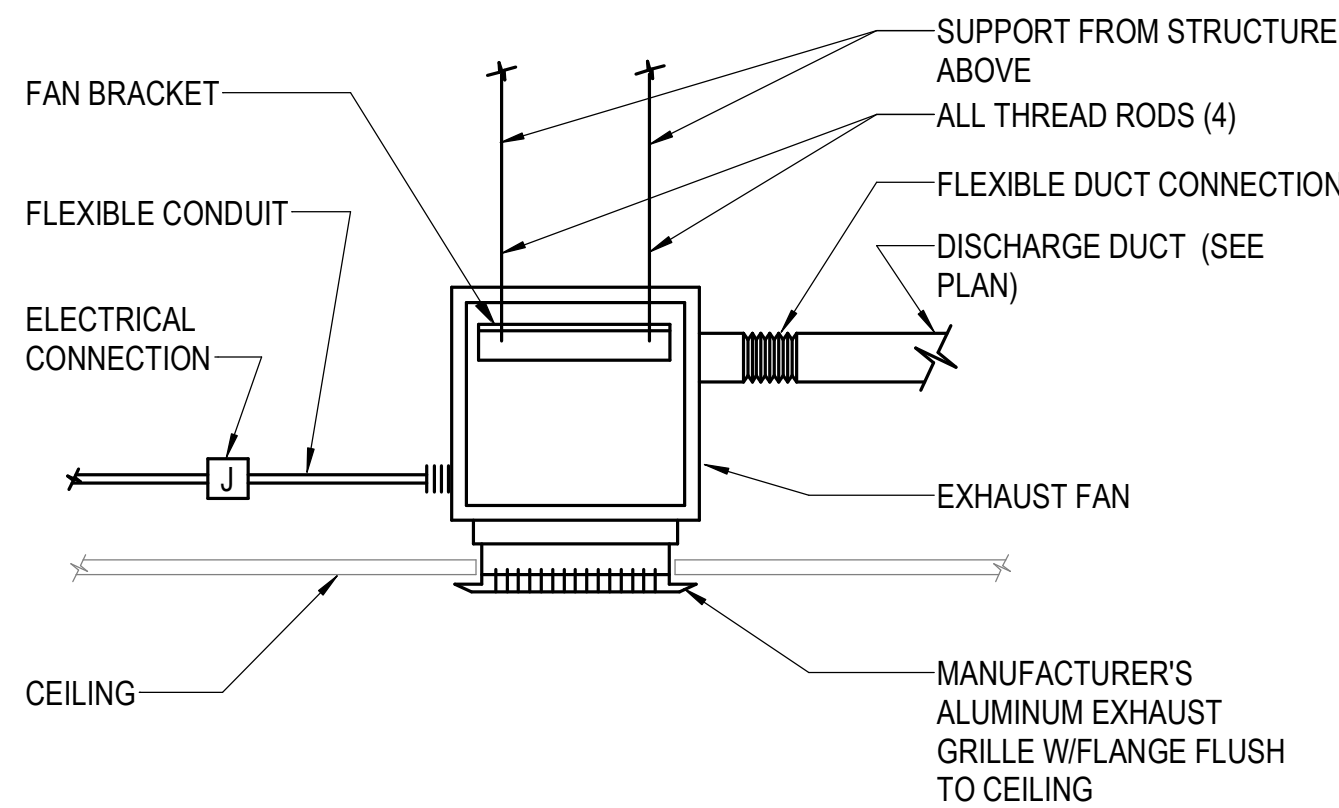

4 CEILING MOUNTED EXHAUST FAN
NOT TO SCALE

- NOTES:
- PROVIDE SUPPORT AT 12' O.C. MAX.
 - ANCHOR ANGLE IRON SUPPORTS TO WALL AT 12" O.C. SPACING MAX.
 - ALL BRACE-TO-DUCT FASTENERS SHALL BE EQUALLY SPACED AT 8" O.C.

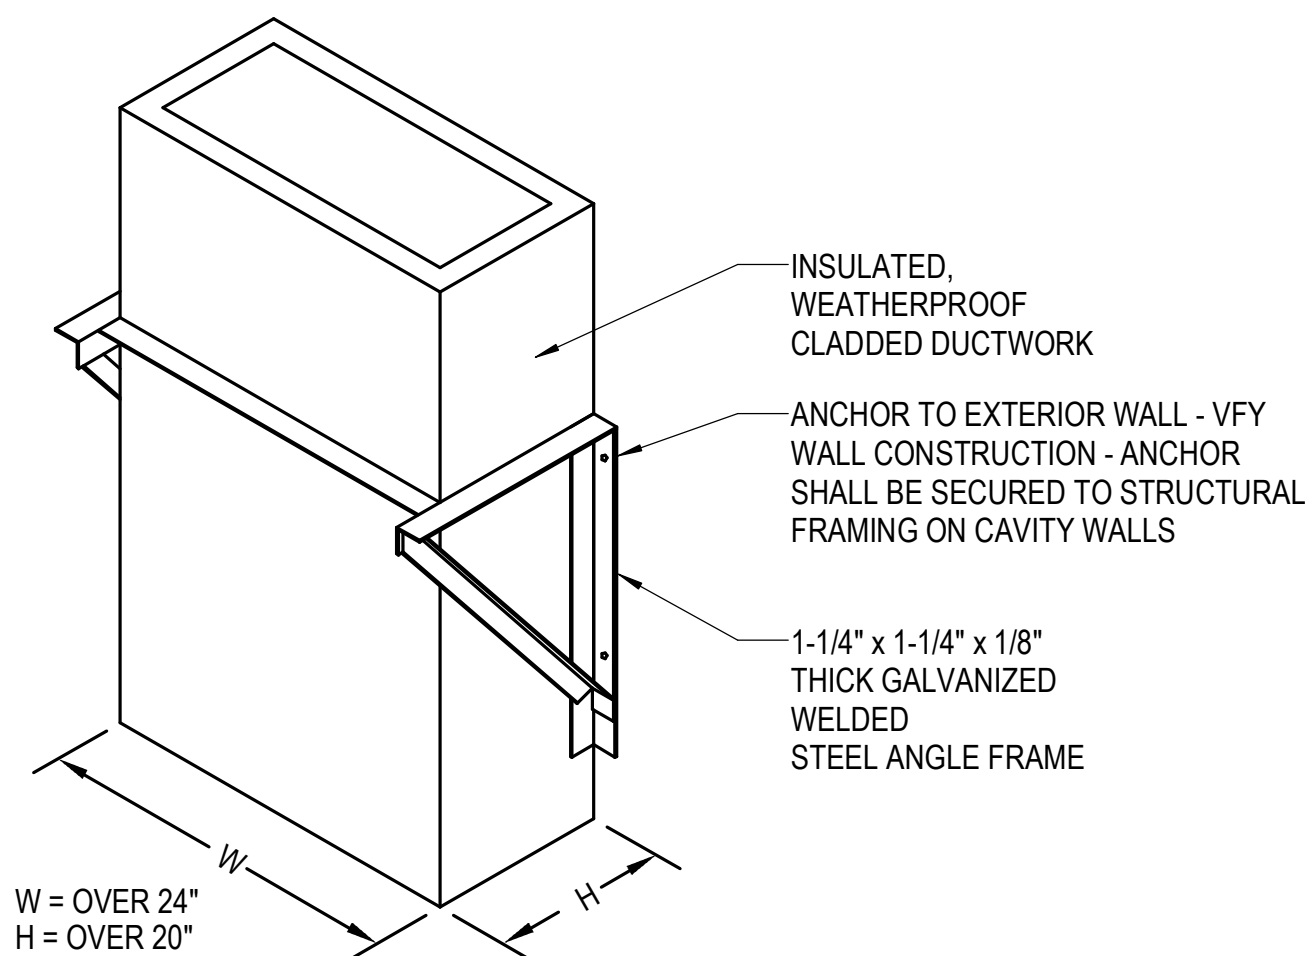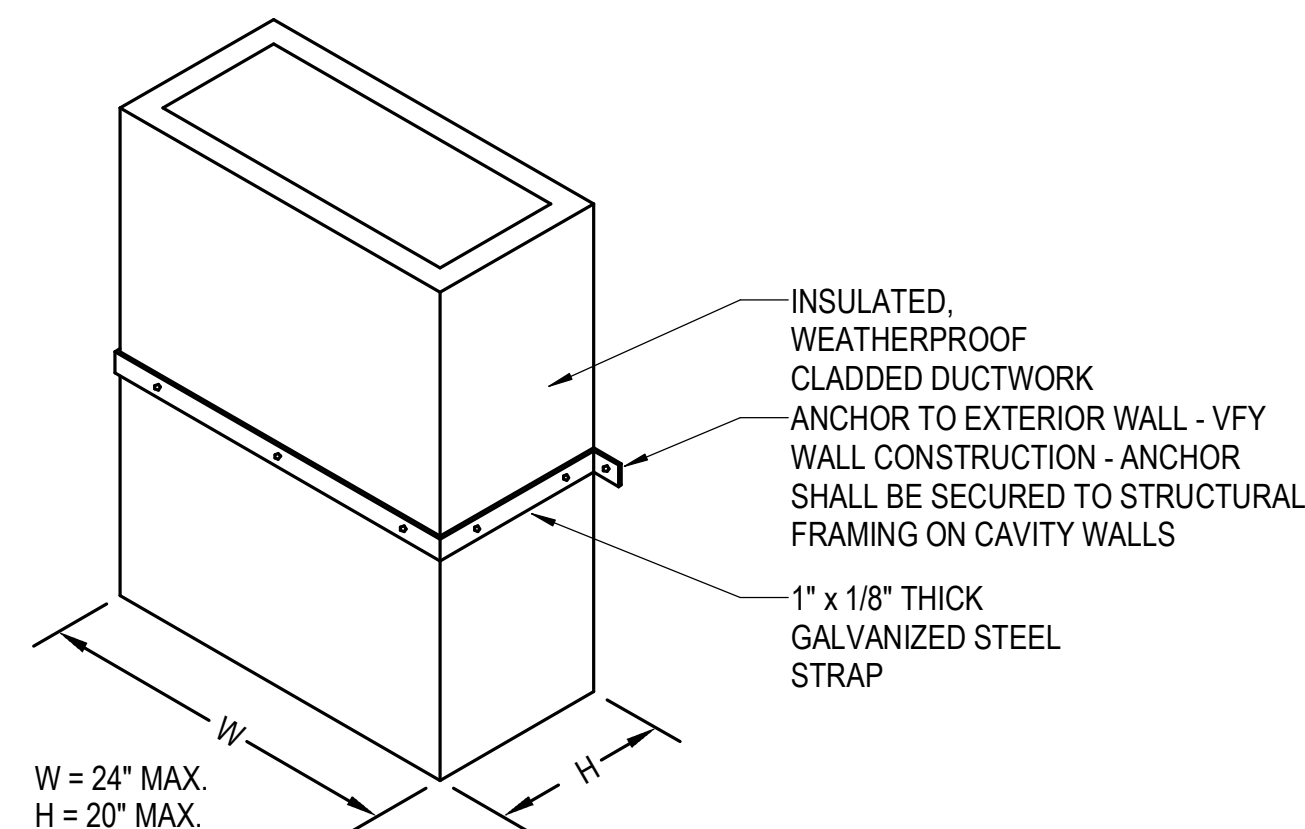

5 EXTERIOR VERTICAL RECTANGULAR DUCT SUPPORT
NOT TO SCALE