




SITE PLAN

SIEMEN'S POWER
EXPANSION

HEBER SPRINGS, CLEBURNE COUNTY,
ARKANSAS

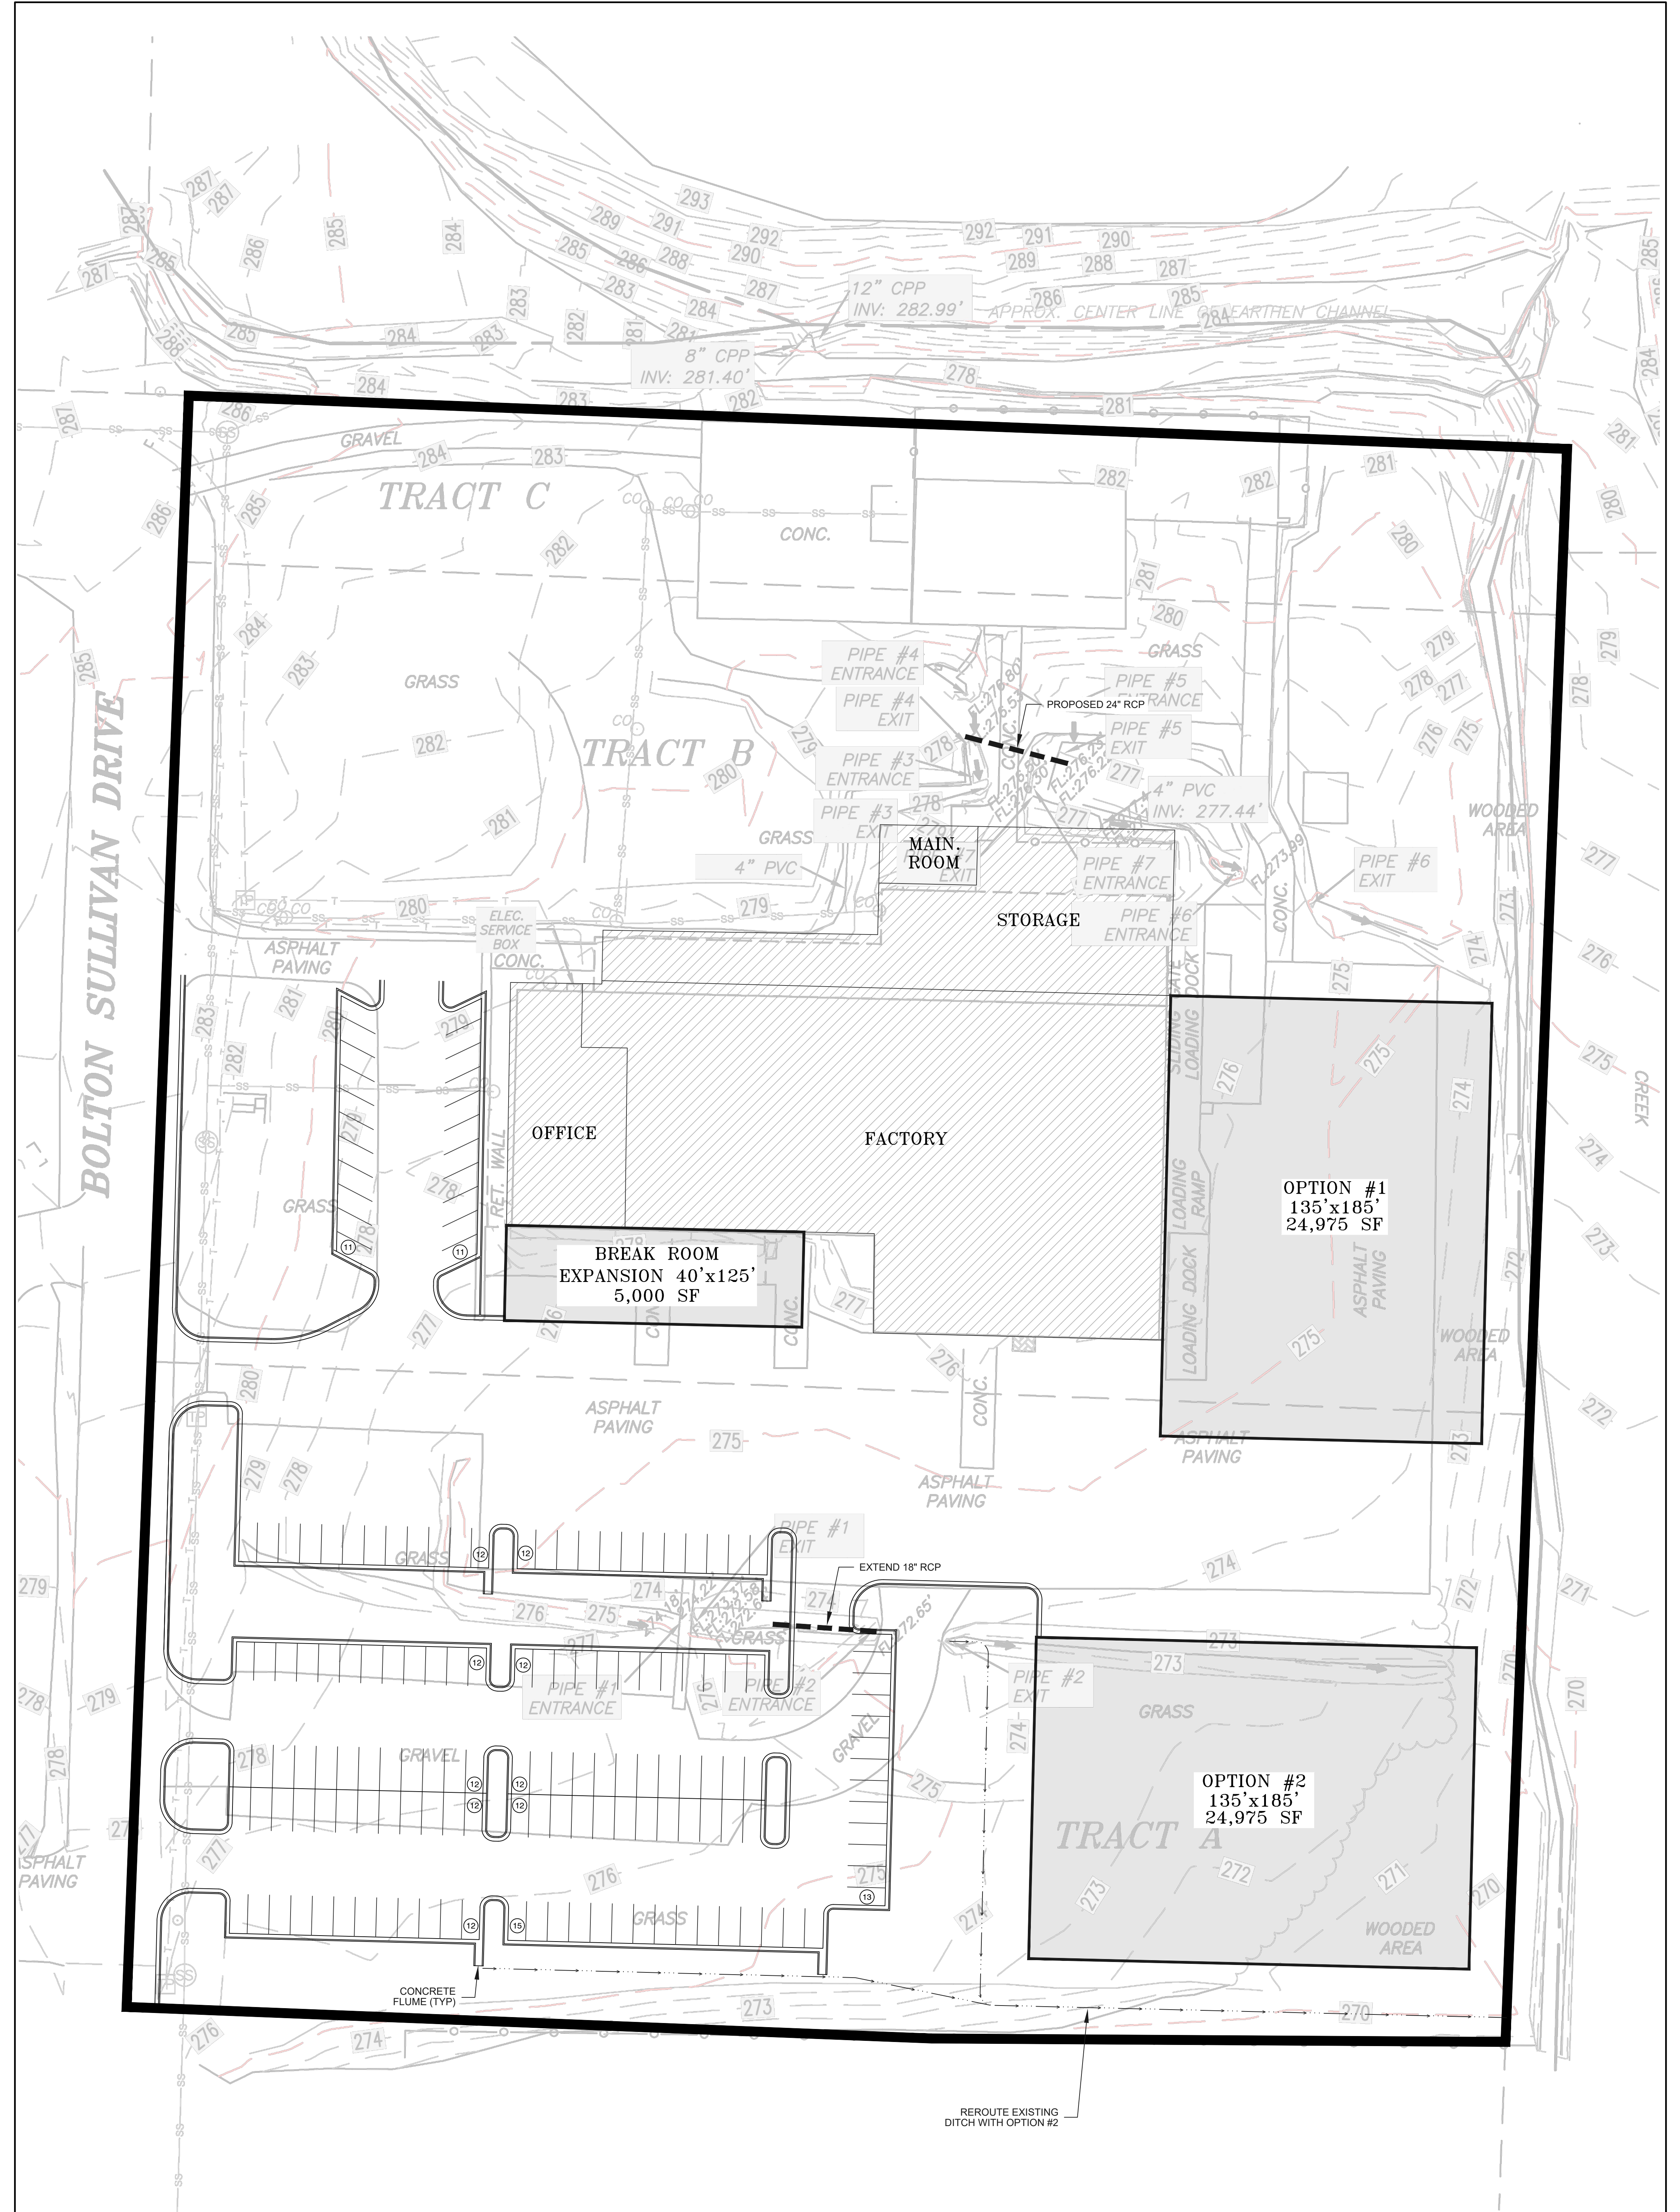


JOE WHITE & ASSOCIATES, INC.
CIVIL ENGINEERING - CONSULTING SERVICES - LAND SURVEYING
25 RAHLING CIRCLE, SUITE A-2 LITTLE ROCK, ARKANSAS 72223
PHONE: (501) 214-9141

DATE: JUNE 26, 2026

SCALE: 1" = 30'

PROJECT NUMBER: 26-279B

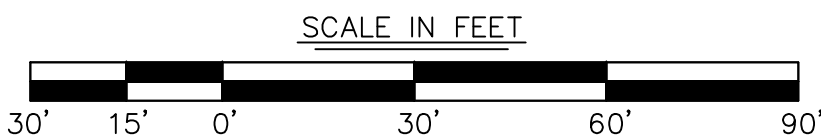

CERTIFICATE OF AUTHORIZATION		
	DATE	DESCRIPTION
	DATE	DESCRIPTION
	DATE	DESCRIPTION
	DATE	DESCRIPTION
REVISION		