

**CEILING PLAN LEGEND**

- ACT-1
- ACT-2
- INTERIOR - GYP. BD. CEILING MOISTURE RESISTANT AT WET LOCATIONS (BATHROOMS)
- 10'-0" INDICATES CEILING HEIGHT
- SEE ELECTRICAL FOR LIGHT FIXTURE TYPES AND QUANTITIES
- 2x2 TROFFER FIXTURE
- 2x2 SURFACE MOUNTED FIXTURE
- DOWNLIGHT CAN FIXTURE
- DOWNLIGHT CAN FIXTURE (SURFACE MOUNT)
- SHOWER DOWNLIGHT CAN FIXTURE MOISTURE RESISTANT
- DECORATIVE WALL SCENCE
- DECORATIVE PENDANT
- STAINLESS STEEL FAN

**TAGGART ARCHITECTS**

600 Main Street, Suite 300  
North Little Rock, AR 72114  
Phone: 501-758-7443  
Fax: 501-753-7309  
www.taggarch.com



NORTH LITTLE ROCK

NORTH LITTLE ROCK  
COMMUNITY  
CENTER  
RENOVATIONS


PROJECT NAME



SEAL

REVISIONS

NO.	DESCRIPTION	DATE

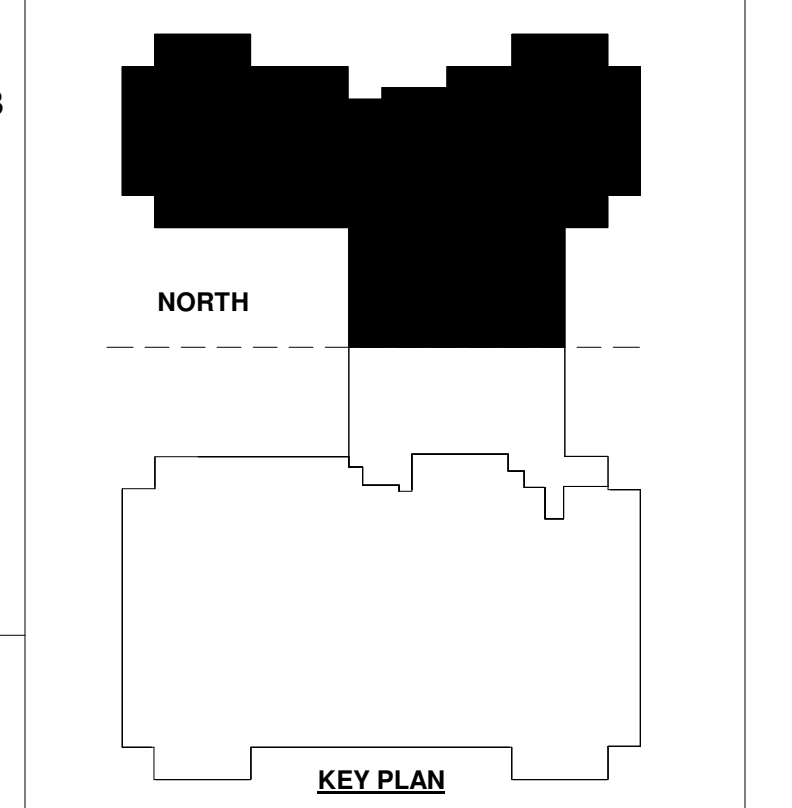


GROUND FLOOR PLAN - CEILING - RENOVATION - NORTH

SHEET NAME  
DATE 05/05/2024

PROJECT NUMBER 161423

SHEET NUMBER **A201**

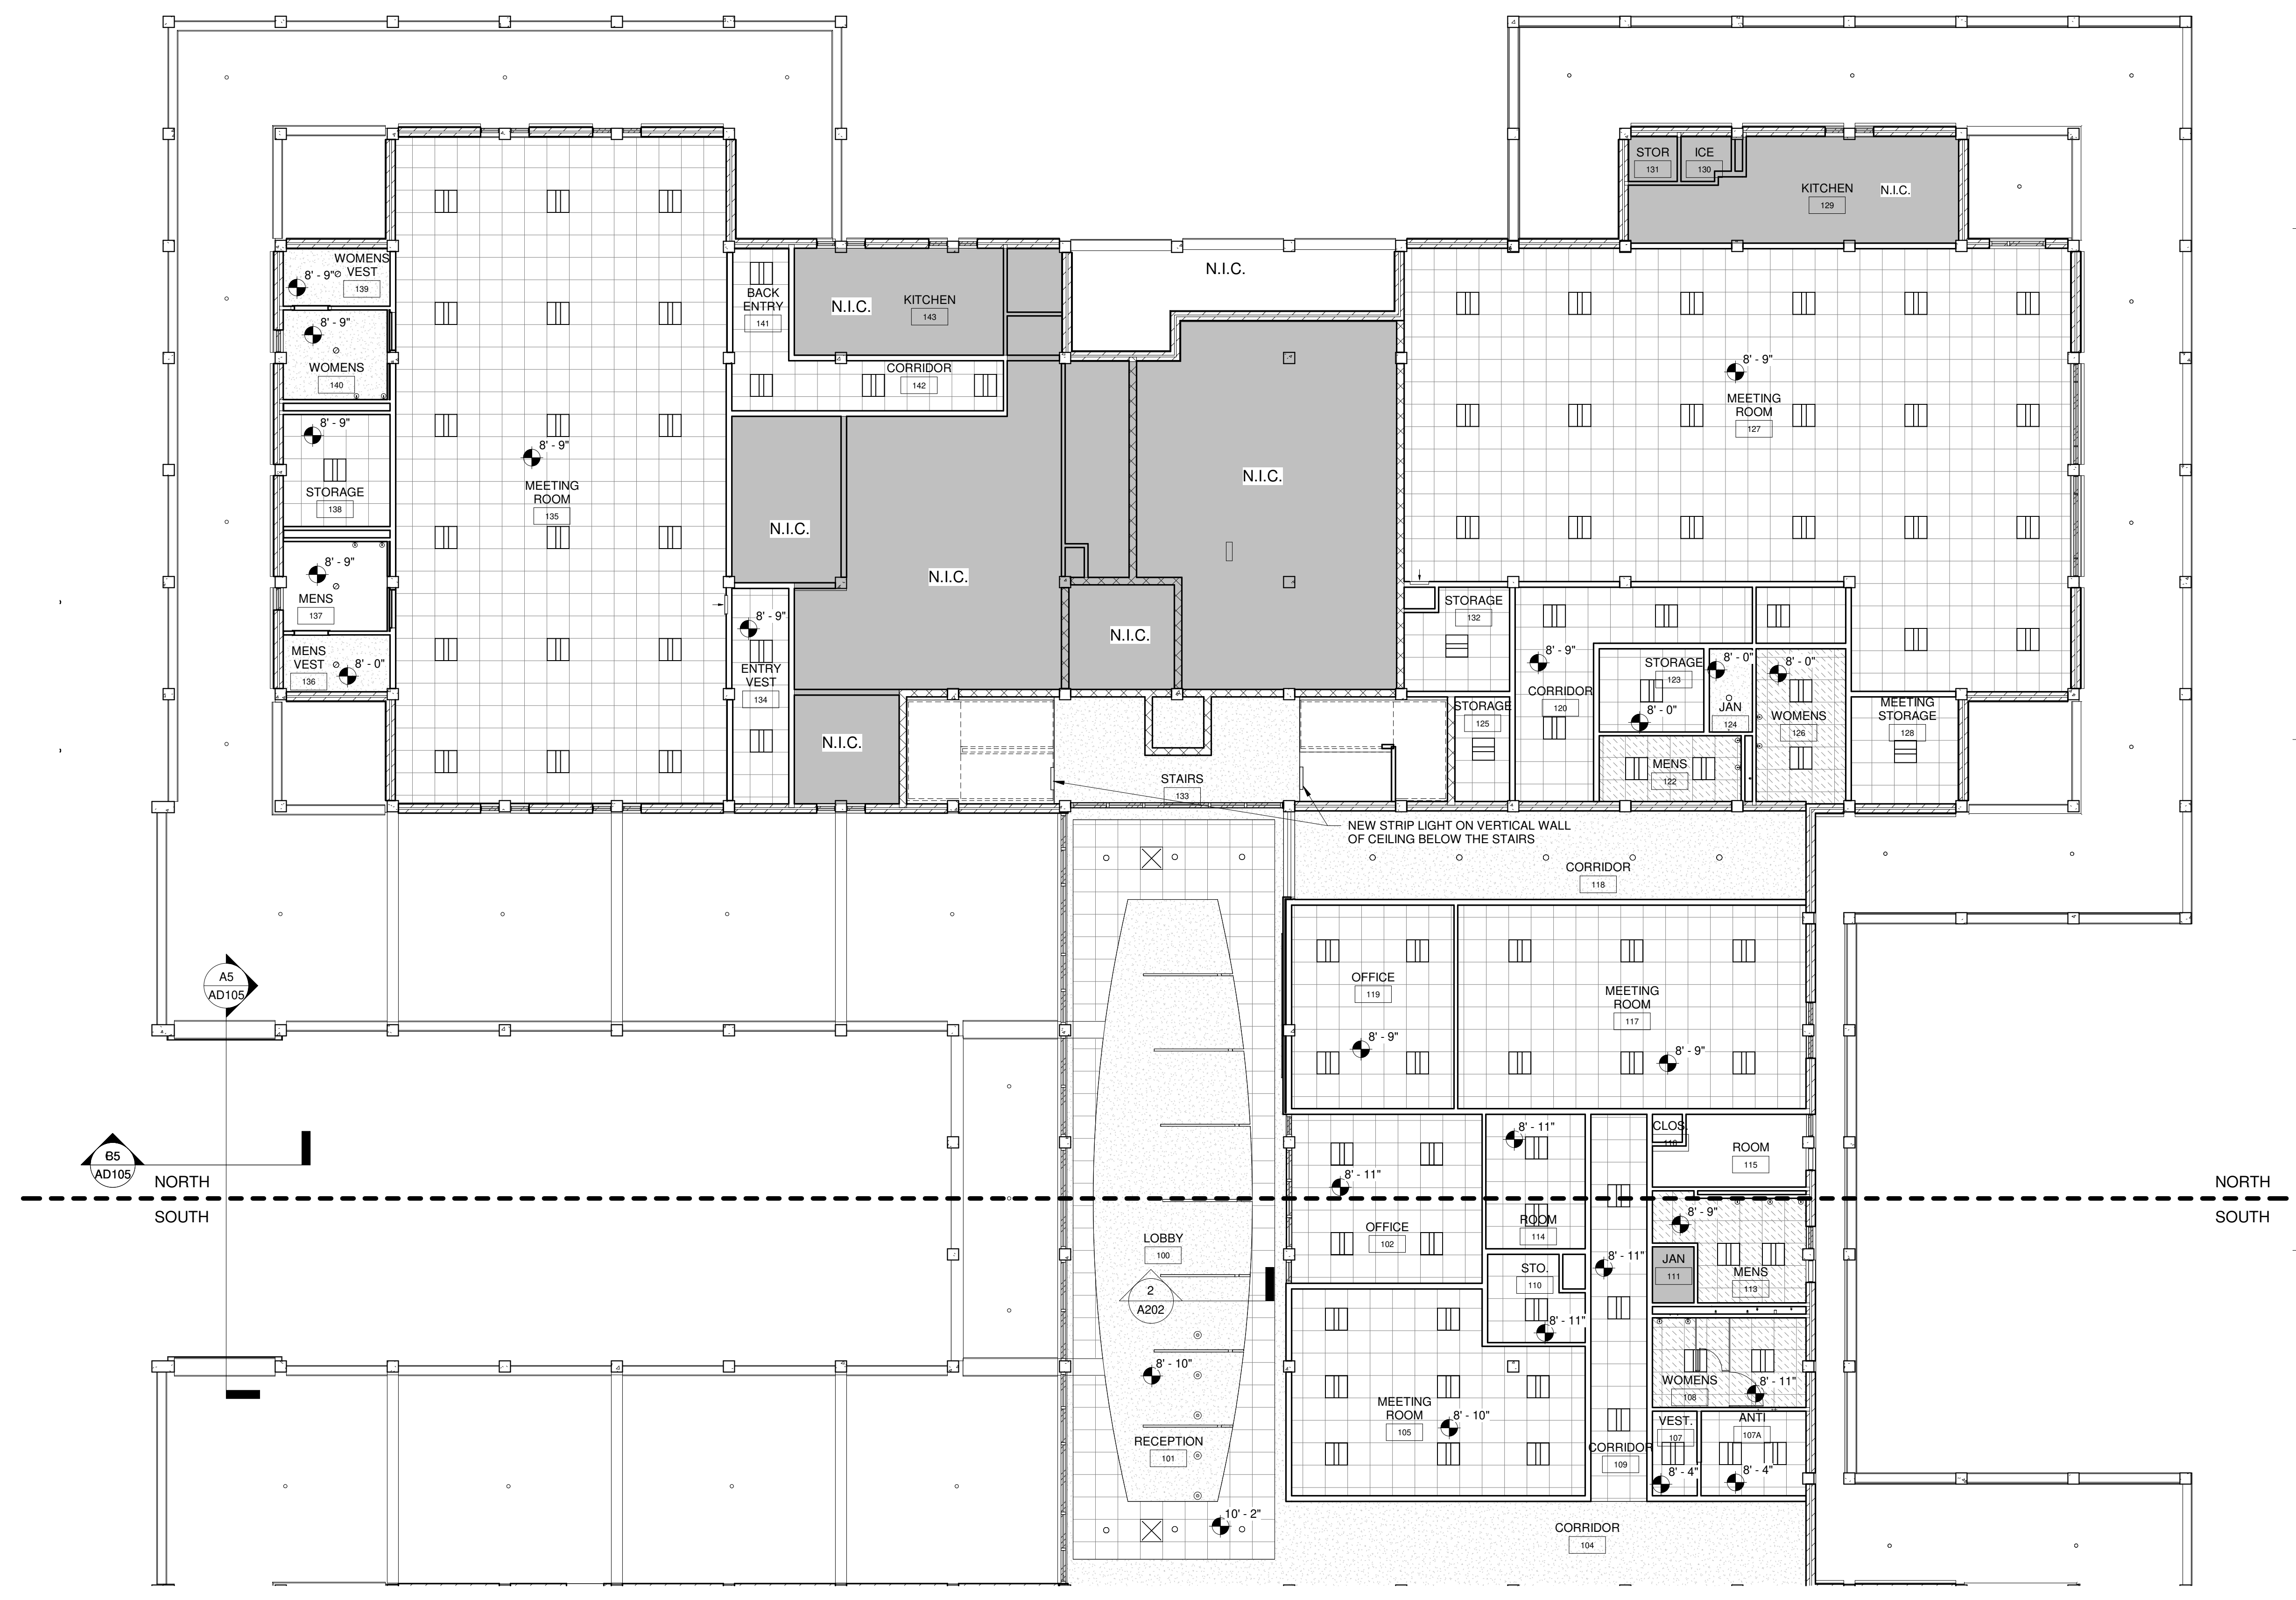

**1** GROUND FLOOR PLAN - CEILING - RENOVATION - NORTH  
1/8" = 1'-0"