

CEILING PLAN LEGEND

- ACT-1
- ACT-2
- INTERIOR - GYP. BD. CEILING MOISTURE RESISTANT AT WET LOCATIONS (BATHROOMS)
- 10'-0"
- SEE ELECTRICAL FOR LIGHT FIXTURE TYPES AND QUANTITIES
- 2x2 TROFFER FIXTURE
- 2x2 SURFACE MOUNTED FIXTURE
- DOWNLIGHT CAN FIXTURE
- DOWNLIGHT CAN FIXTURE (SURFACE MOUNT)
- SHOWER DOWNLIGHT CAN FIXTURE MOISTURE RESISTANT
- DECORATIVE WALL SCONCE
- DECORATIVE PENDANT
- STAINLESS STEEL FAN

TAGGART ARCHITECTS

600 Main Street, Suite 300
 North Little Rock, AR 72114
 Phone: 501-758-7443
 Fax: 501-753-7309
 www.taggarch.com



NORTH LITTLE ROCK

NORTH LITTLE ROCK COMMUNITY CENTER RENOVATIONS


PROJECT NAME



SEAL

REVISIONS

NO.	DESCRIPTION	DATE

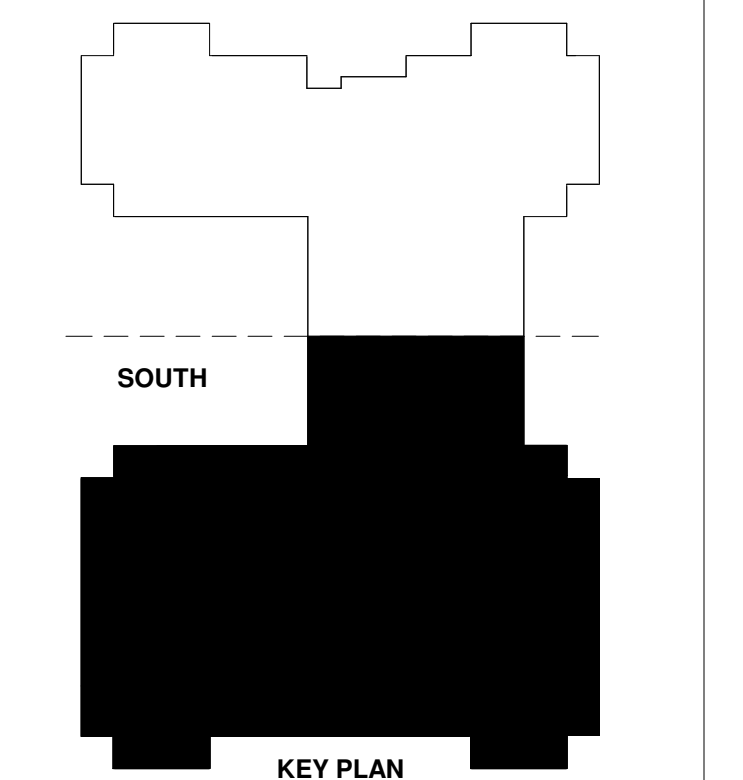

SECOND FLOOR PLAN - CEILING - RENOVATION - SOUTH

SHEET NAME

DATE 05/05/2024

PROJECT NUMBER 161423

SHEET NUMBER

A204

1 SECOND FLOOR PLAN - CEILING - RENOVATION - SOUTH
 1/8" = 1'-0"