

6
GENERAL NOTES

1. CONNECT NEW AIR DEVICES TO EXISTING BRANCH DUCTWORK. PROVIDE SQUARE TO ROUND TRANSITIONS AS REQUIRED. ENSURE FINAL CONNECTIONS PROVIDE A SMOOTH TRANSITION.
2. COORDINATE ALL NEW CEILING DEVICES WITH NEW LIGHTS AND CEILING GRID.

TAGGART
ARCHITECTS

600 Main Street, Suite 300
North Little Rock, AR 72114
Phone: 501-758-7443
Fax: 501-753-7309
www.taggarch.com



NORTH LITTLE ROCK


NORTH LITTLE ROCK
COMMUNITY
CENTER
RENOVATIONS

PROJECT NAME _____

SEAL _____

REVISIONS

NO.	DESCRIPTION	DATE

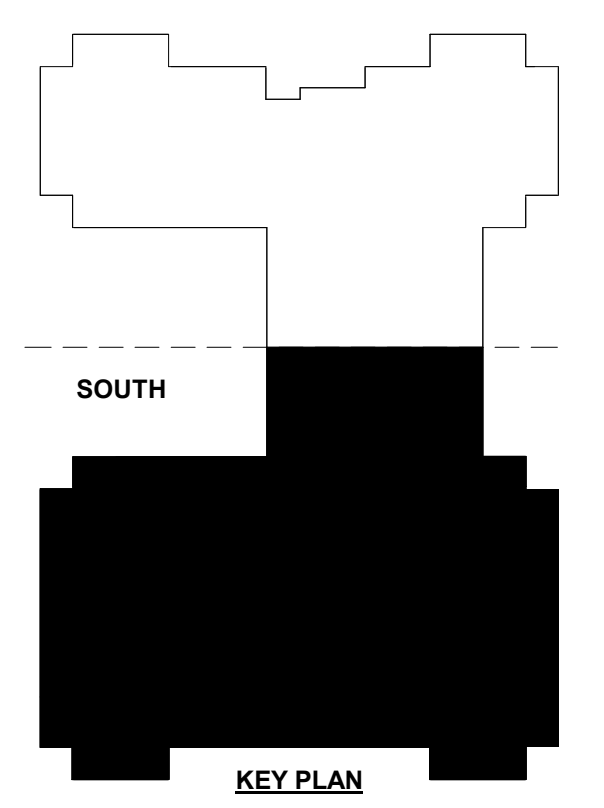


GROUND FLOOR PLAN -
SOUTH - HVAC

SHEET NAME _____

DATE 5/05/2024

PROJECT NUMBER 161423

SHEET NUMBER **M202**

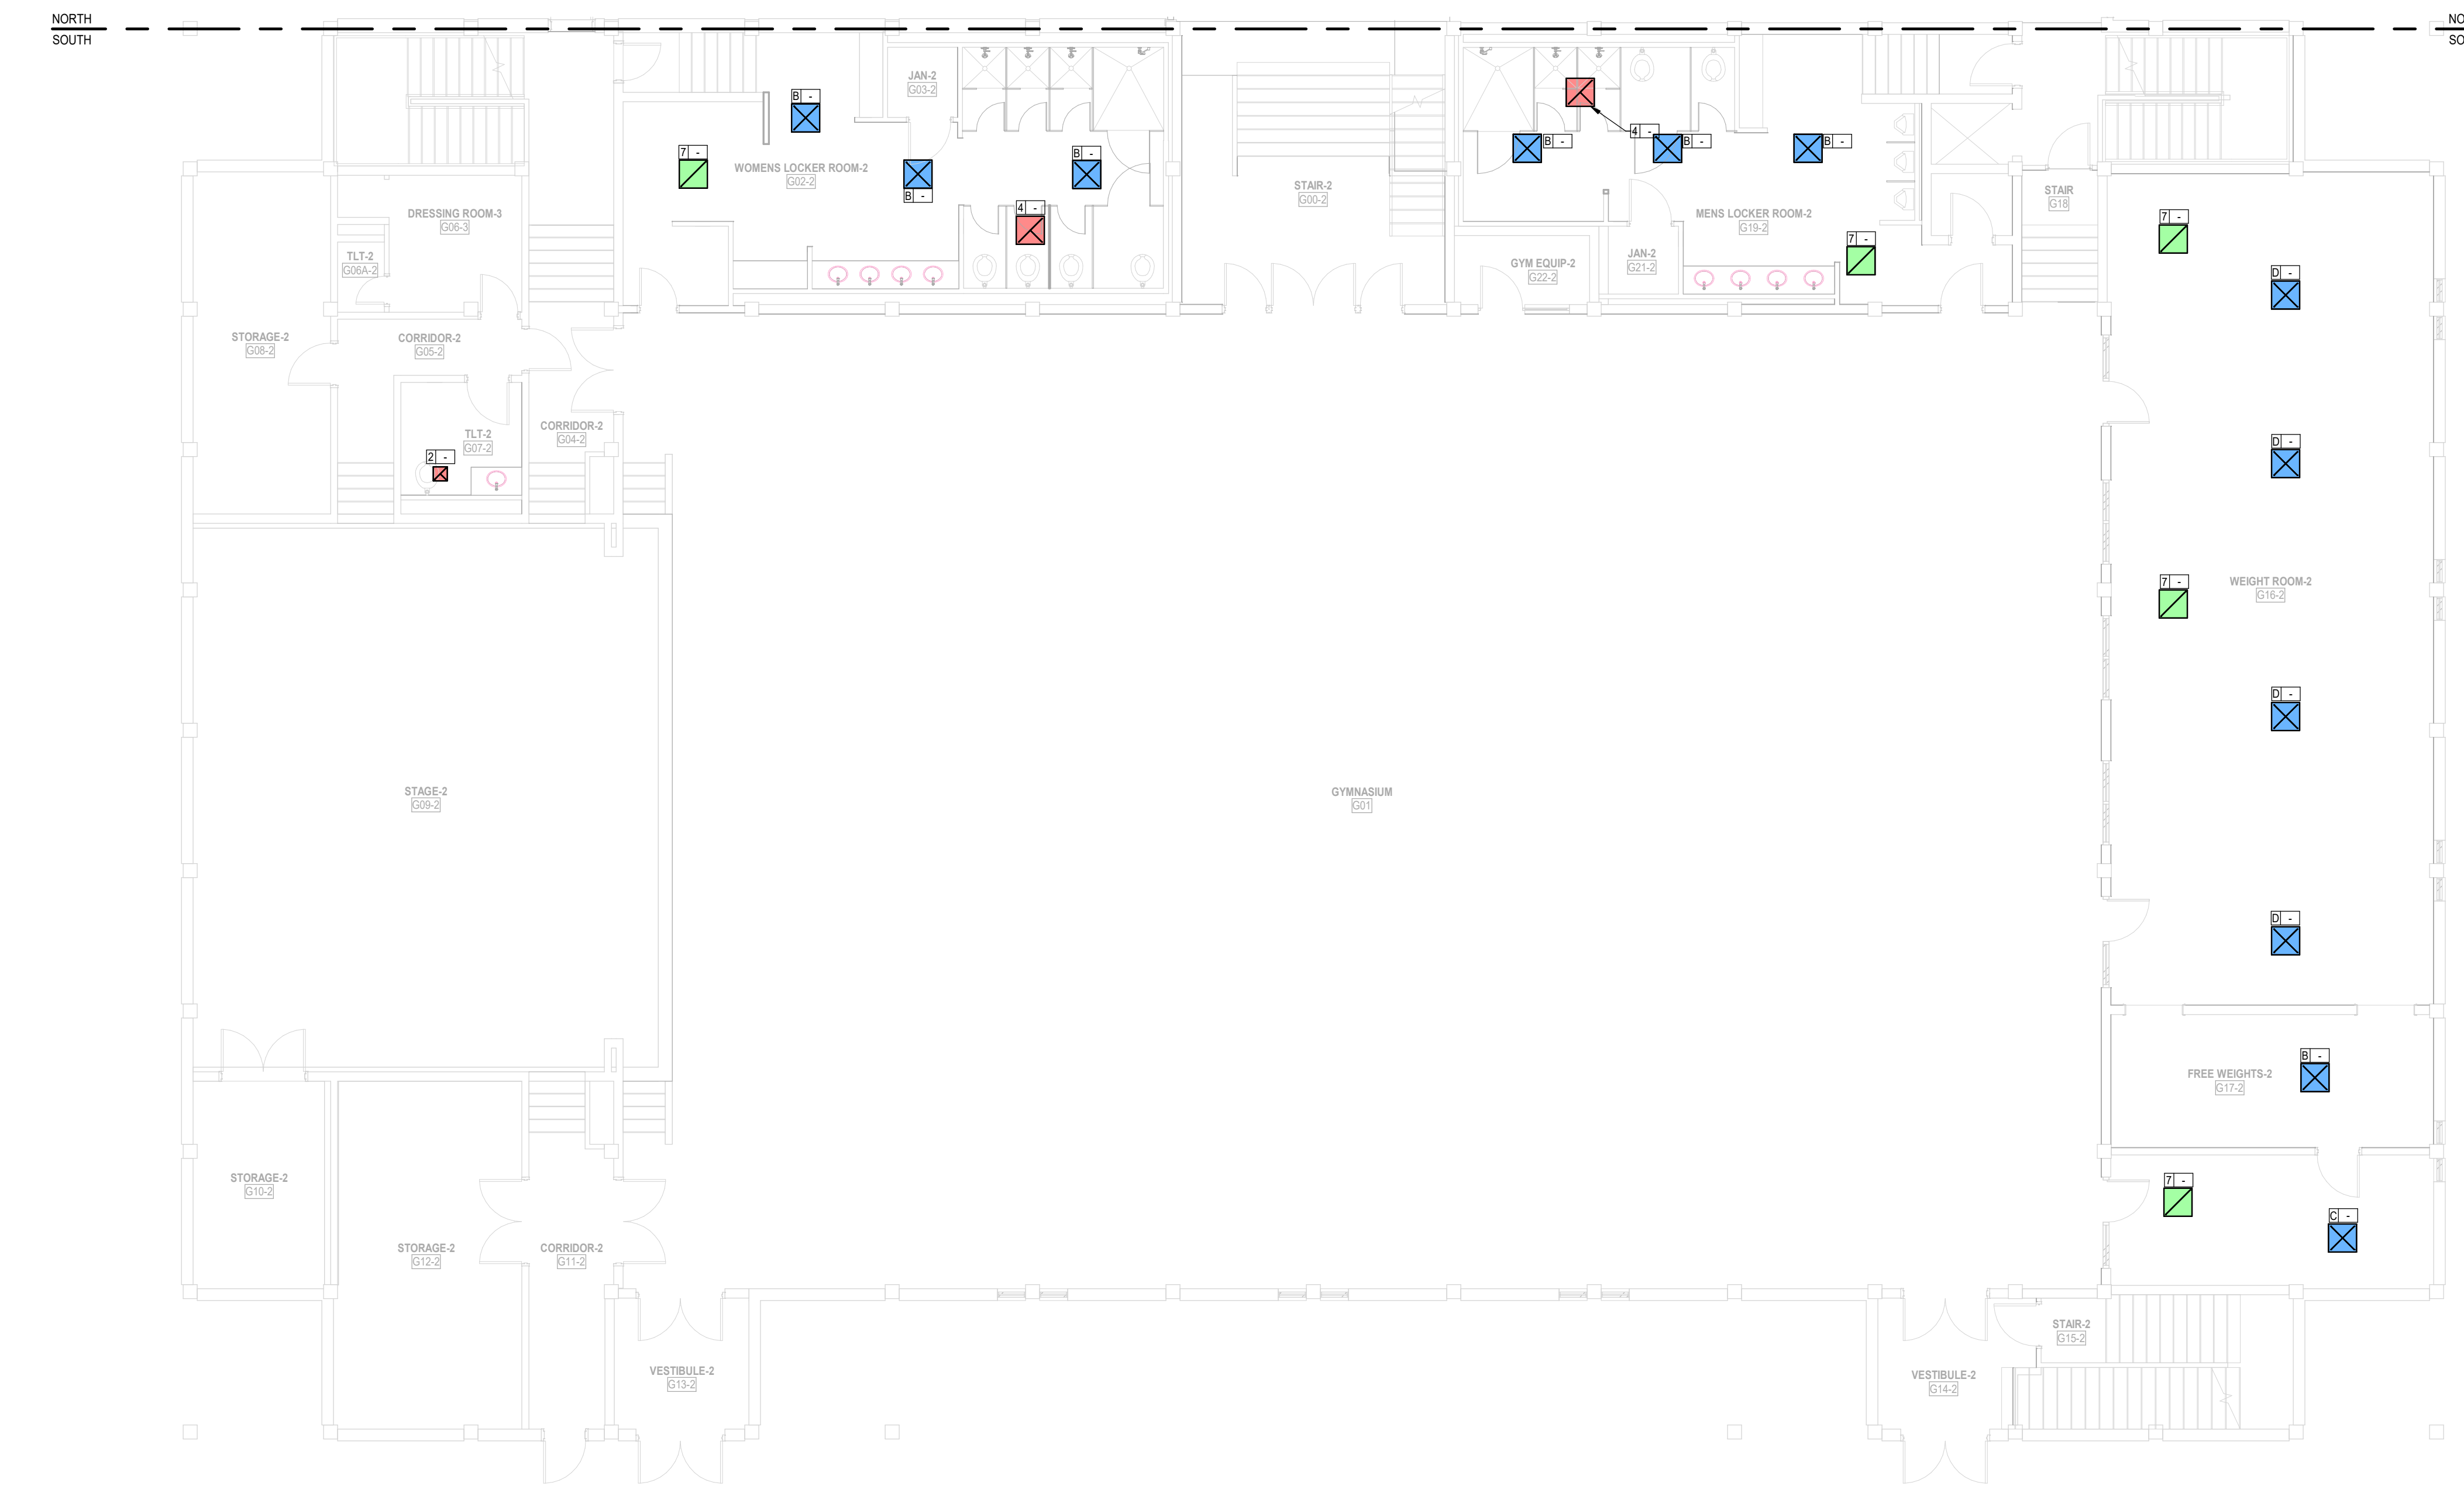

1 GROUND FLOOR PLAN - SOUTH - HVAC
1/8" = 1'-0"

