

DEMOLITION GENERAL NOTES

- 1. DEMOLISH ALL EXISTING AIR DEVICES INDICATED. RETAIN EXISTING BRANCH DUCT FOR CONNECTION TO NEW AIR DEVICE.

TAGGART
ARCHITECTS

600 Main Street, Suite 300
North Little Rock, AR 72114
Phone: 501-758-7443
Fax: 501-753-7309
www.taggarch.com



NORTH LITTLE ROCK


NORTH LITTLE ROCK
COMMUNITY
CENTER
RENOVATIONS

PROJECT NAME _____

SEAL _____

REVISIONS _____

NO.	DESCRIPTION	DATE

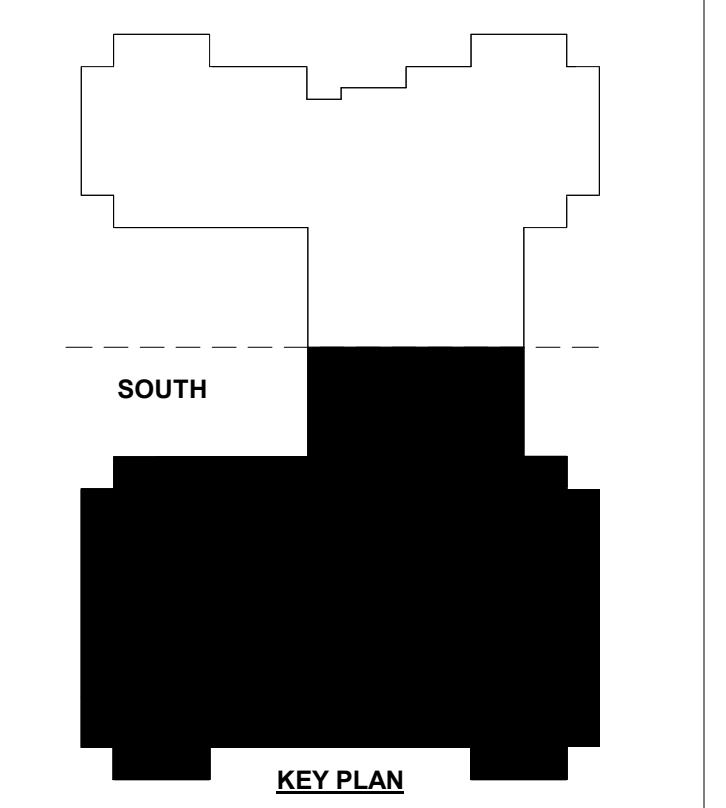

GROUND FLOOR PLAN - SOUTH - HVAC DEMOLITION

SHEET NAME _____
DATE 5/05/2024

PROJECT NUMBER 161423

SHEET NUMBER **MD102**

1 GROUND FLOOR PLAN - SOUTH - HVAC DEMOLITION
1/8" = 1'-0"

