



DEMOLITION KEYED NOTES

- ① REMOVE EXISTING PLUMBING FIXTURE AND REWORK ROUGH-IN
- ② REMOVE EXISTING PLUMBING FIXTURE
- ③ REMOVE EXISTING WATER CLOSET AND STORE IN PROTECTED LOCATION FOR REINSTALLATION AFTER NEW FLOORING IS INSTALLED

NORTH LITTLE ROCK


NORTH LITTLE ROCK
COMMUNITY
CENTER
RENOVATIONS

PROJECT NAME _____

SEAL _____

REVISIONS

NO.	DESCRIPTION	DATE

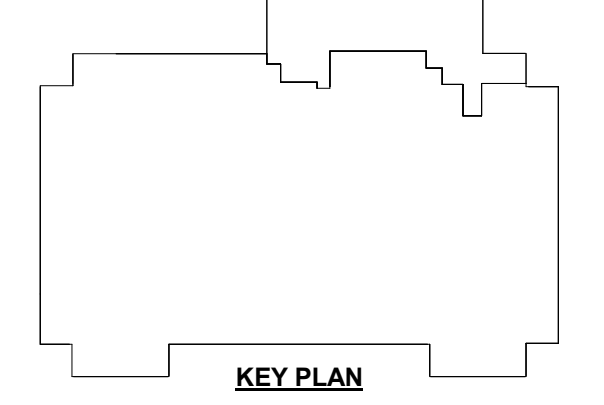

GROUND FLOOR PLAN - NORTH - PLUMBING DEMOLITION

SHEET NAME _____

DATE 5/05/2024

PROJECT NUMBER 161423

SHEET NUMBER **PD101**



1 GROUND FLOOR PLAN - NORTH - PLUMBING DEMOLITION
1/8" = 1'-0"

