



DEMOLITION KEYED NOTES	
①	REMOVE EXISTING PLUMBING FIXTURE AND REWORK ROUGH-IN
②	REMOVE EXISTING PLUMBING FIXTURE
③	REMOVE EXISTING WATER CLOSET AND STORE IN PROTECTED LOCATION FOR REINSTALLATION AFTER NEW FLOORING IS INSTALLED


NORTH LITTLE ROCK

NORTH LITTLE ROCK
COMMUNITY
CENTER
RENOVATIONS

PROJECT NAME _____

SEAL _____

REVISIONS		
NO.	DESCRIPTION	DATE

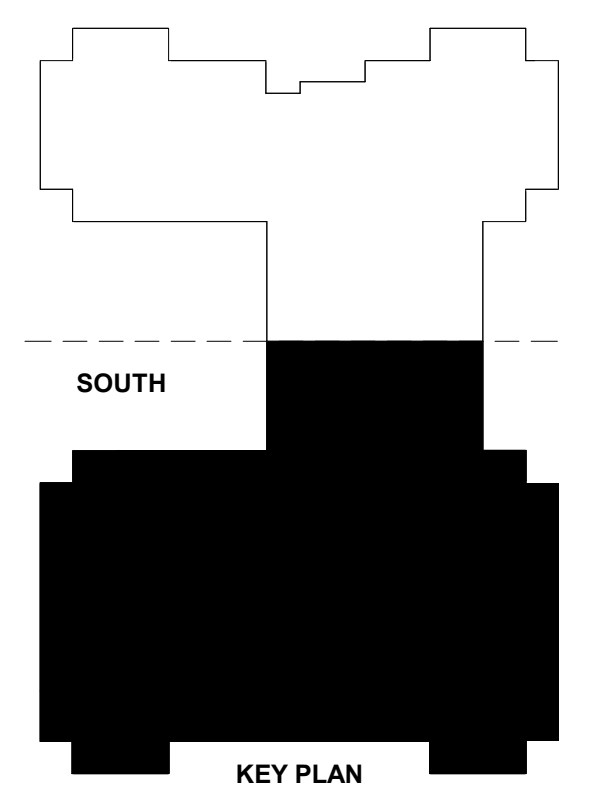


GROUND FLOOR PLAN -
SOUTH - PLUMBING
DEMOLITION

SHEET NAME _____
DATE _____ 5/05/2024

PROJECT NUMBER _____ 161423

SHEET NUMBER **PD102**

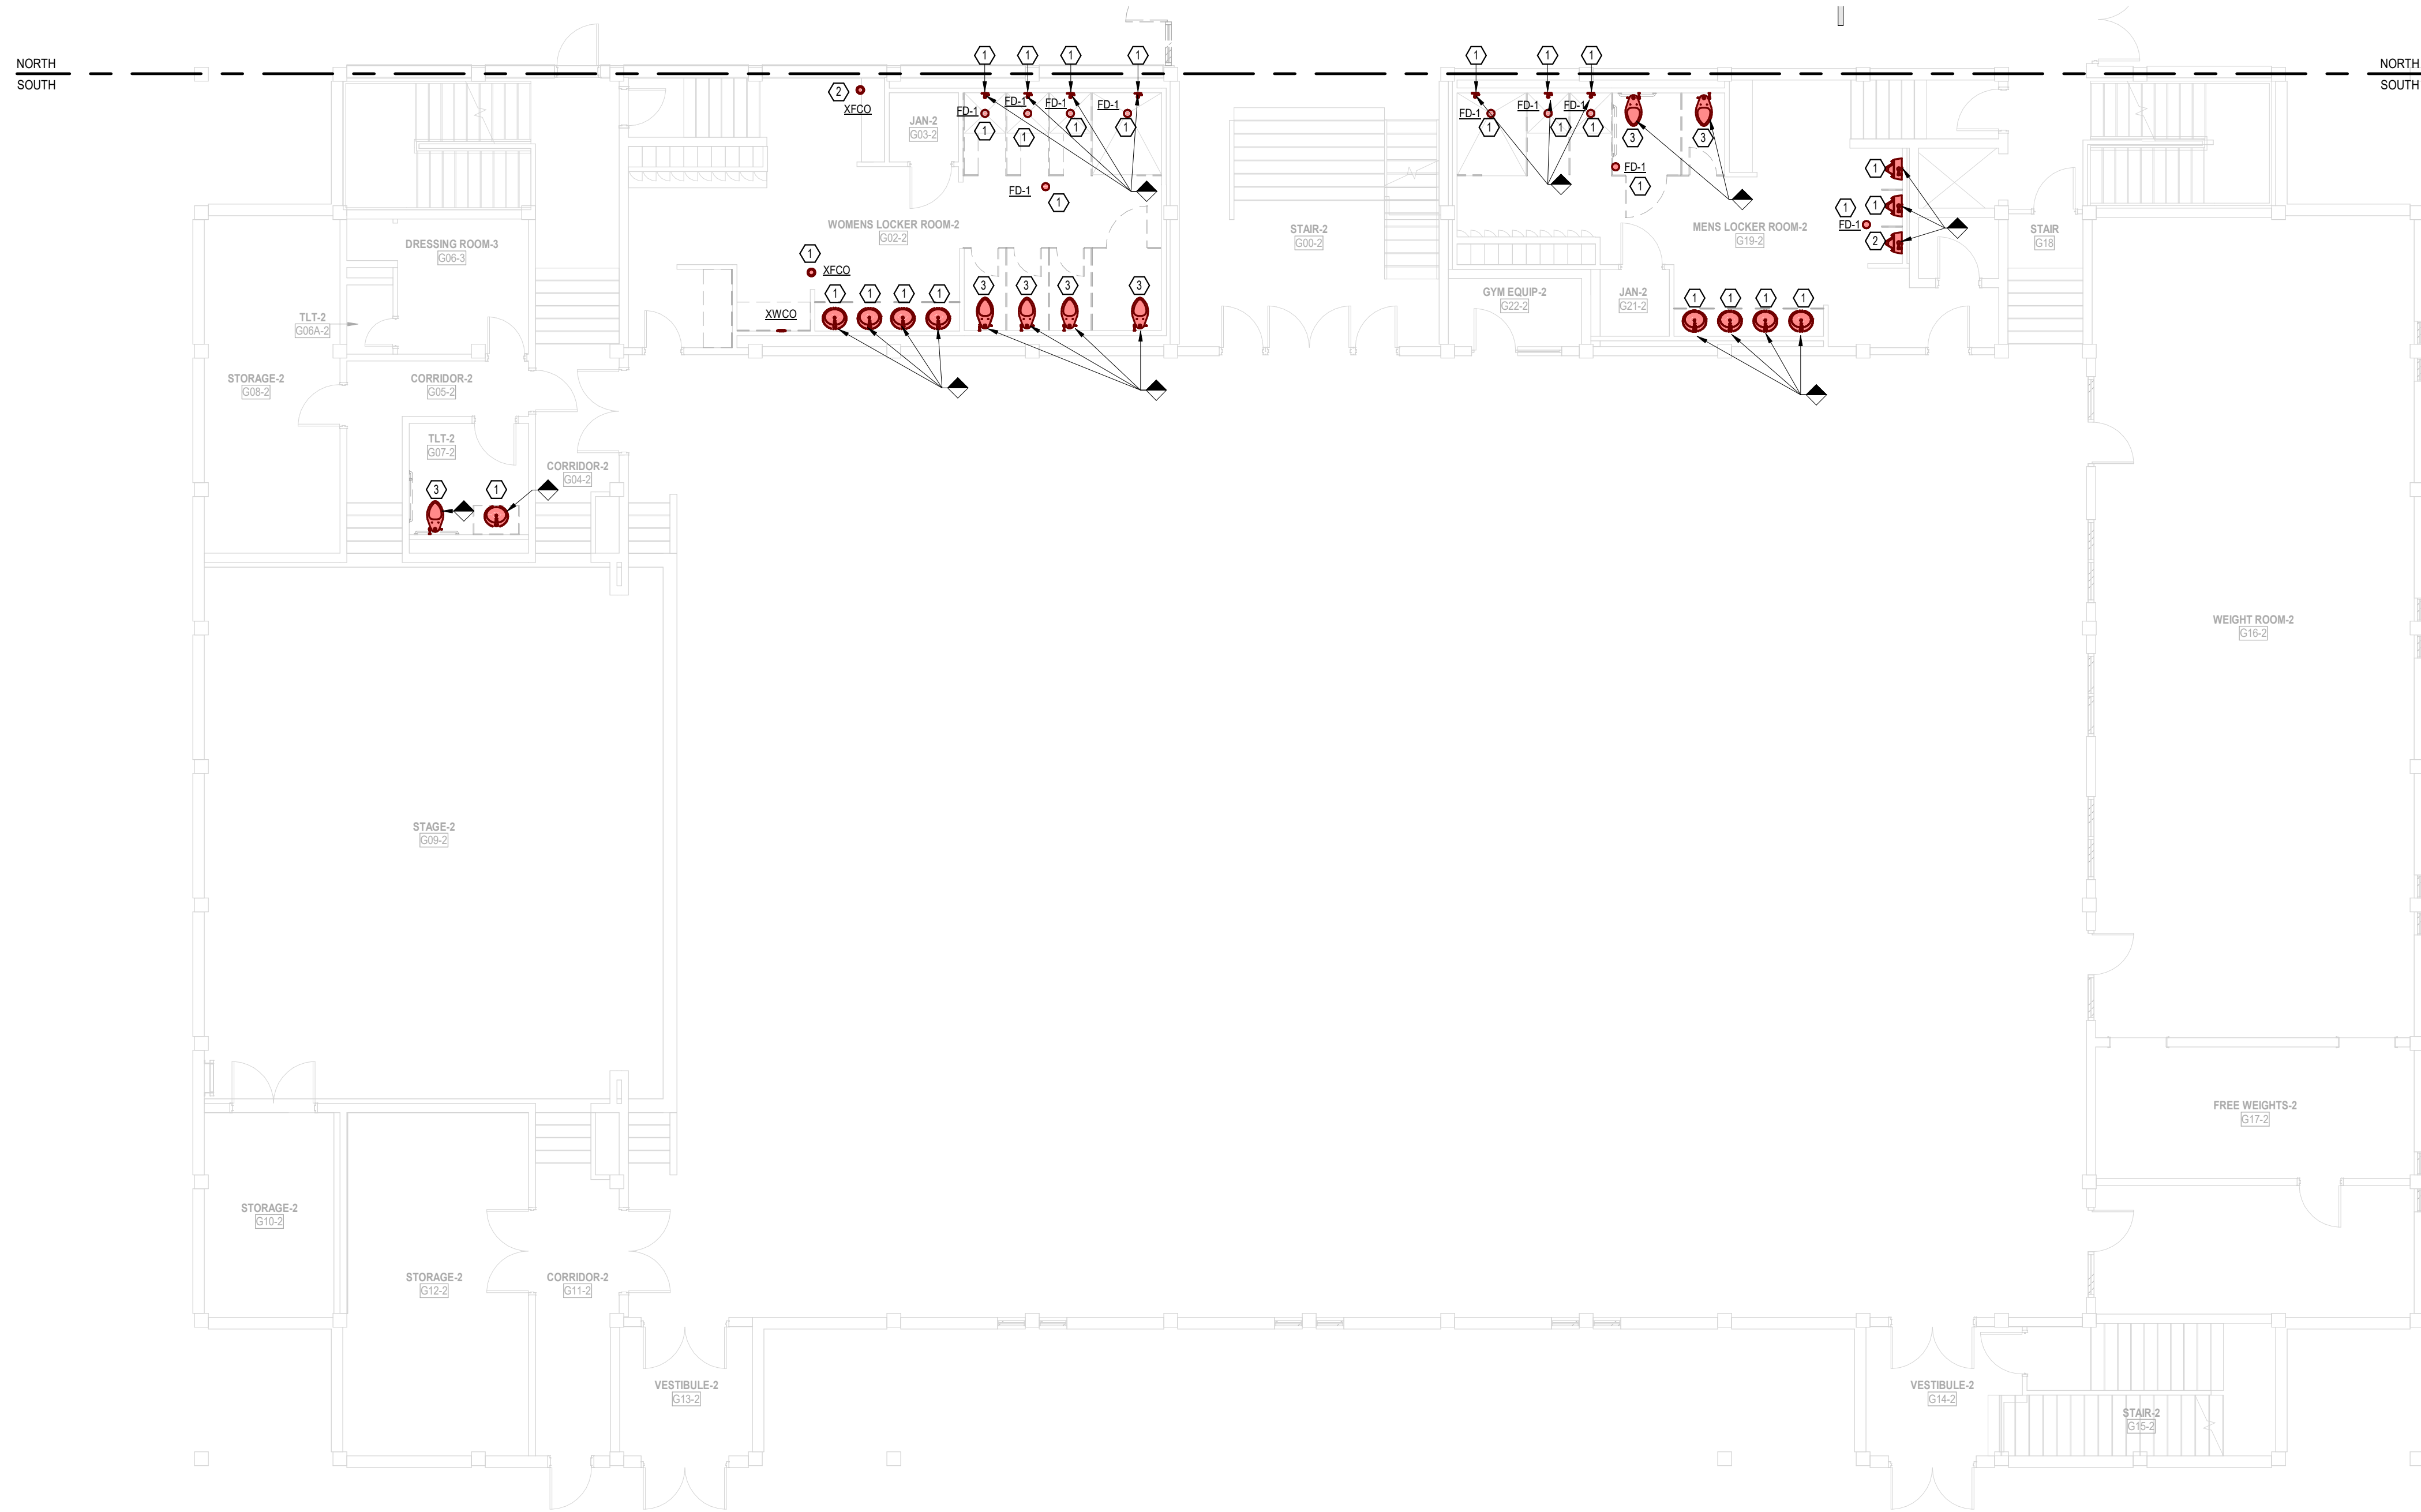

① GROUND FLOOR PLAN - SOUTH - PLUMBING DEMOLITION
1/8" = 1'-0"

