



DEMOLITION KEYED NOTES

① REMOVE EXISTING PLUMBING FIXTURE AND REWORK ROUGH-IN.

② REMOVE EXISTING WATER CLOSET AND STORE IN PROTECTED LOCATION FOR REINSTALLATION AFTER NEW FLOORING IS INSTALLED.



NORTH LITTLE ROCK


NORTH LITTLE ROCK
COMMUNITY
CENTER
RENOVATIONS

PROJECT NAME _____

SEAL _____

REVISIONS

NO.	DESCRIPTION	DATE

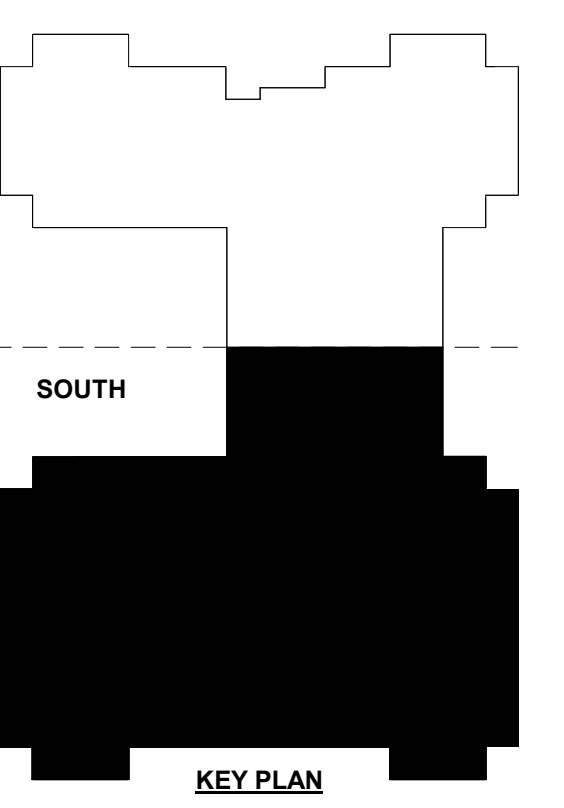


① SECOND FLOOR PLAN - SOUTH - PLUMBING DEMOLITION
1/8" = 1'-0"

SECOND FLOOR PLAN -
SOUTH - PLUMBING
DEMOLITION

SHEET NAME _____
DATE 5/05/2024

PROJECT NUMBER 161423

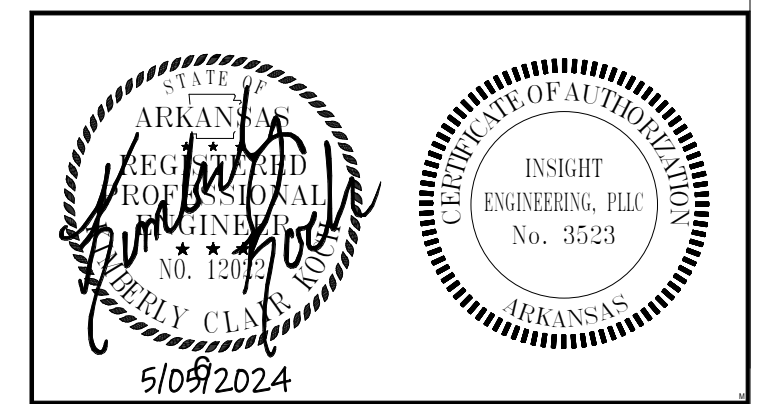

SHEET NUMBER **PD103**