

**GENERAL NOTES**

1. OUTLINED AREA INDICATES SCOPE OF WORK. PROVIDE NEW WHITE DECORA TYPE SWITCHES AND FACEPLATES FOR ALL LIGHTING DEVICES.

**KEYED NOTES**

① CONNECT NEW LIGHTING FIXTURES TO THE EXISTING ROOM LIGHTING CIRCUIT. ROUTE NEW LIGHTING CIRCUITRY THROUGH NEW LIGHTING CONTROLS.

② CONNECT NEW LIGHTING FIXTURE TO EXISTING CIRCUIT, TYPICAL.

③ INTERCEPT EXISTING LIGHTING CIRCUIT AND ROUTE THROUGH NEW ASTRONOMICAL TIMECLOCK ADJACENT TO EXISTING PANEL BOARD. FIELD VERIFY EXACT LOCATION. BASIS OF DESIGN: TORR ELGAR.

**TAGGART ARCHITECTS**

600 Main Street, Suite 300  
North Little Rock, AR 72114  
Phone: 501-758-7443  
Fax: 501-753-7309  
www.taggarch.com



NORTH LITTLE ROCK


NORTH LITTLE ROCK COMMUNITY CENTER RENOVATIONS

PROJECT NAME \_\_\_\_\_

SEAL \_\_\_\_\_

REVISIONS

NO.	DESCRIPTION	DATE


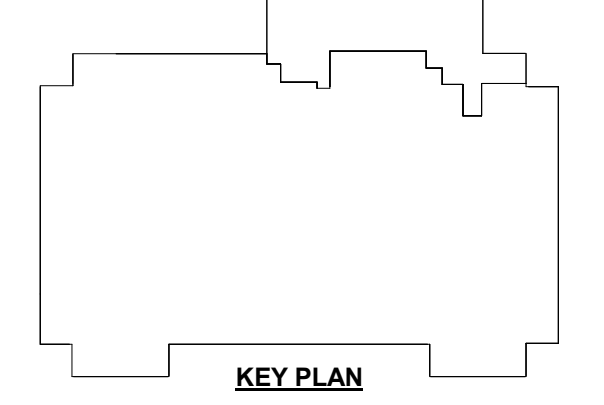


GROUND FLOOR PLAN - NORTH - LIGHTING

SHEET NAME \_\_\_\_\_  
DATE 5/05/2024

PROJECT NUMBER 161423

SHEET NUMBER **E201**

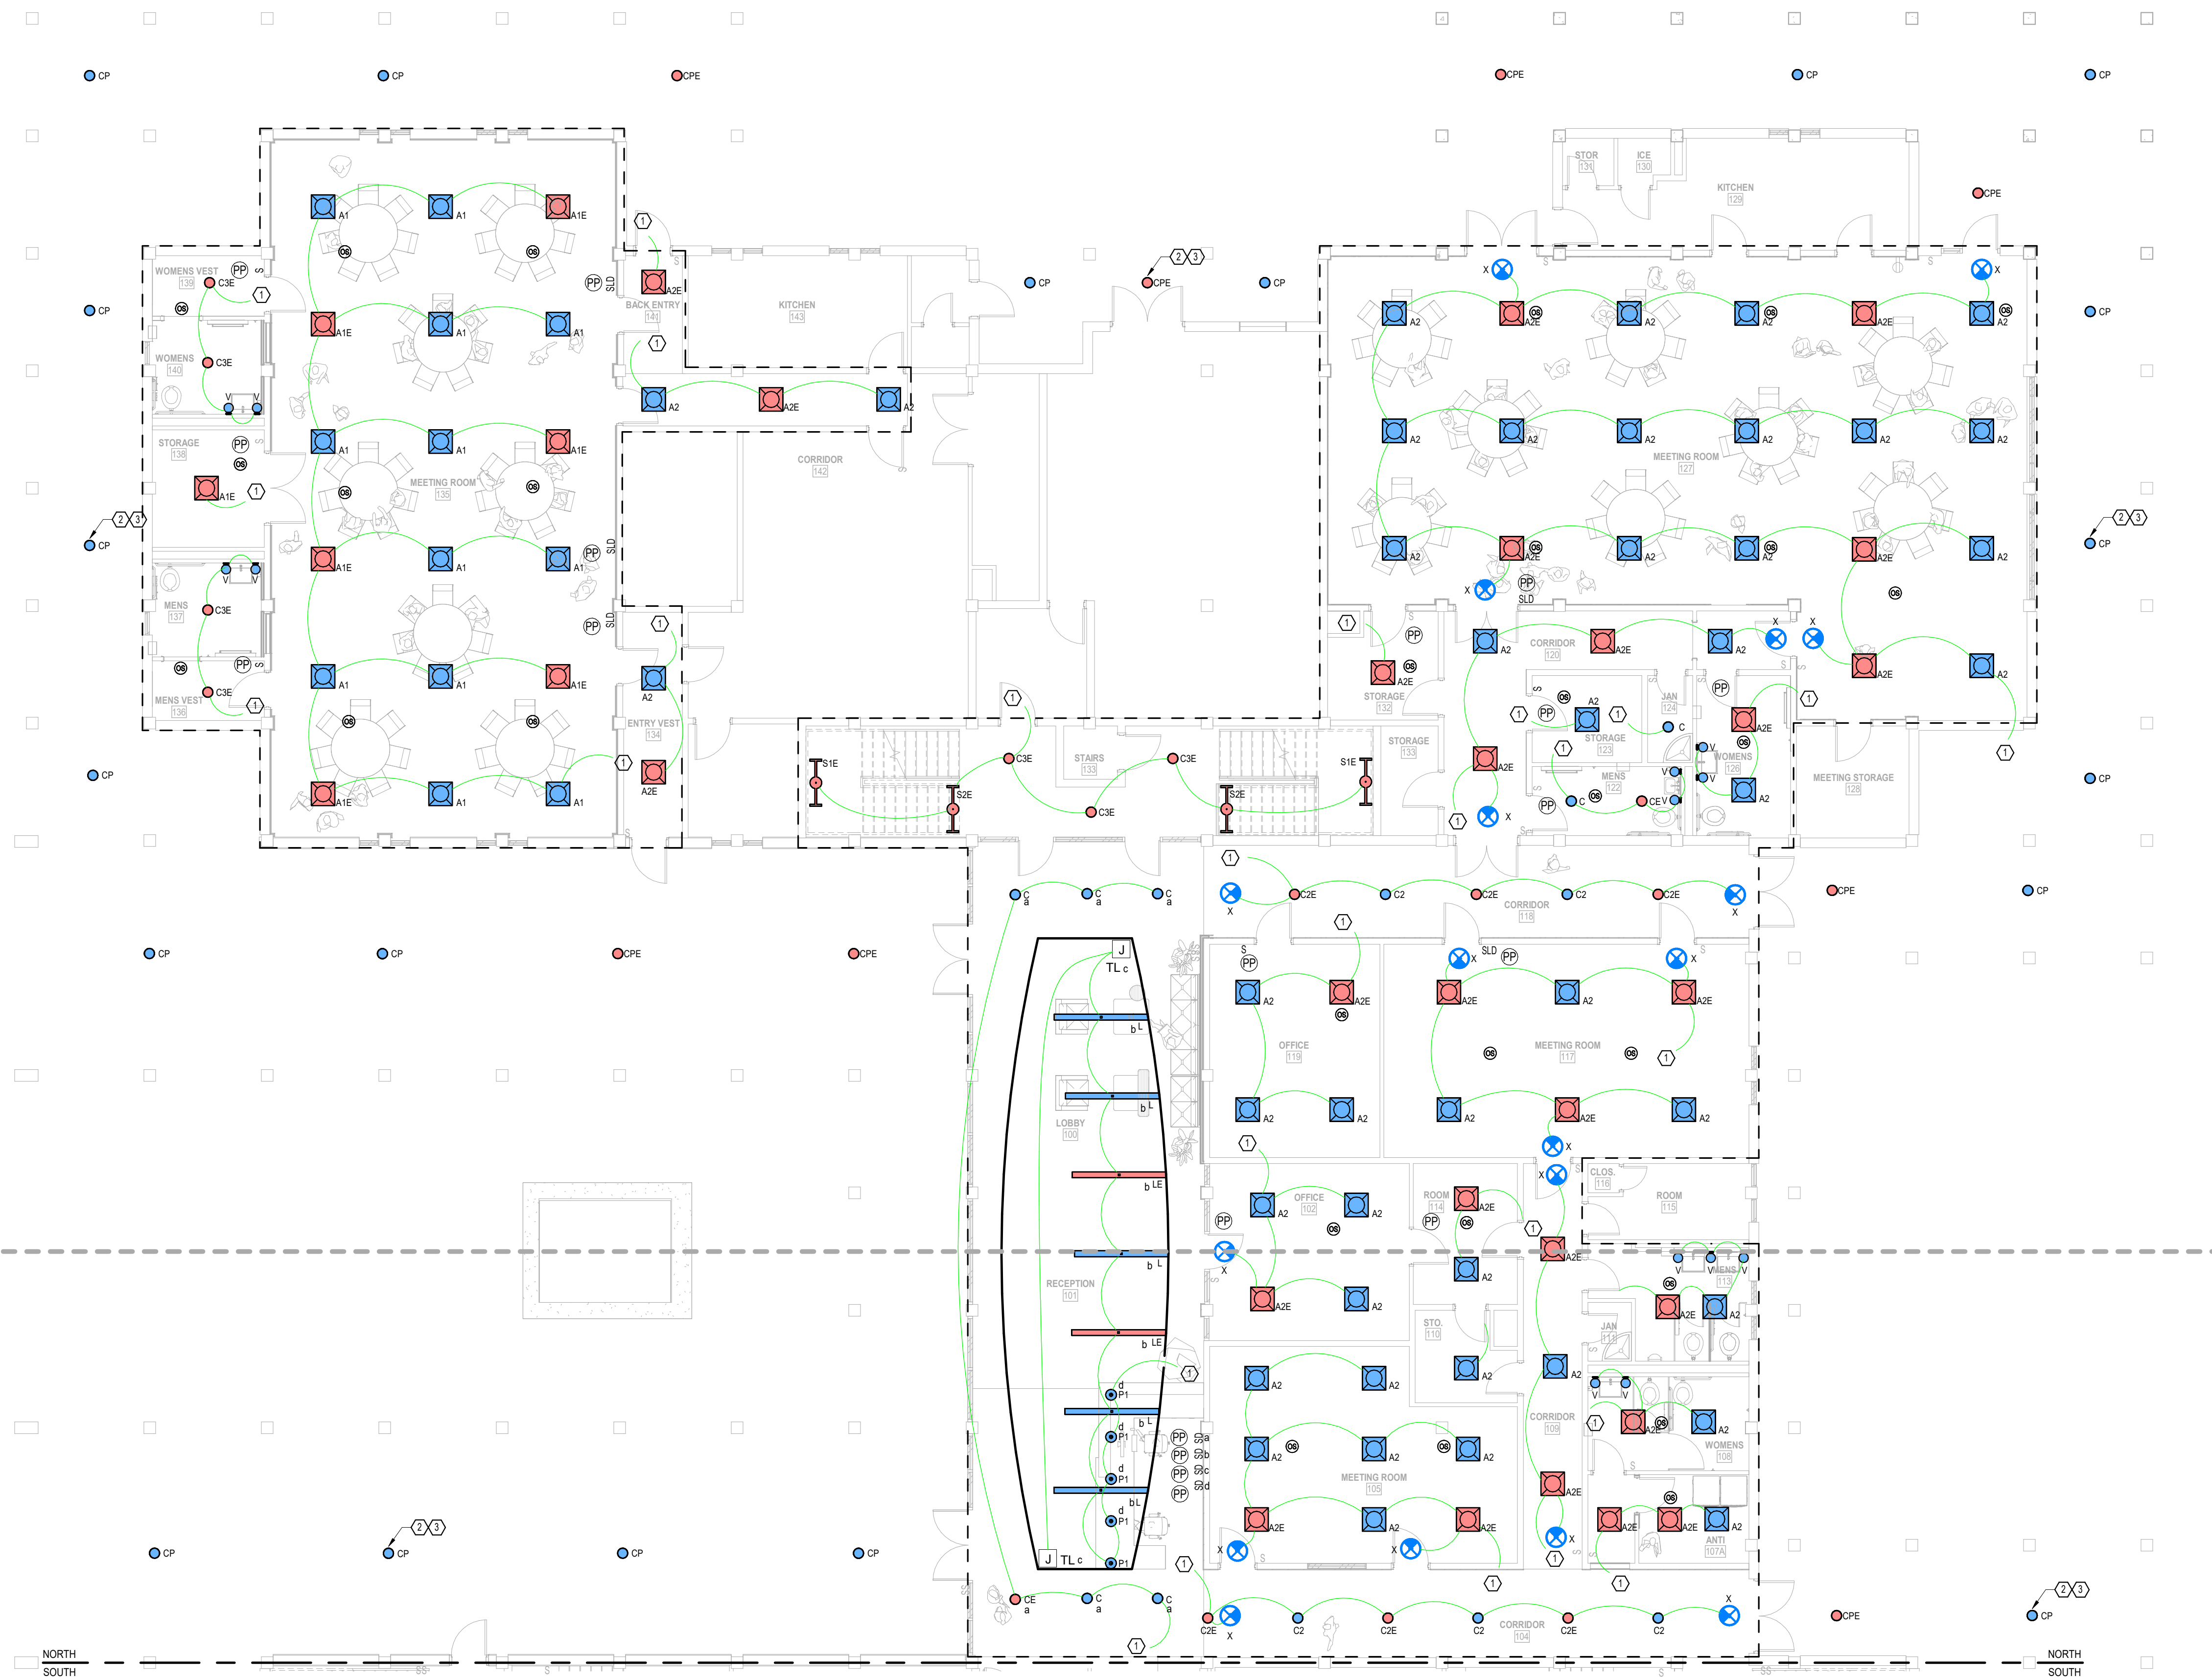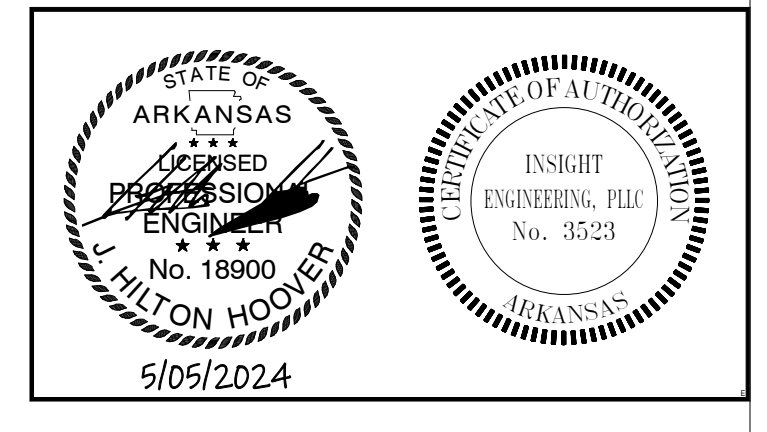

**1** GROUND FLOOR PLAN - NORTH - LIGHTING  
1/8" = 1'-0"

E

D

C

B

A

1

2

3

4

5

6

1

2

3

4

5

6