

- GENERAL NOTES**
1. OUTLINED AREA INDICATES SCOPE OF WORK. PROVIDE NEW WHITE DECORA TYPE SWITCHES AND FACEPLATES FOR ALL LIGHTING DEVICES.
- KEYED NOTES**
- ① CONNECT NEW LIGHTING FIXTURES TO THE EXISTING ROOM LIGHTING CIRCUIT. ROUTE NEW LIGHTING CIRCUITRY THROUGH NEW LIGHTING CONTROLS.
 - ② CONNECT NEW LIGHTING FIXTURE TO EXISTING CIRCUIT, TYPICAL.
 - ③ INTERCEPT EXISTING LIGHTING CIRCUIT AND ROUTE THROUGH NEW ASTRONOMICAL TIMECLOCK ADJACENT TO EXISTING PANEL BOARD. FIELD VERIFY EXACT LOCATION. BASIS OF DESIGN: TONY ELGAR.

TAGGART ARCHITECTS

600 Main Street, Suite 300
 North Little Rock, AR 72114
 Phone: 501-758-7443
 Fax: 501-753-7309
 www.taggarch.com



NORTH LITTLE ROCK



NORTH LITTLE ROCK
 COMMUNITY
 CENTER
 RENOVATIONS

PROJECT NAME _____

SEAL _____

REVISIONS

NO.	DESCRIPTION	DATE

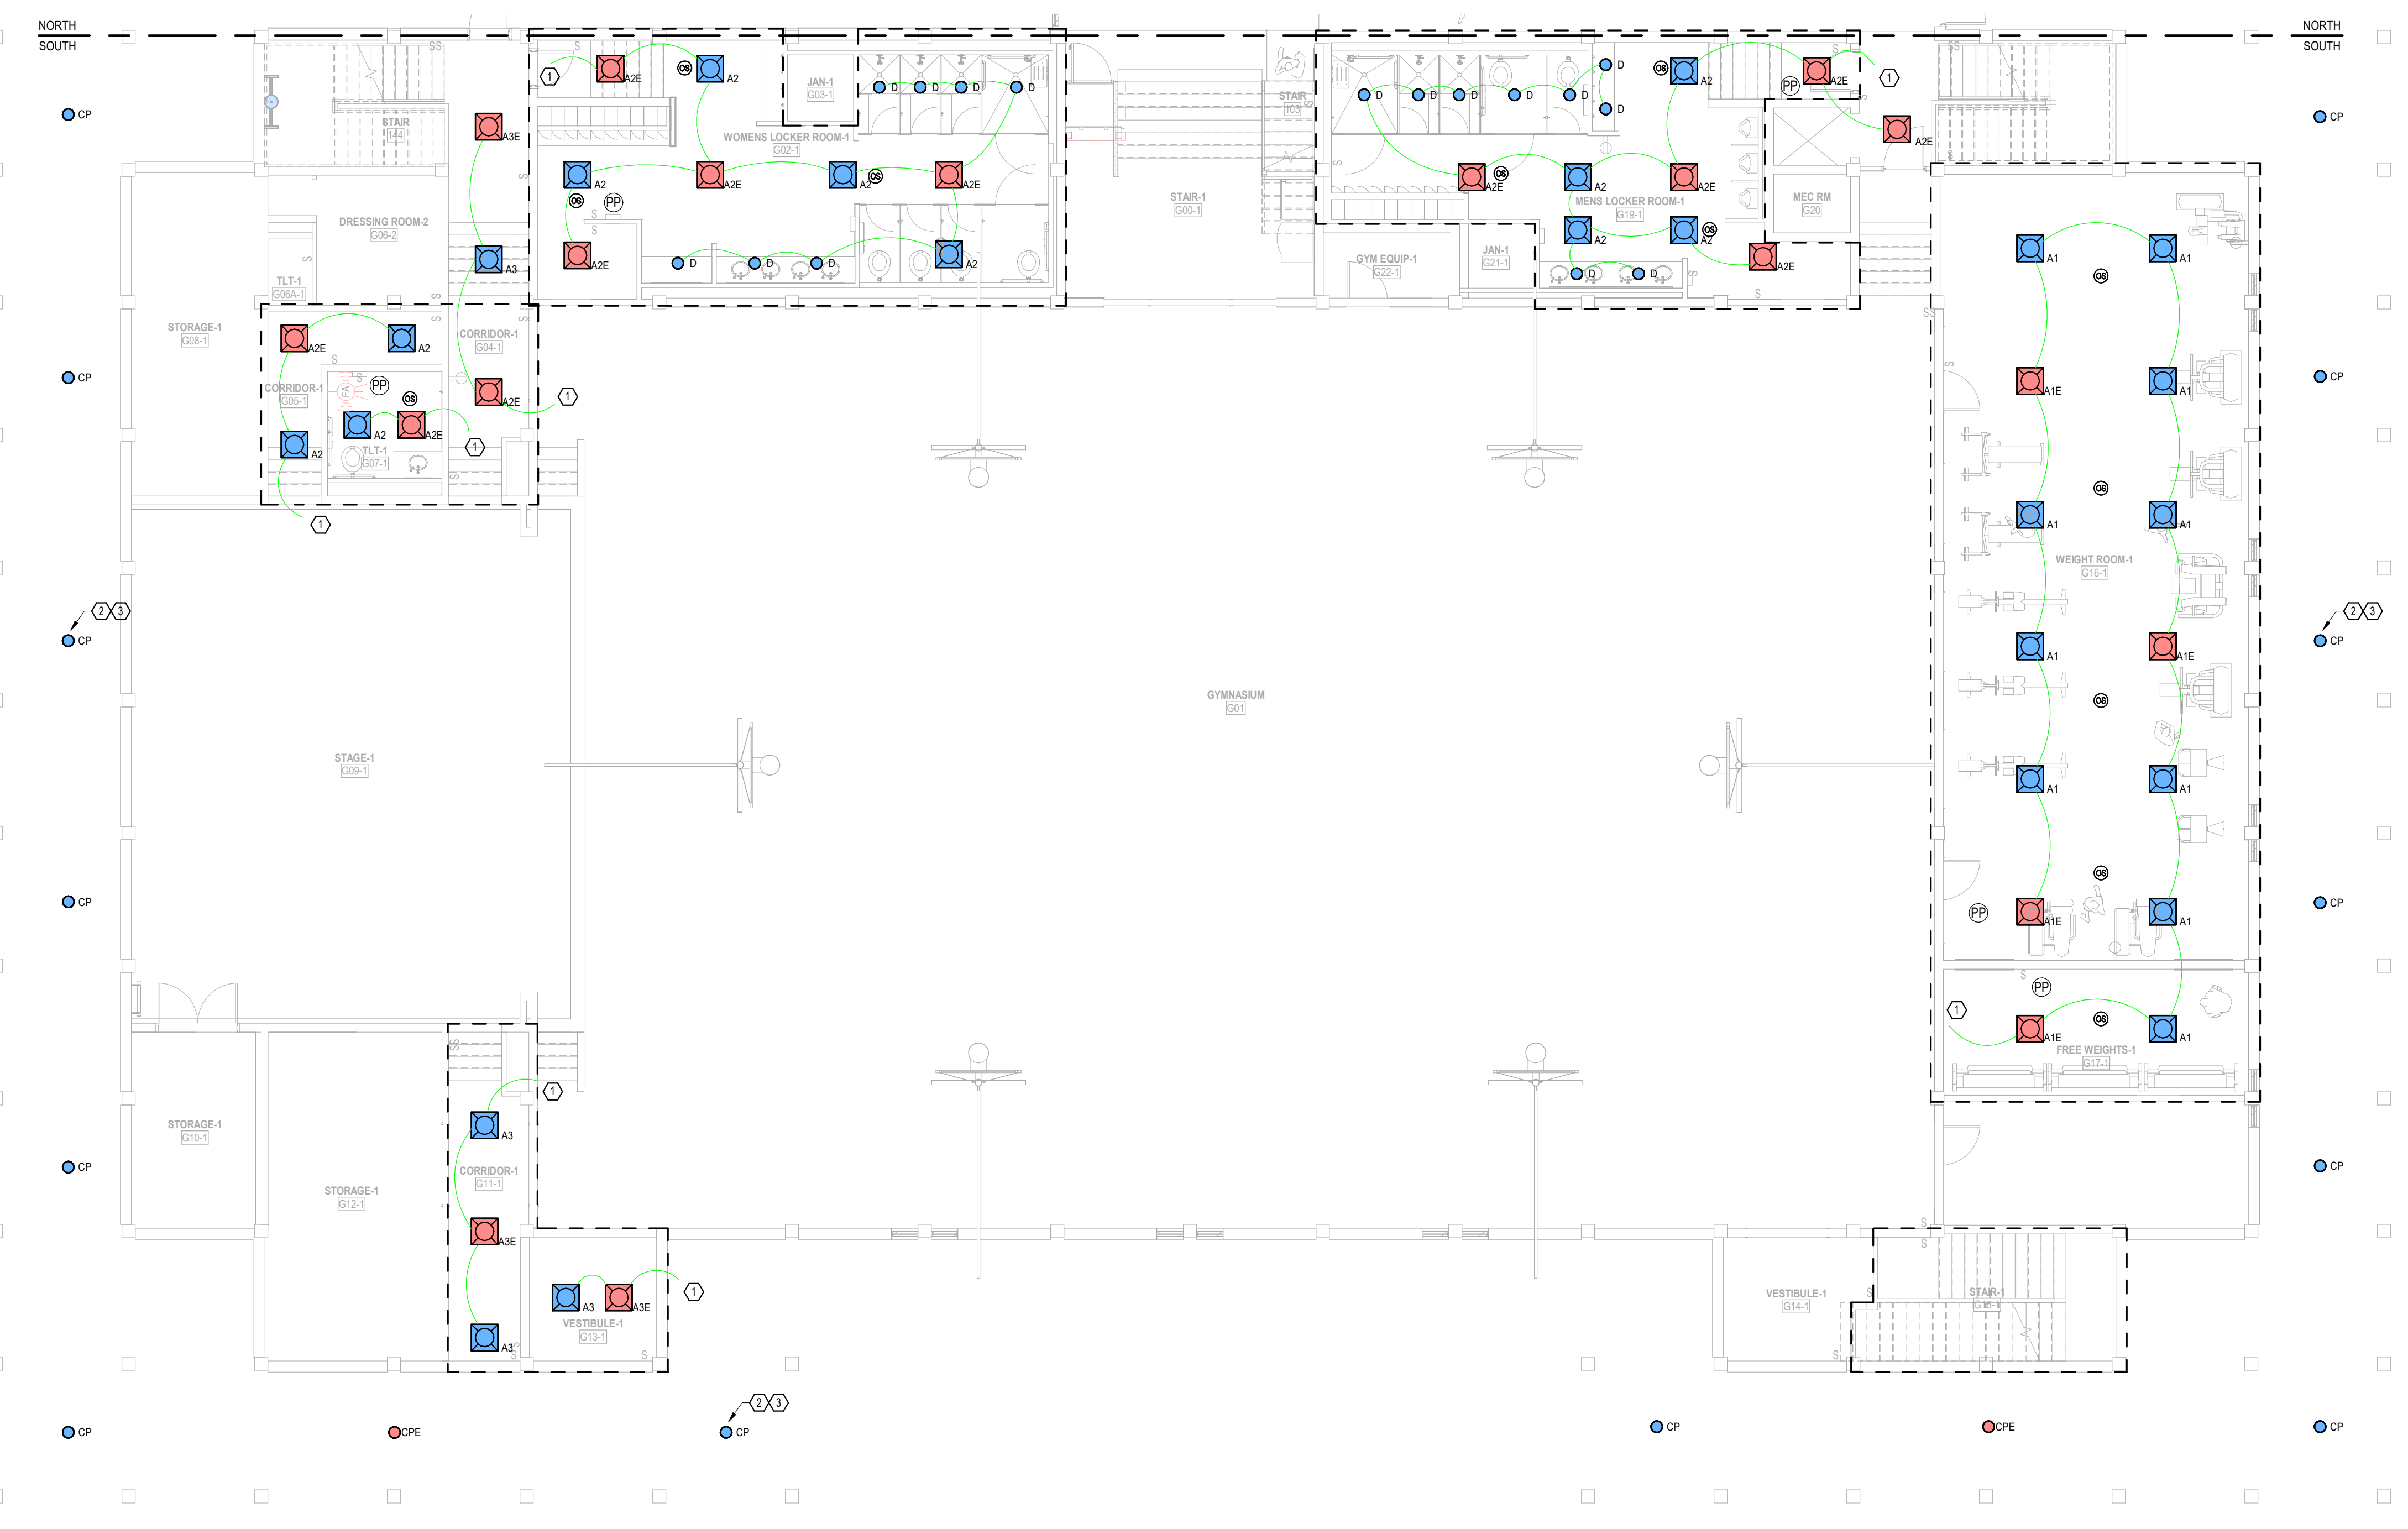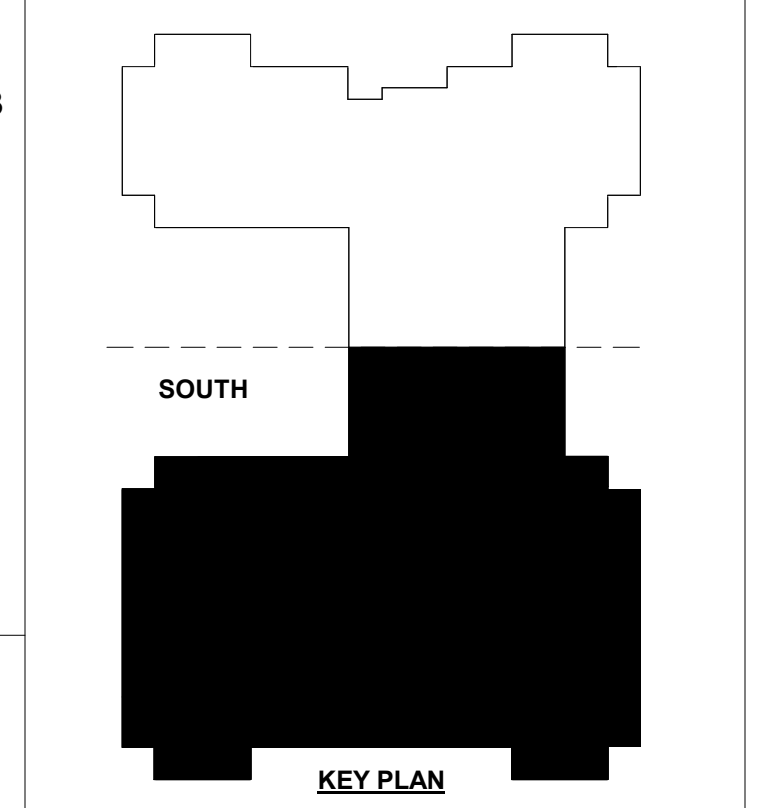


1 GROUND FLOOR PLAN - SOUTH - LIGHTING
 1/8" = 1'-0"

GROUND FLOOR PLAN -
 SOUTH - LIGHTING

SHEET NAME _____
 DATE 5/05/2024

PROJECT NUMBER 161423

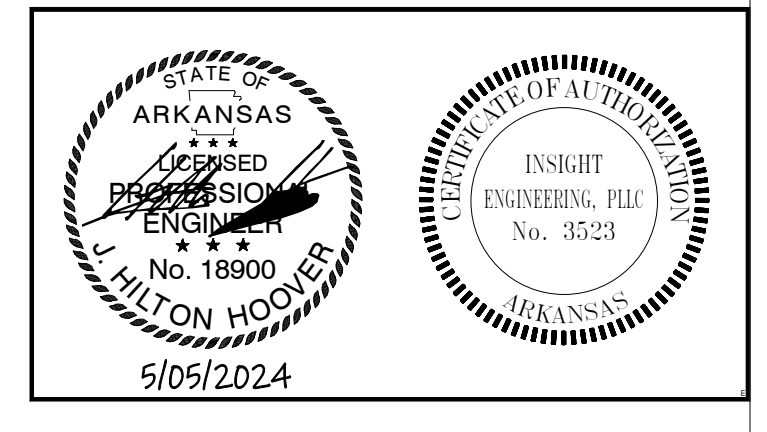

E202

SHEET NUMBER