

1 SECOND FLOOR PLAN - NORTH - LIGHTING
1/8" = 1'-0"

GENERAL NOTES

1. OUTLINED AREA INDICATES SCOPE OF WORK. PROVIDE NEW WHITE DECORA TYPE SWITCHES AND FACEPLATES FOR ALL LIGHTING DEVICES.

KEYED NOTES

① ALL LIGHTING FIXTURES, WIRE, AND CONDUIT WITHIN INDICATED SPACE IS EXISTING TO REMAIN.

TAGGART ARCHITECTS

600 Main Street, Suite 300
North Little Rock, AR 72114
Phone: 501-758-7443
Fax: 501-753-7309
www.taggarch.com



NORTH LITTLE ROCK


NORTH LITTLE ROCK
COMMUNITY
CENTER
RENOVATIONS

PROJECT NAME _____

SEAL _____

REVISIONS


NO.	DESCRIPTION	DATE

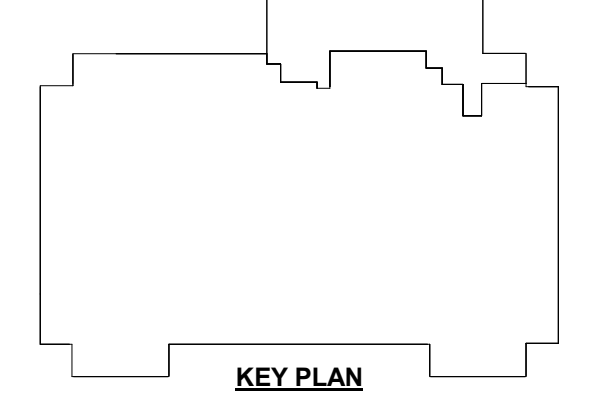

SECOND FLOOR PLAN -
NORTH - LIGHTING

SHEET NAME _____
DATE 5/05/2024

PROJECT NUMBER 161423

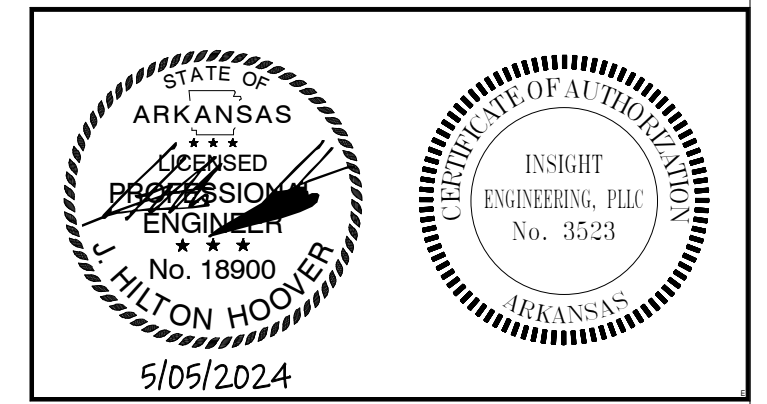

E203

SHEET NUMBER _____