

**GENERAL NOTES**

1. OUTLINED AREA INDICATES SCOPE OF WORK. PROVIDE NEW WHITE DECORA TYPE SWITCHES AND FACEPLATES FOR ALL LIGHTING DEVICES.

**KEYED NOTES**

⊙ CONNECT NEW LIGHTING FIXTURES TO THE EXISTING ROOM LIGHTING CIRCUIT. ROUTE NEW LIGHTING CIRCUITRY THROUGH NEW LIGHTING CONTROLS.

**TAGGART ARCHITECTS**

600 Main Street, Suite 300  
 North Little Rock, AR 72114  
 Phone: 501-758-7443  
 Fax: 501-753-7309  
 www.taggarch.com



NORTH LITTLE ROCK


NORTH LITTLE ROCK COMMUNITY CENTER RENOVATIONS

PROJECT NAME \_\_\_\_\_

SEAL \_\_\_\_\_

REVISIONS

NO.	DESCRIPTION	DATE

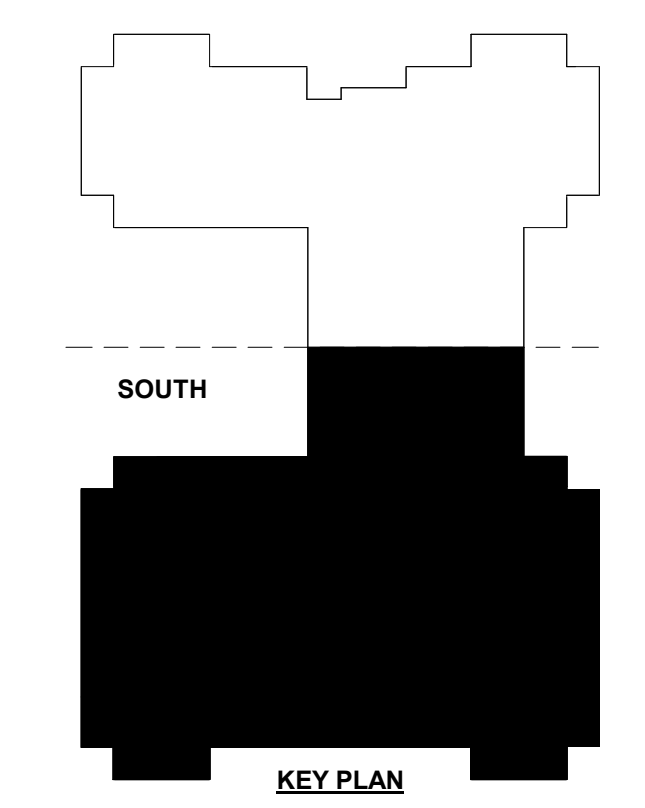


SECOND FLOOR PLAN - SOUTH - LIGHTING

SHEET NAME \_\_\_\_\_  
 DATE 5/05/2024

PROJECT NUMBER 161423

SHEET NUMBER **E204**

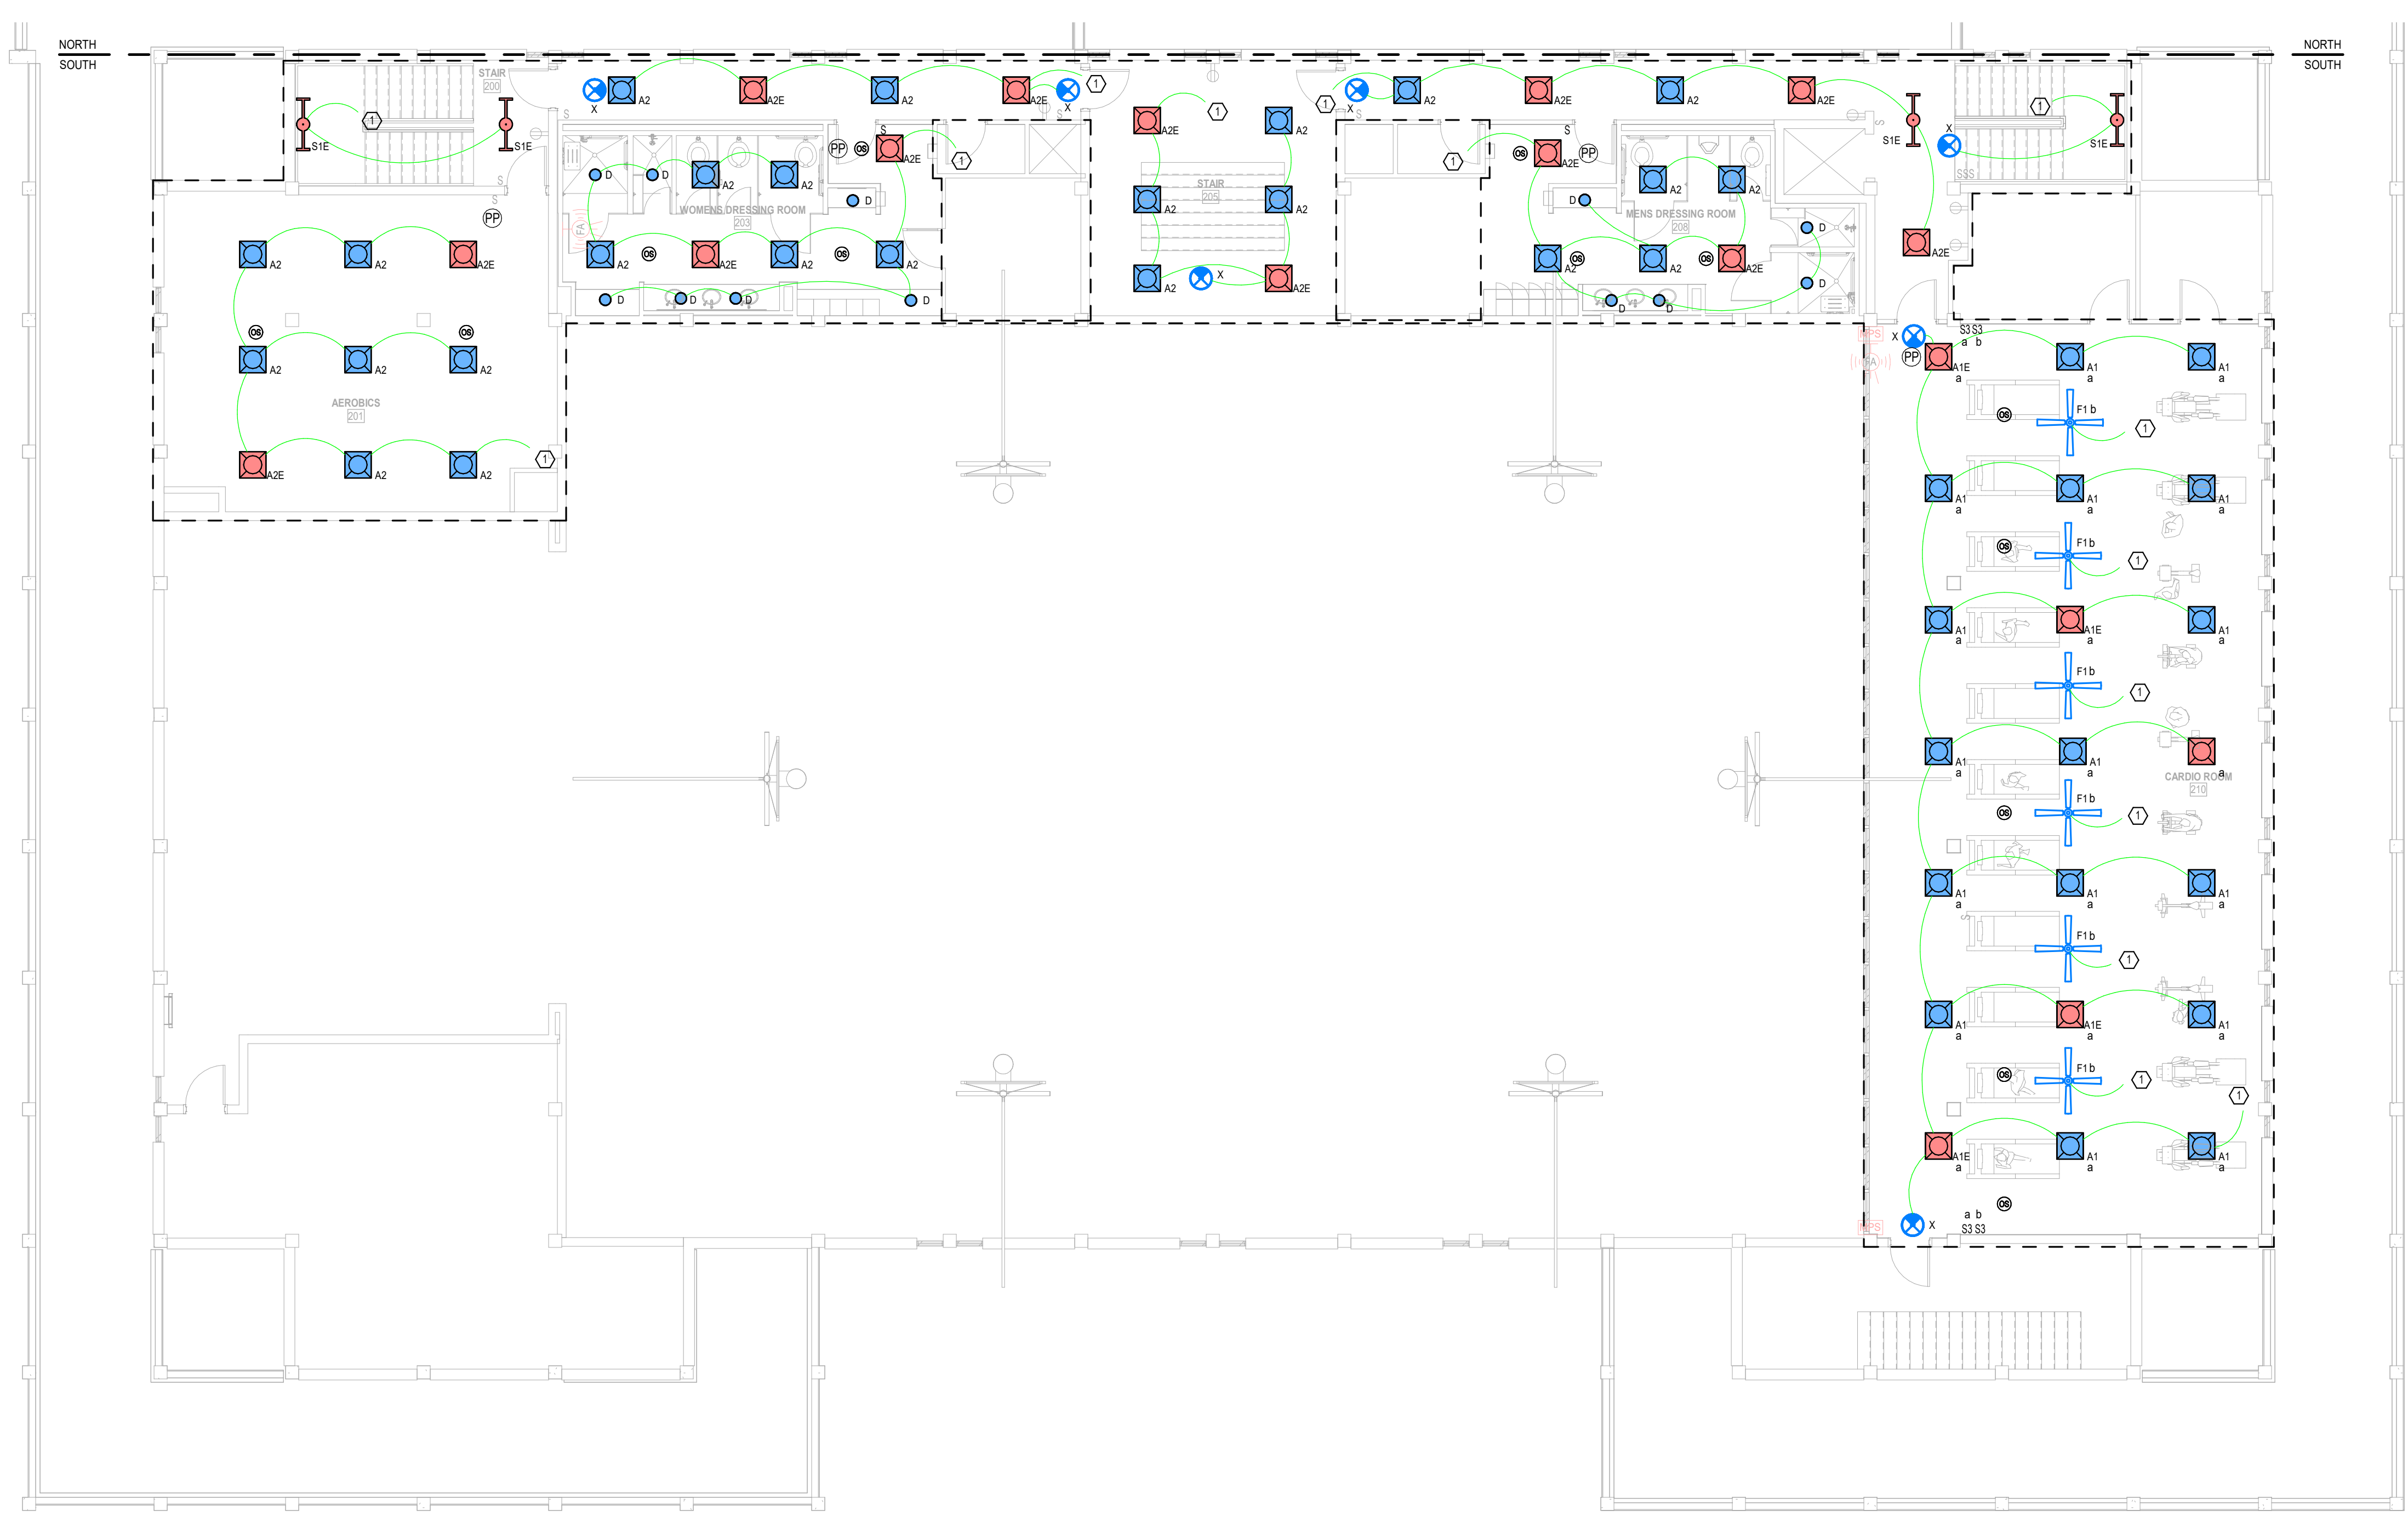

1 SECOND FLOOR PLAN - SOUTH - LIGHTING  
 1/8" = 1'-0"

