

- GENERAL NOTES**
1. OUTLINED AREA INDICATES SCOPE OF WORK: PROVIDE NEW WHITE DECORA TYPE RECEPTACLES AND FACEPLATES FOR RECEPTACLES. CONNECT EXISTING WIRE AND CONDUIT TO NEW DEVICES.
  2. OUTLINED AREA INDICATES SCOPE OF WORK: PROVIDE NEW BLUE DATA JACKS AND WHITE FACEPLATES FOR ALL INDICATED DATA OUTLETS.
  3. ALL FIRE ALARM, SECURITY, AND CCTV DEVICES ARE EXISTING TO REMAIN. DEVICES IN CEILING SHALL BE RELOCATED AND INSTALLED WITHIN NEW CEILING.
  4. ALL FLOOR BOXES ARE EXISTING TO REMAIN.

**TAGGART ARCHITECTS**

600 Main Street, Suite 300  
 North Little Rock, AR 72114  
 Phone: 501-758-7443  
 Fax: 501-753-7309  
 www.taggarch.com



**NORTH LITTLE ROCK**


**NORTH LITTLE ROCK COMMUNITY CENTER RENOVATIONS**

PROJECT NAME \_\_\_\_\_

SEAL \_\_\_\_\_

REVISIONS

NO.	DESCRIPTION	DATE

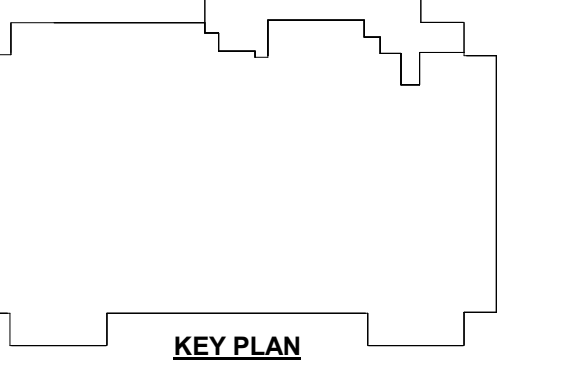



**SECOND FLOOR PLAN - NORTH - POWER AND SYSTEMS**

SHEET NAME \_\_\_\_\_

DATE 5/05/2024

PROJECT NUMBER 161423

SHEET NUMBER **E207**

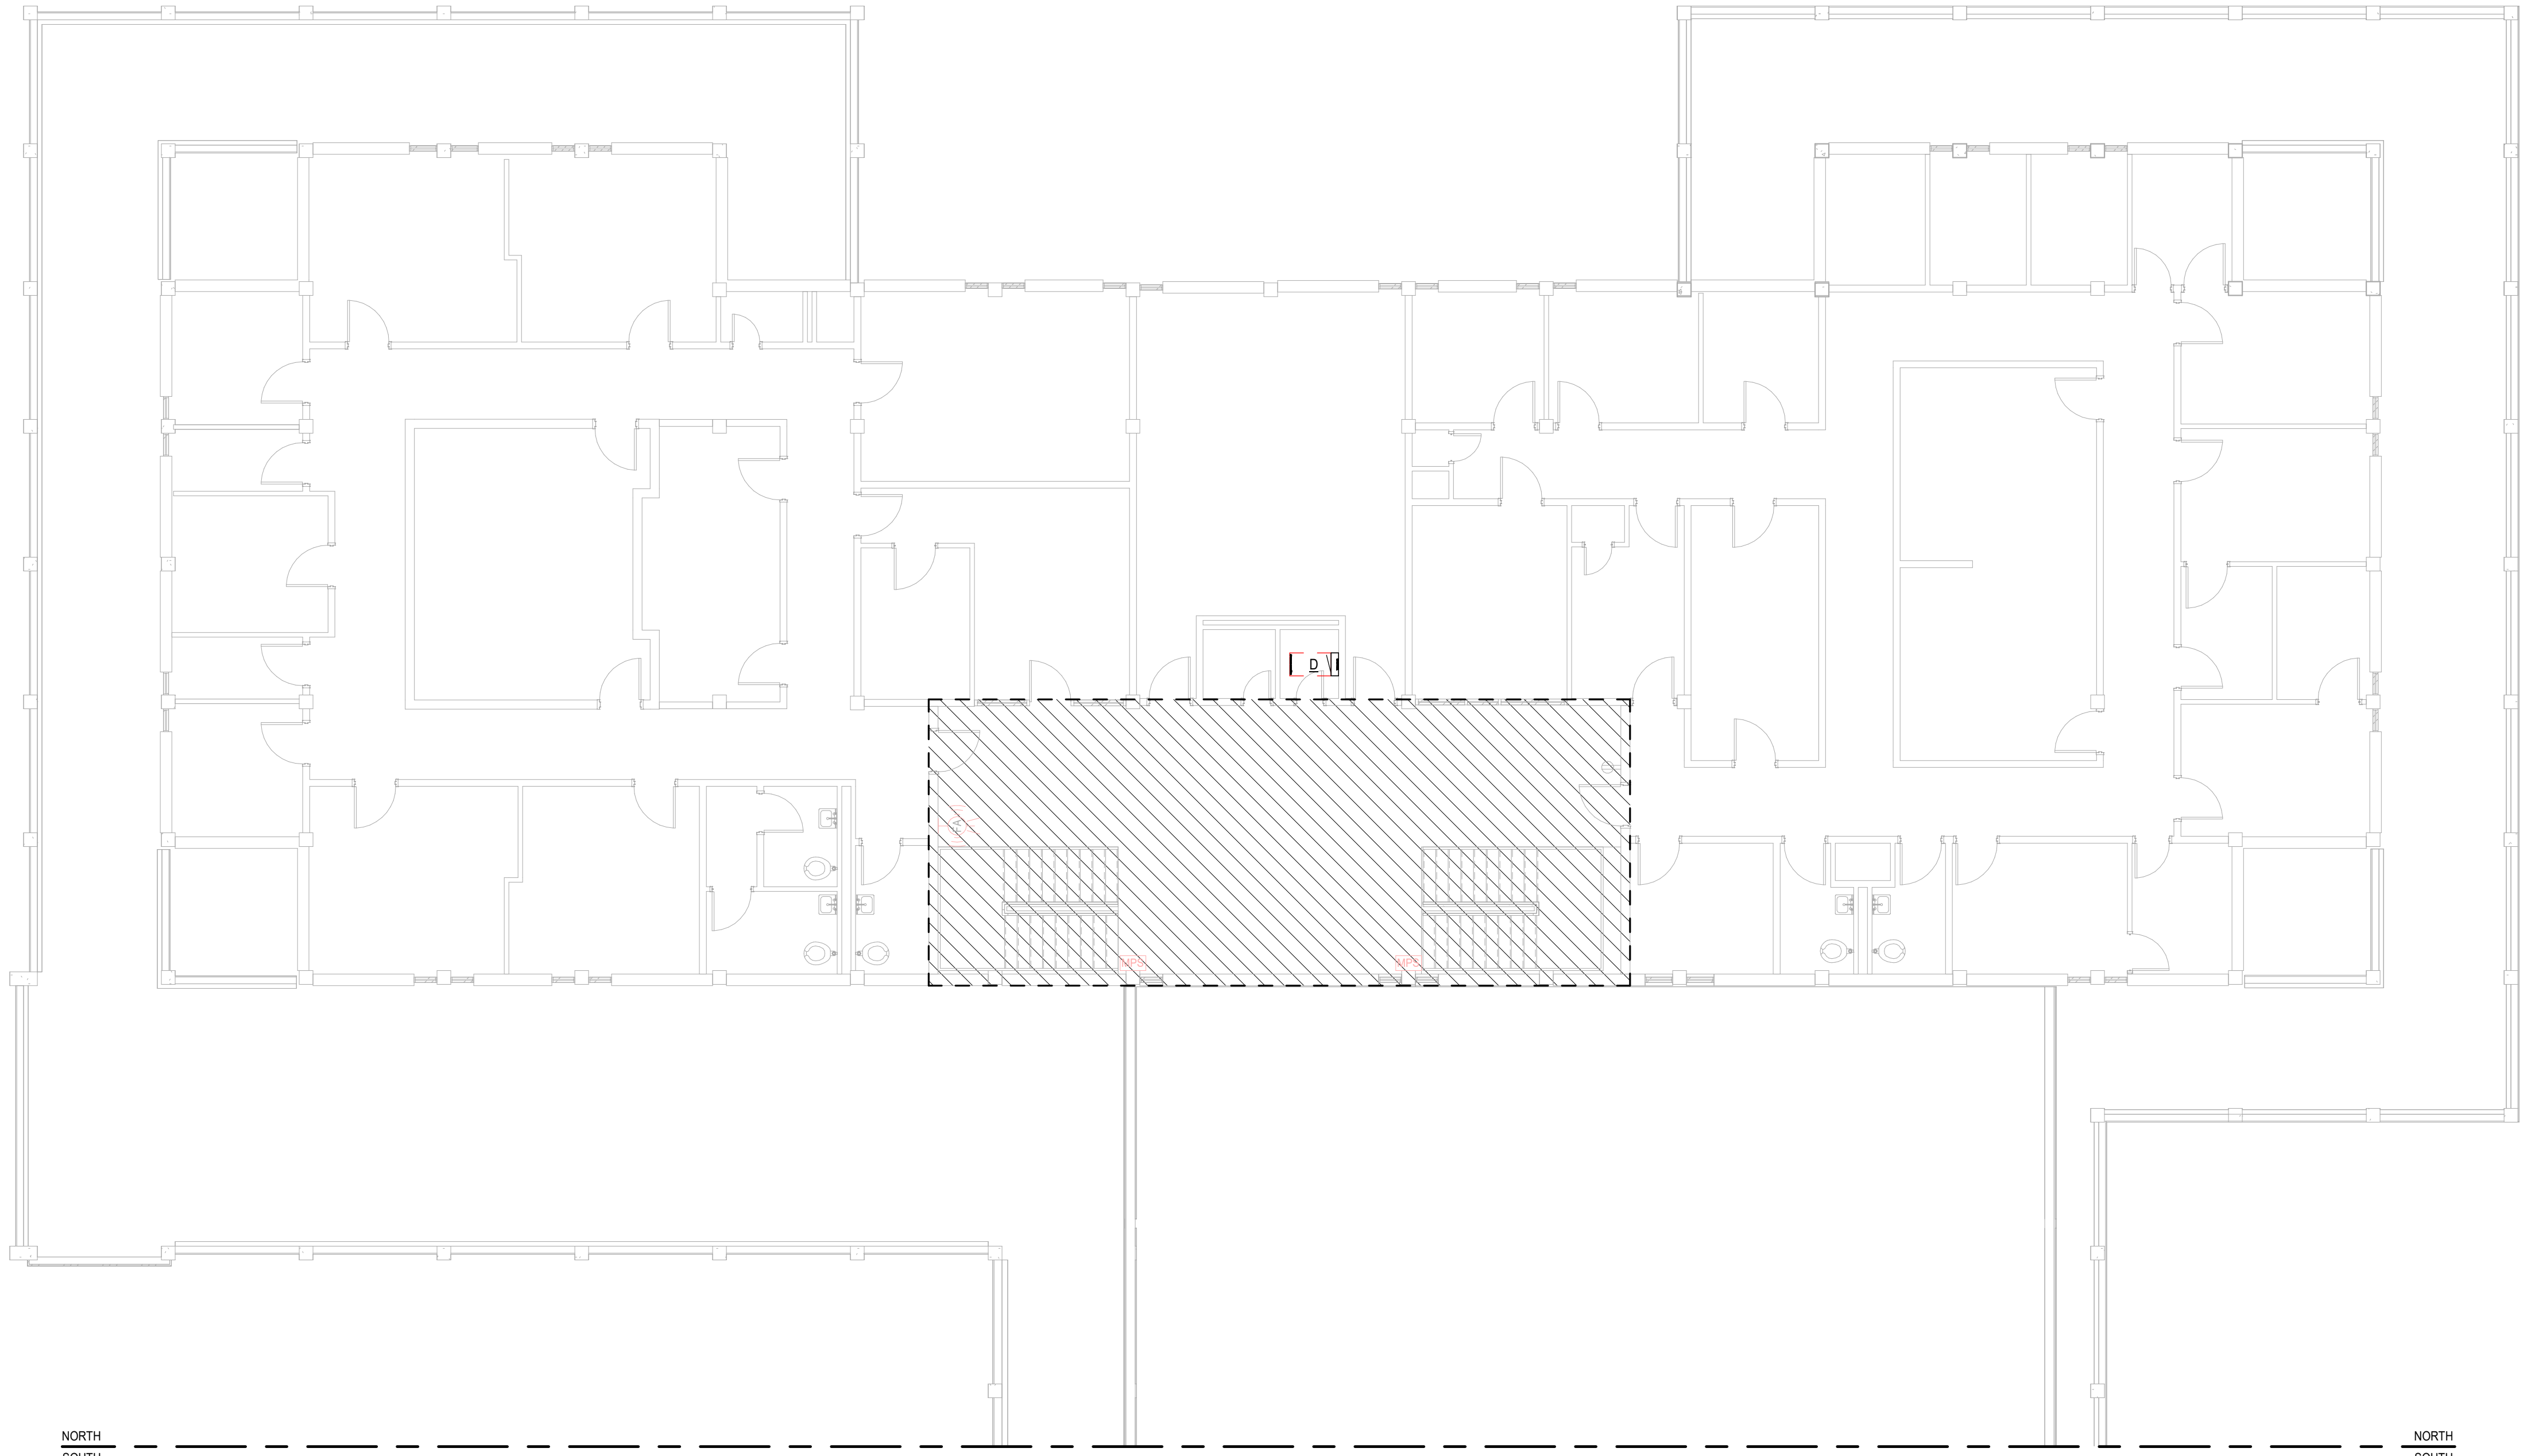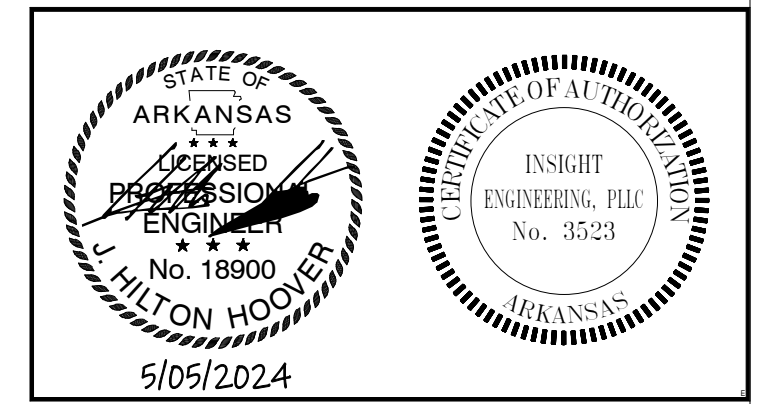

**1 SECOND FLOOR PLAN - NORTH - POWER AND SYSTEMS**  
 1/8" = 1'-0"