

1 GROUND FLOOR PLAN - NORTH - ELECTRICAL DEMOLITION
 1/8" = 1'-0"

DEMOLITION GENERAL NOTES

- ELECTRICAL CONTRACTOR SHALL CONSULT ARCHITECTURAL DRAWINGS FOR FULL EXTENT OF DEMOLITION TO BE PERFORMED.
 - OWNER SHALL RESERVE THE RIGHT TO CLAIM ALL EQUIPMENT AND CABLING REMOVED DURING DEMOLITION.
 - COORDINATE ALL DEMOLITION ACTIVITIES WITH OWNER AND ARCHITECT. PROVIDE 10 DAYS NOTICE FOR ANY POWER OUTAGES.
- DEMOLITION SCOPE:
- HATCHED AREA INDICATES SCOPE OF WORK. IN ALL AREAS OTHER THAN WHERE EQUIPMENT, FIXTURES, AND DEVICES HAVE BEEN INDICATED TO REMAIN, REMOVE ALL WALL/CEILING MOUNTED LIGHTING FIXTURES, EXIT SIGNS, AND ALL ASSOCIATED WIRING BACK TO JUNCTION BOX SERVING THE SPACE. DEMOLITION CONTRACTORS SHALL PATCH WALL/FLOOR WHERE WALL DEVICES/EQUIPMENT WERE REMOVED. UNUSED CIRCUIT BREAKERS TO BE TURNED OFF POSITION AS THE CIRCUITS ARE DEMOLISHED. OWNER SHALL HAVE THE RIGHT TO REFUSAL OF ALL FIXTURES AND DEVICES.
 - HATCHED AREA INDICATES SCOPE OF WORK. DEMOLISH RECEPTACLES, TELEPHONE OUTLETS, AND LIGHTING SWITCHES. ALL WIRE, CABLE, AND CONDUIT SERVICE DEVICES SHALL REMAIN FOR NEW DEVICE CONNECTIONS.
 - HATCHED AREA INDICATES SCOPE OF WORK. CONTRACTOR SHALL REMOVE ALL DEVICES WITHIN DEMOLISHED WALLS INCLUDING RECEPTACLES, LIGHTING FIXTURES, SWITCHES, DATA/TELEPHONE DROPS. REMOVE CONDUIT AND WIRING BACK TO SOURCE. REFER TO ARCHITECTURAL DEMO PLAN.
- EXISTING TO REMAIN SCOPE:
- ALL WIRE, CABLE, AND CONDUIT SERVING RECEPTACLES, TELEPHONE OUTLETS, DATA OUTLETS, FIRE ALARM DEVICES, MECHANICAL EQUIPMENT, AND ALL OTHER DEVICES OR EQUIPMENT SHALL REMAIN UNLESS NOTED OTHERWISE.
 - ALL FIRE ALARM, SECURITY, AND CCTV DEVICES ARE EXISTING TO REMAIN. DEVICES IN CEILING SHALL BE RELOCATED AND INSTALLED WITHIN NEW CEILING.
 - ALL ELECTRICAL EQUIPMENT, DEVICES, WIRE, CABLE AND CONDUIT SERVING EQUIPMENT AND DEVICES OUTSIDE OF THE INDICATED SCOPE OF WORK SHALL REMAIN.

KEYED NOTES

- ALL OUTLETS, FACEPLATES, BACK BOXES, DEVICES, WIRE, AND CONDUIT WITHIN INDICATED SPACE IS EXISTING TO REMAIN.



600 Main Street, Suite 300
 North Little Rock, AR 72114
 Phone: 501-758-7443
 Fax: 501-753-7309
 www.taggarch.com



NORTH LITTLE ROCK


NORTH LITTLE ROCK
 COMMUNITY
 CENTER
 RENOVATIONS

PROJECT NAME _____

SEAL _____

REVISIONS

NO.	DESCRIPTION	DATE

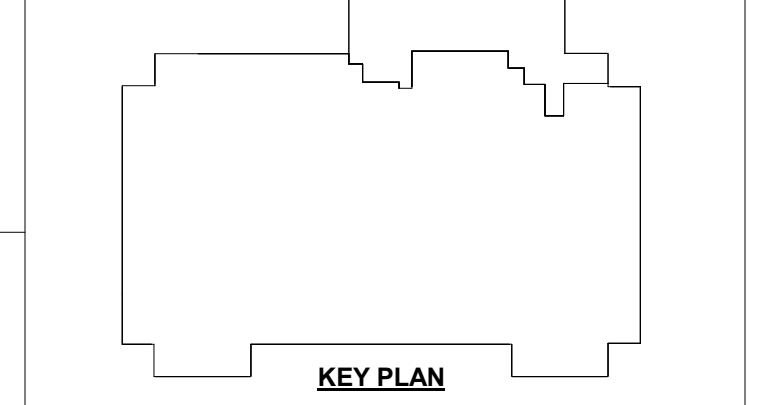

GROUND FLOOR PLAN -
 NORTH - ELECTRICAL
 DEMOLITION

SHEET NAME _____
 DATE 5/05/2024

PROJECT NUMBER 161423

SHEET NUMBER ED101

