



1 SECOND FLOOR PLAN - NORTH - ELECTRICAL DEMOLITION
1/8" = 1'-0"

DEMOLITION GENERAL NOTES

1. ELECTRICAL CONTRACTOR SHALL CONSULT ARCHITECTURAL DRAWINGS FOR FULL EXTENT OF DEMOLITION TO BE PERFORMED.
 2. OWNER SHALL RESERVE THE RIGHT TO CLAIM ALL EQUIPMENT AND CABLING REMOVED DURING DEMOLITION.
 3. COORDINATE ALL DEMOLITION ACTIVITIES WITH OWNER AND ARCHITECT. PROVIDE 10 DAYS NOTICE FOR ANY POWER OUTAGES.
- DEMOLITION:
4. HATCHED AREA INDICATES SCOPE OF WORK. IN ALL AREAS OTHER THAN WHERE EQUIPMENT AND DEVICES HAVE BEEN INDICATED TO REMAIN, REMOVE ALL WALL/CEILING MOUNTED LIGHTING FIXTURES, EXIT SIGNS, AND ALL ASSOCIATED WIRING BACK TO JUNCTION BOX SERVING THE SPACE. DEMOLITION CONTRACTORS SHALL PATCH WALL/FLOOR WHERE WALL DEVICES/EQUIPMENT WERE REMOVED. UNUSED CIRCUIT BREAKERS TO BE TURNED TO OFF POSITION AS THE CIRCUITS ARE DEMOLISHED. OWNER SHALL HAVE THE RIGHT TO REFUSAL OF ALL FIXTURES AND DEVICES.
 5. HATCHED AREA INDICATES SCOPE OF WORK. DEMOLISH RECEPTACLES, TELEPHONE OUTLETS, AND LIGHTING SWITCHES. ALL WIRE, CABLE, AND CONDUIT SERVING DEVICES SHALL REMAIN FOR NEW DEVICE CONNECTIONS.
 6. HATCHED AREA INDICATES SCOPE OF WORK. CONTRACTOR SHALL REMOVE ALL DEVICES WITHIN DEMOLISHED WALLS INCLUDING RECEPTACLES, LIGHTING FIXTURES, SWITCHES, DATA TELEPHONE DROPS. REMOVE CONDUIT AND WIRING BACK TO SOURCE. REFER TO ARCHITECTURAL DEMO PLAN.
- EXISTING TO REMAIN:
1. ALL WIRE, CABLE, AND CONDUIT SERVING RECEPTACLES, TELEPHONE OUTLETS, DATA OUTLETS, FIRE ALARM DEVICES, MECHANICAL EQUIPMENT, AND ALL OTHER DEVICES OR EQUIPMENT SHALL REMAIN UNLESS NOTED OTHERWISE.
 2. ALL FIRE ALARM, SECURITY, AND CCTV DEVICES ARE EXISTING TO REMAIN. DEVICES IN CEILING SHALL BE RELOCATED AND INSTALLED WITHIN NEW CEILING.
 3. ALL ELECTRICAL EQUIPMENT, DEVICES, WIRE, CABLE AND CONDUIT SERVING EQUIPMENT AND DEVICES OUTSIDE OF THE INDICATED SCOPE OF WORK SHALL REMAIN.

KEYED NOTES

- ① ALL LIGHTING FIXTURES, WIRE, AND CONDUIT WITHIN INDICATED SPACE IS EXISTING TO REMAIN.



600 Main Street, Suite 300
North Little Rock, AR 72114
Phone: 501-758-7443
Fax: 501-753-7309
www.taggarch.com



NORTH LITTLE ROCK


NORTH LITTLE ROCK
COMMUNITY
CENTER
RENOVATIONS

PROJECT NAME _____

SEAL _____

REVISIONS


NO.	DESCRIPTION	DATE

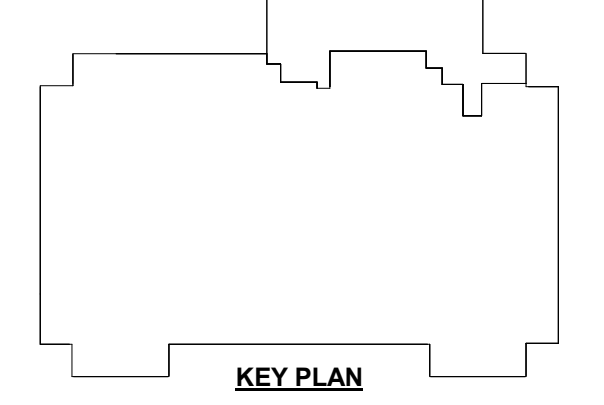

SECOND FLOOR PLAN -
NORTH - ELECTRICAL
DEMOLITION

SHEET NAME _____
DATE 5/05/2024

PROJECT NUMBER 161423

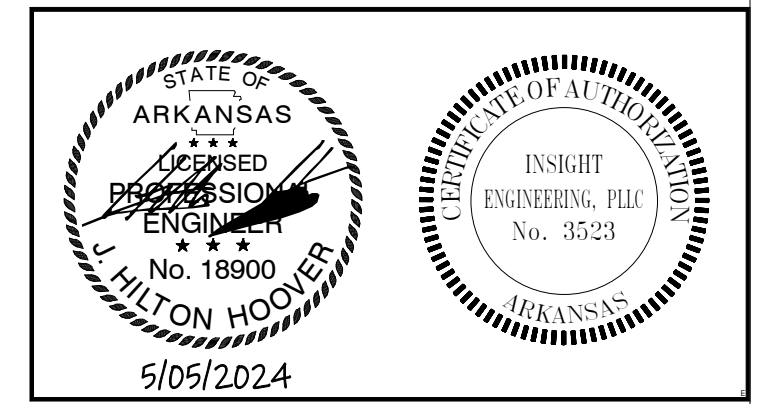

ED103
SHEET NUMBER