




KEYNOTES	
1	ACCESS CONTROL PANELS BY SIC QTY (AS REQUIRED). ACCESS CONTROL PANELS SHALL BE STACKED
2	DC SHALL INCLUDE A 1-PORIT BUSHOUT BOX MOUNTED INSIDE EACH ACCESS CONTROL PANEL (VERIFY FINAL QTY)
3	GROUNDING BUS BAR BY EC
4	2 BONDING STRIP 120W GA TRANSFER SWITCHES FEED BY DESIGNATED (A) AND (B) 120V 2W CIRCUITS FOR EACH ACCESS CONTROL PANEL BY EC
5	1 PORT DATA RACK BY EC
6	VERTICAL POST WITH STAND-OFF BRACKETS BY EC
7	6 VERTICAL WIRE MANAGER OR EC
8	16 1/8 X 30 RECEPTS ARE FEED BY DESIGNATED (A) AND (B) 1 UPS AND MOUNTED TO SIDE OF BASKET TRAY BY EC (TYPICAL)
9	ACCESS CONTROLS DEVICES BY SC
10	8" WIDE LADDER RACK BY EC
11	3/4" X 10' LENGTH AS SHOWN FIRE TREATED PLYWOOD FURNISHED AND INSTALLED BY GC AT BOTTOM

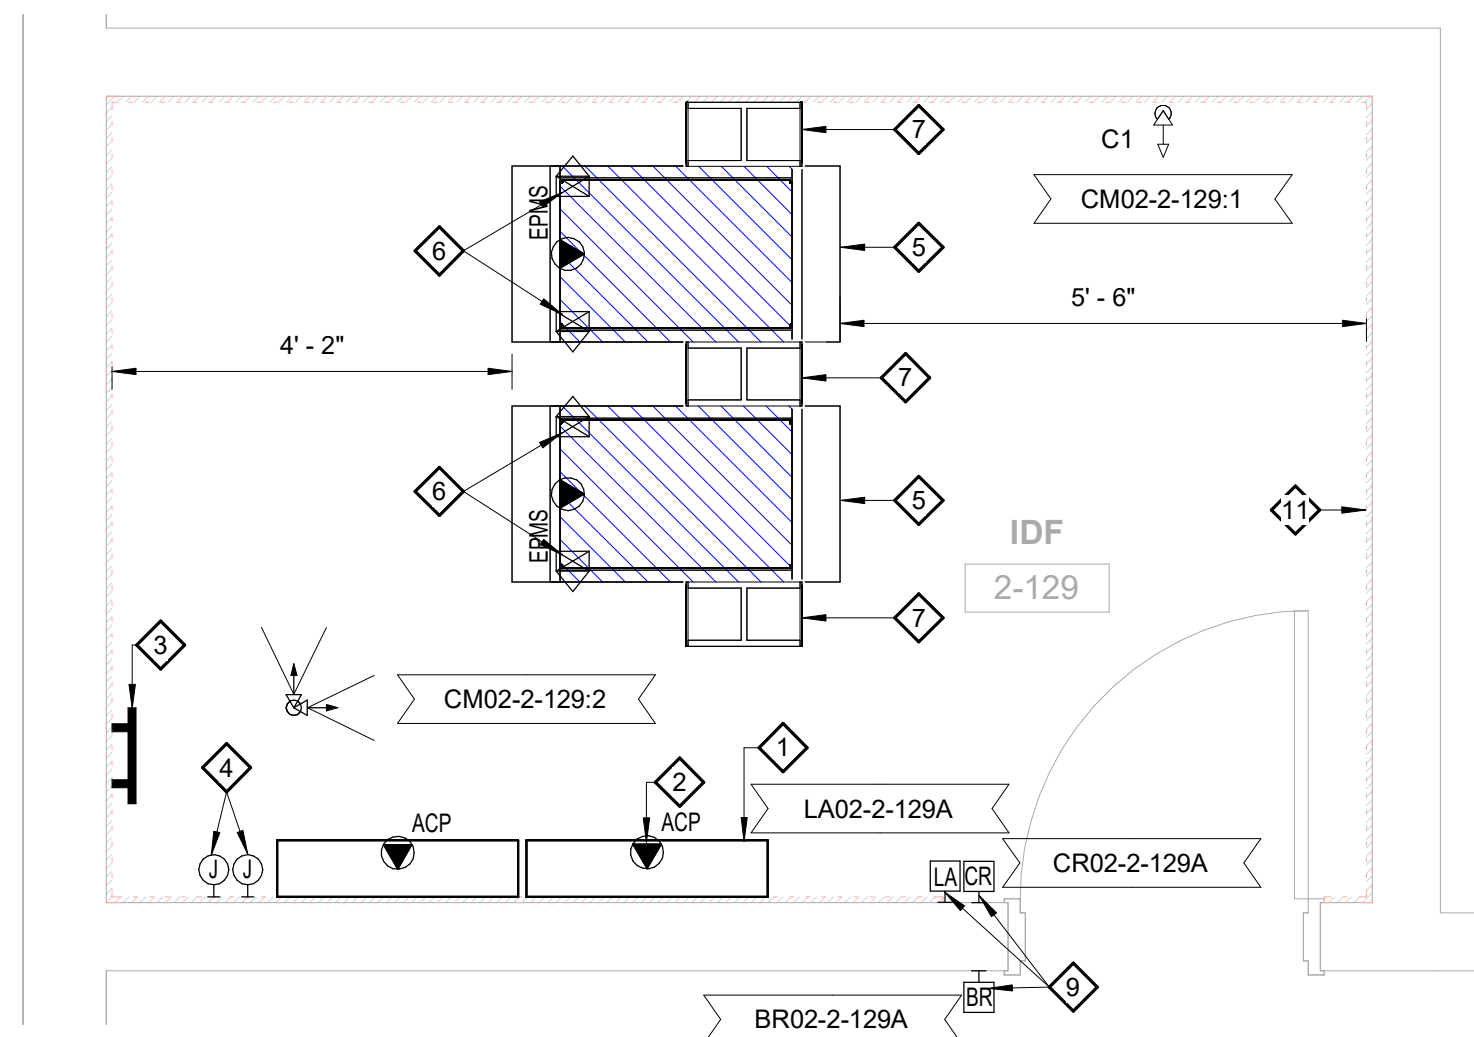

1 TECHNOLOGY - ENLARGED FLOOR PLAN - LEVEL 02 - IDF 2-129
SCALE 1/2" = 1'-0"

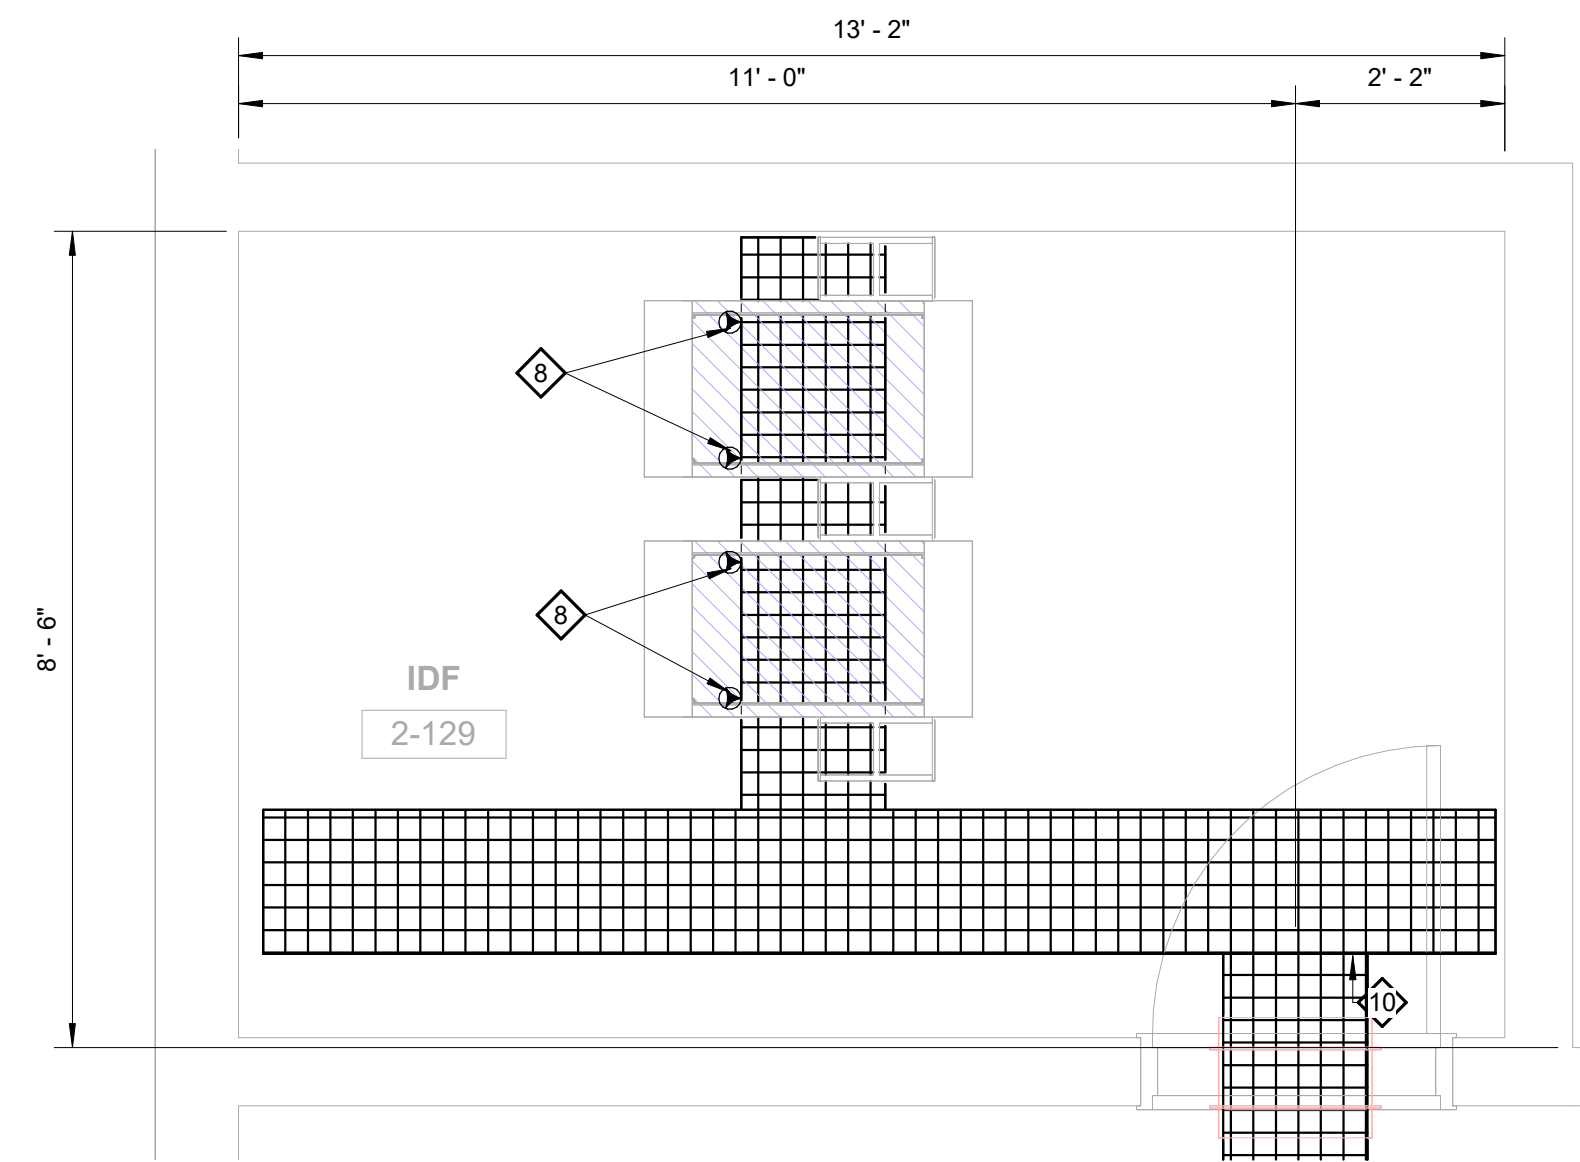

2 **TECHNOLOGY - CEILING PLAN - LEVEL 02 - IDF 2-129**
SCALE 1/2" = 1'-0"

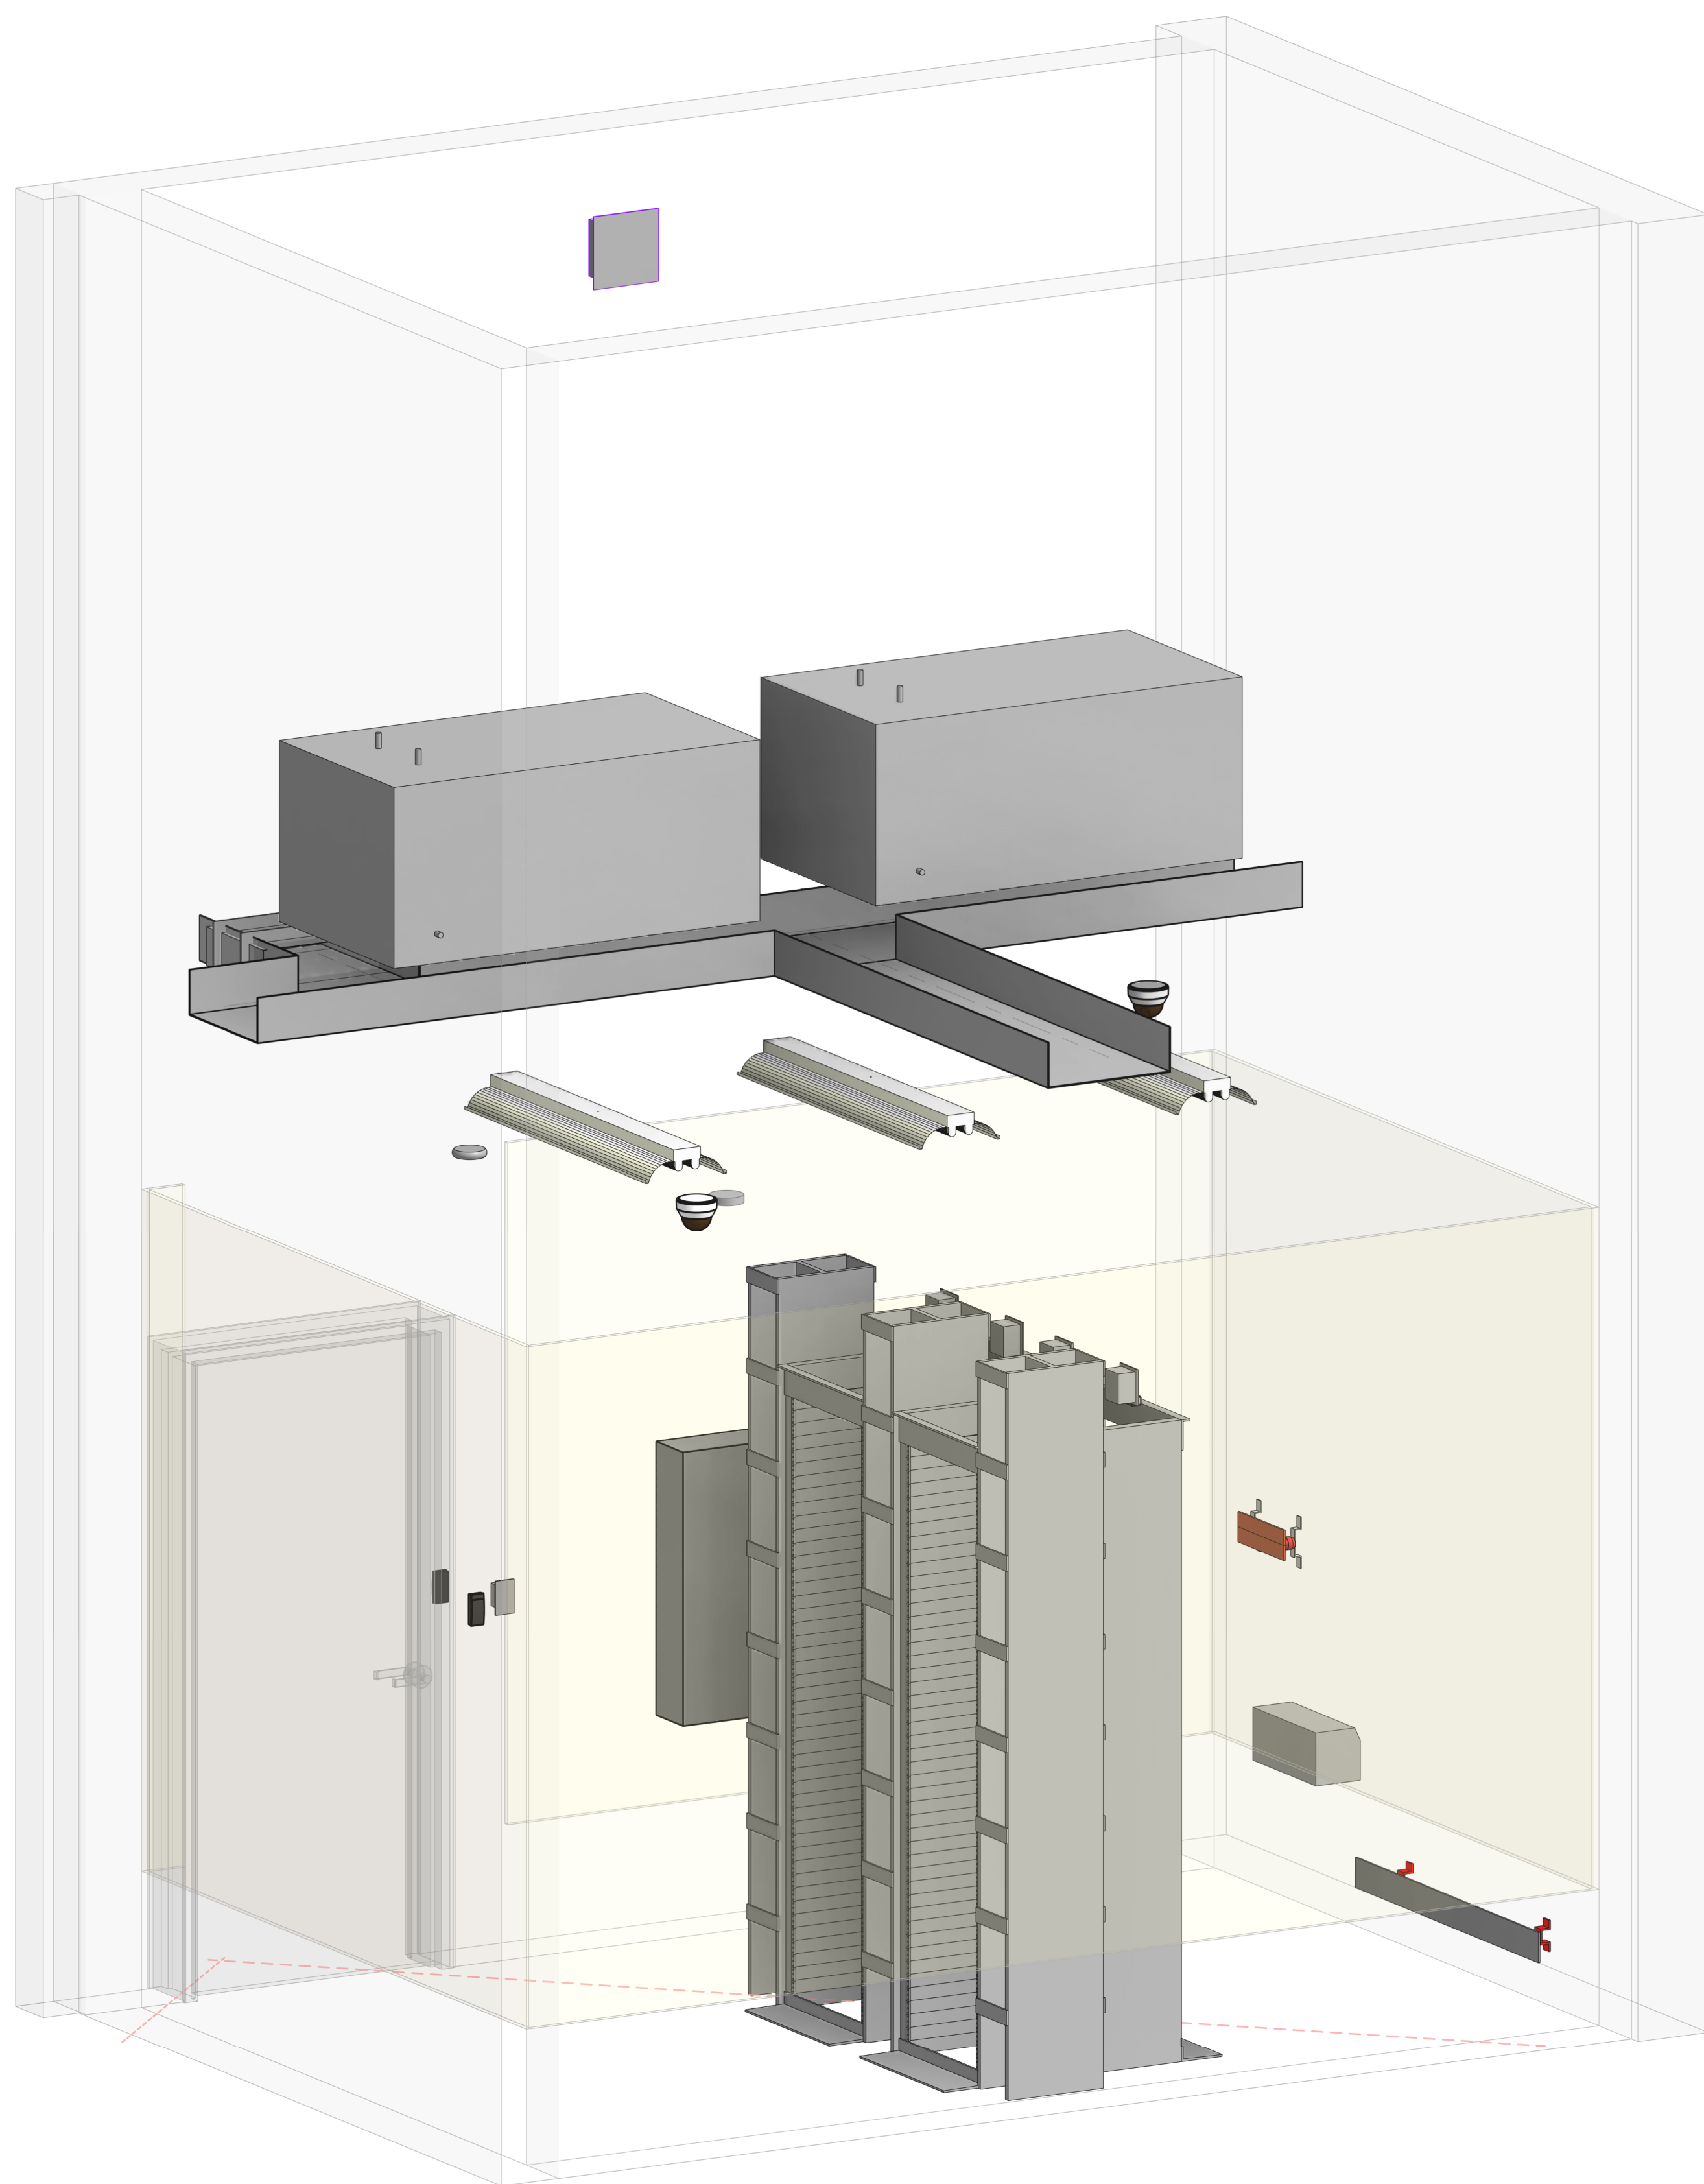

3 3D IDF 2-129
SCALE

		ISSUES
1	12/12/2025	SCHEMATIC DESIGN
2	01/23/2026	DESIGN DEVELOPMENT
3		
4		
5		
6		
7		
8		
9		
10		
11		
12		
13		

[illegible]

CORGAN
#1300, 20 N. Orange Ave., Orlando,
32801
214.244.8263
www.corgan.com

Serverfarm - ARK1 -
Technology
ISSUE FOR DD
CLARKSVILLE, AR

ENLARGED PLANS
- IDF 2-129

JOB 27583
SHEET

T05-16

GENERAL NOTES

EC SHALL PROVIDE (1) TELECOMMUNICATIONS GROUNDING BUSBAR (TGB) AND (1) ELECTRICAL GROUND BUS BAR (EGB) IN EACH MMIRID. BOND THE TGB TO THE EGB WITHIN THE SAME ROOM USING A LISTED JUMPER. EACH ROOM'S EGB/TGB SYSTEM SHALL BE BONDED TO THE BUILDING GROUNDING ELECTRODE SYSTEM (GEC) (UNDER DIVISION 26 ELECTRICAL SCHEMATIC, INSTALLATION, BONDING, AND LABELING SHALL COMPLY WITH TIA-607 AND NEC ARTICLE 250, SEE T00.01 GENERAL REQUIREMENTS SECTION 6.22 AND T00.20 ADDITIONAL COMMUNICATIONS REQUIREMENTS FOR FURTHER GROUNDING REQUIREMENTS. SEE ELECTRICAL DRAWINGS FOR DETAILS; WHERE REQUIREMENTS CONFLICT, THE ELECTRICAL DRAWINGS SHALL GOVERN. FINAL TERMINATION, CONTINUITY, AND TESTING BY ELECTRICAL CONTRACTOR.