


GENERAL NOTES:



- A. CONNECT NEW LIGHT FIXTURES IN CONTROL ROOMS TO EXISTING LIGHTING CIRCUIT SERVING THE SPACE.
- B. ONLY MRI RATED LIGHT FIXTURES WITH REMOTE DRIVERS CAN BE LOCATED INSIDE OF THE MRI ROOM. LOCATE REMOTE DRIVERS INSIDE OF THE EQUIPMENT ROOMS FOR EACH MRI. CABLING BETWEEN REMOTE DRIVERS AND FIXTURES INSIDE OF THE MRI ROOMS MUST GO THROUGH THE FILTER PANEL. SEE DETAIL 2 ON THIS SHEET.
- C. ALL ITEMS INSTALLED WITHIN THE RF-SHIELDING MUST BE NON-FERROUS.
- D. COORDINATE FINAL LIGHTING LOCATIONS WITH MRI EQUIPMENT PROVIDER. CONFIRM BELOW CEILING CABLE TRAY DOES NOT COVER UP THE CAN LIGHTS. ADJUST FINAL CAN LIGHT LOCATIONS AS NECESSARY.

KEYED NOTES:

- 1 DIMMER SWITCH FOR CONTROLLING THE CAN LIGHTS INSIDE OF THE MRI ROOM. COORDINATE FINAL LOCATION WITH OWNER.
- 2 ENCLOSURES FOR LED REMOTE DRIVERS SERVING MRI CAN LIGHTS. ME TYPE LIGHT FIXTURES REQUIRE THEIR OWN REMOTE DRIVER ENCLOSURE TO HOUSE THE DRIVER AND EMERGENCY BATTERY BACKUP. TYPE M LIGHT FIXTURES WILL SHARE A REMOTE DRIVER ENCLOSURE THAT CAN HOUSE THE REMAINING DRIVERS. COORDINATE LOCATIONS WITH MRI MANUFACTURER AND THE BELOW CEILING CABLE TRAY.
- 3 CONNECT NEW TYPE A AND AE LIGHT FIXTURES IN THIS ROOM TO THE EXISTING LIGHTING CIRCUIT AND CONTROLS IN THIS ROOM.
- 4 CONNECT NEW TYPE M AND ME LIGHT FIXTURE IN THIS ROOM TO THE EXISTING LIGHTING CIRCUIT THAT PREVIOUSLY POWERED THE LIGHTING IN THIS ROOM. SEE DETAIL 2 ON THIS SHEET FOR ADDITIONAL INFORMATION ON DRIVERS AND CONDUCTOR ROUTING INTO THE MRI ROOM. PROVIDE NEW CONTROLS AS INDICATED.
- 5 PROVIDE MRI IN USE LIGHTED SIGN. COORDINATE CONTROLS WITH MRI EQUIPMENT PROVIDER. MOUNT FIXTURE ABOVE THE DOORWAY, CENTERED WITH THE OPENING, AND AT A HEIGHT THAT THE FIXTURE DOES NOT HANG BELOW THE DOOR FRAME.
- 6 CONNECT NEW LIGHTING IN THE CONTROL ROOM TO THE EXISTING LIGHTING CIRCUIT THAT PREVIOUSLY POWERED THE LIGHTING IN THIS ROOM.

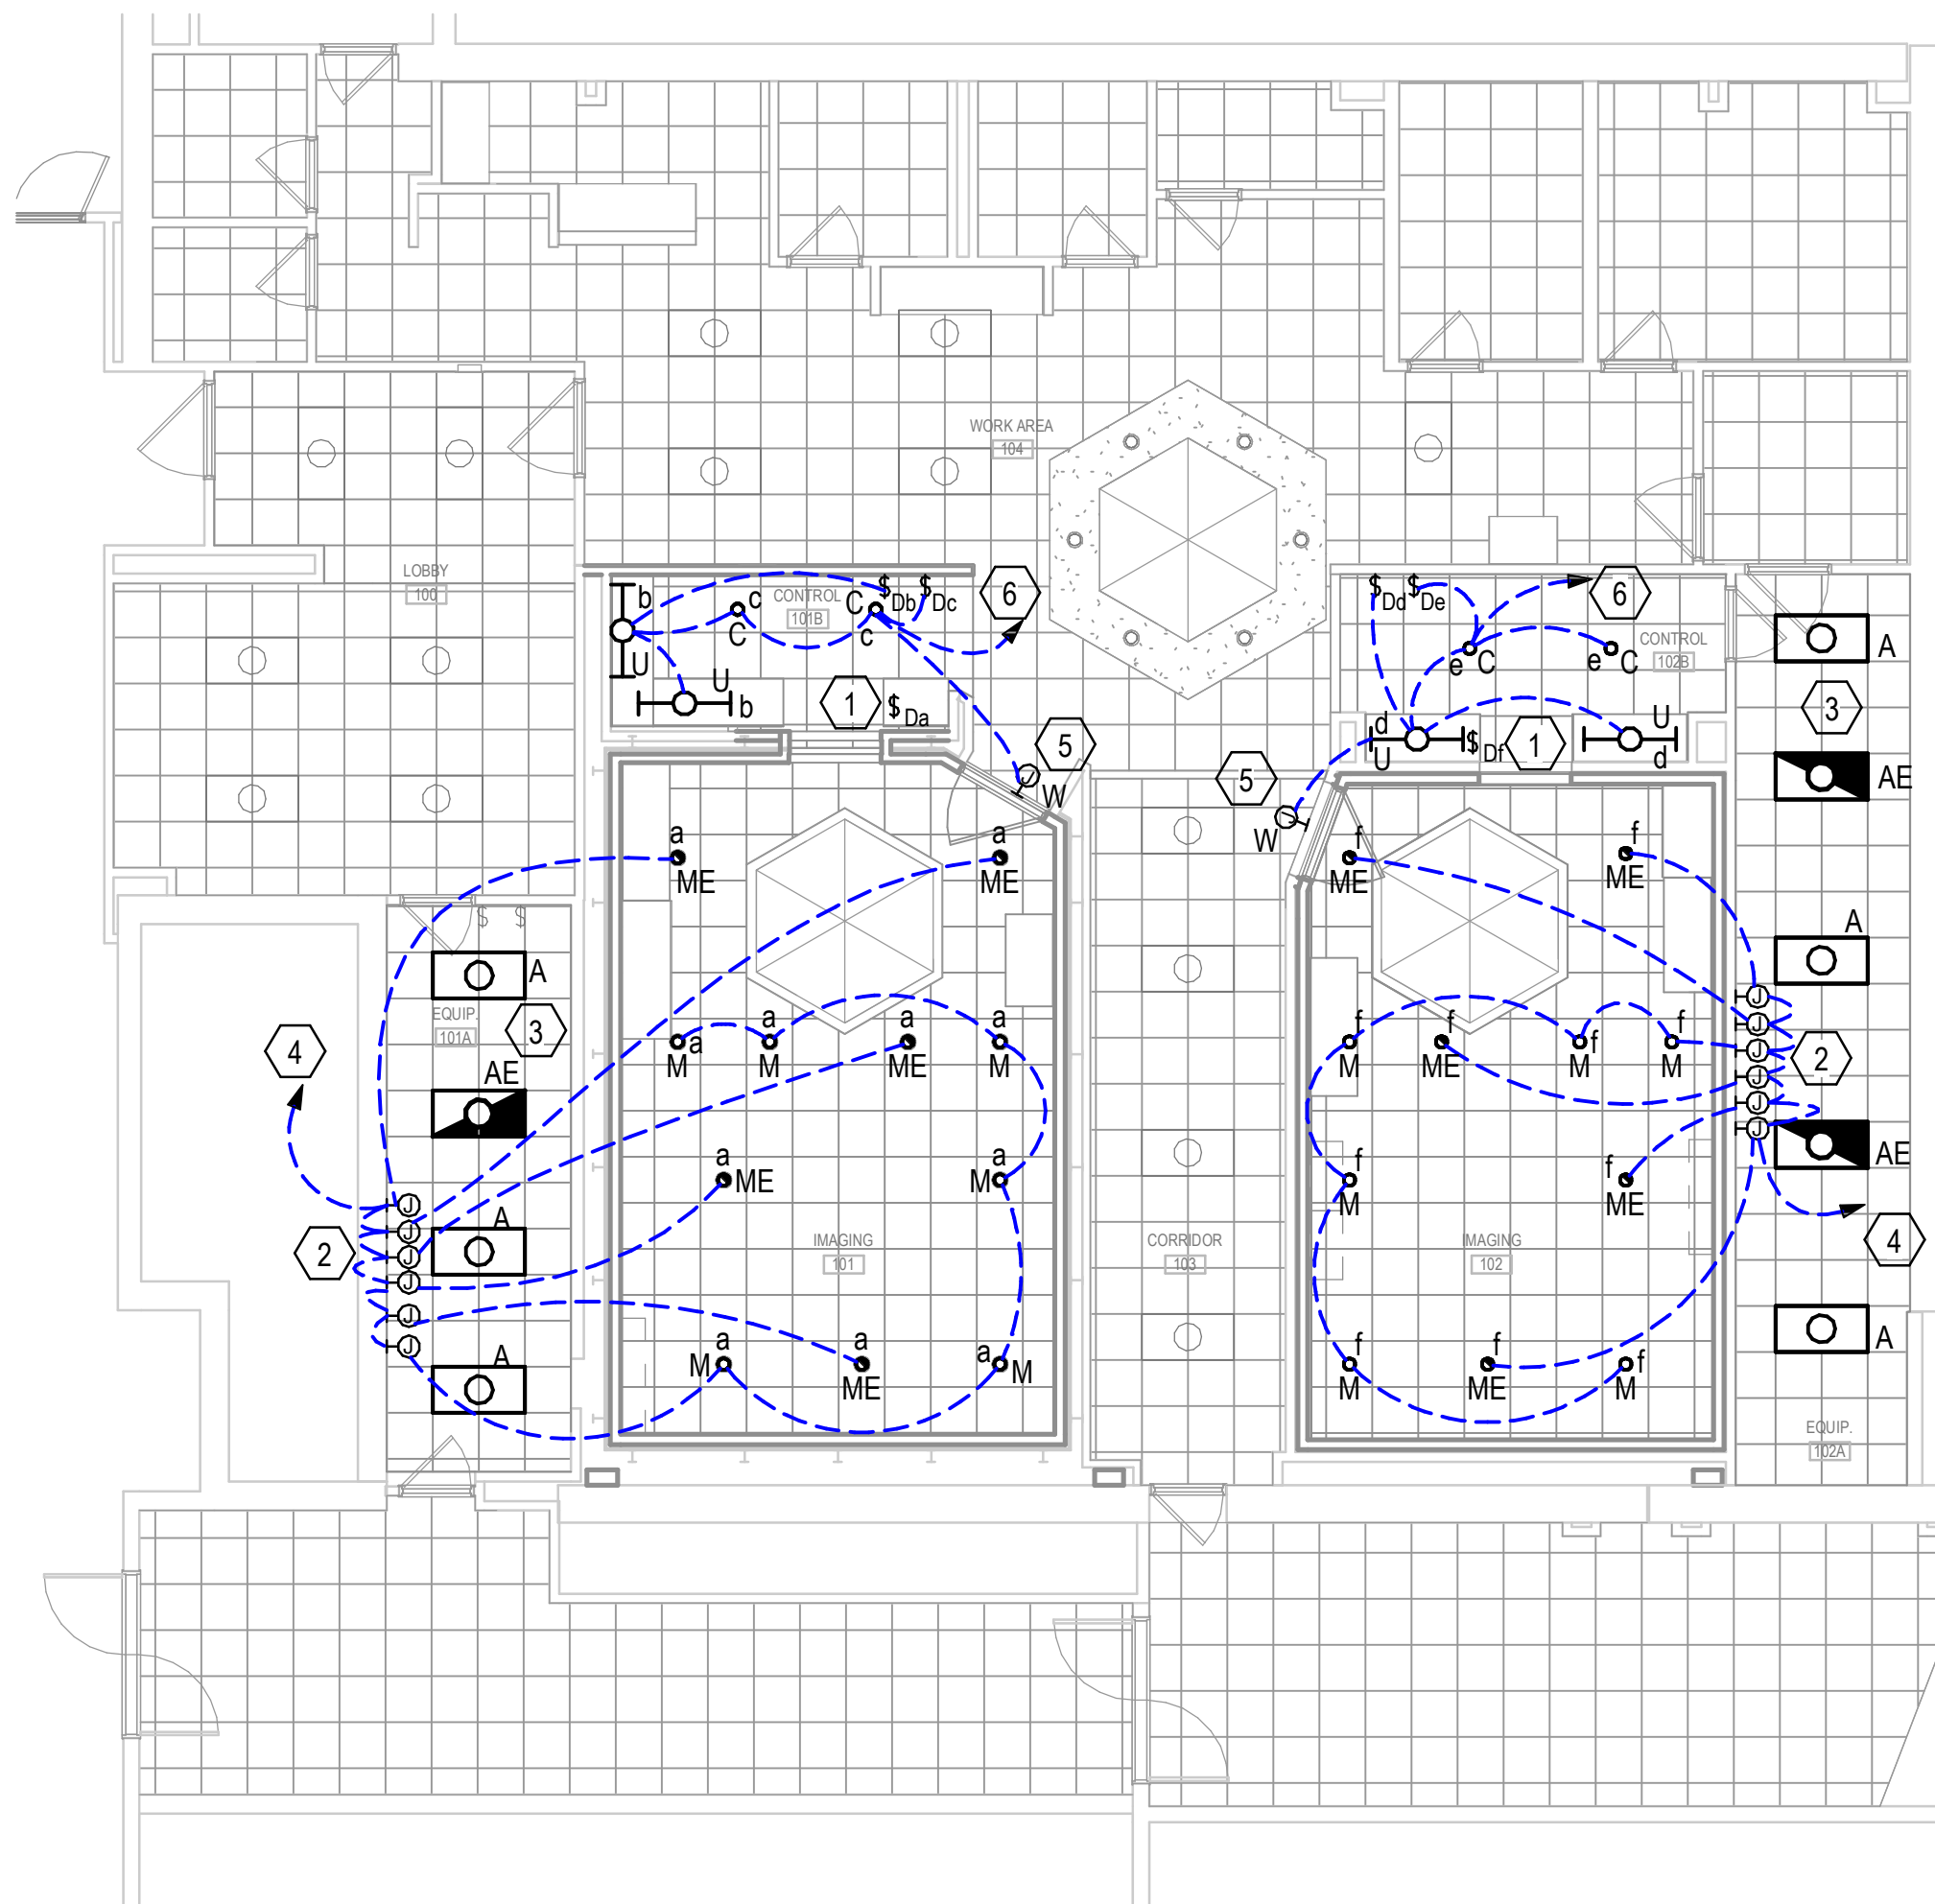

1 IMAGING SUITE LIGHTING PLAN
1/8" = 1'-0"

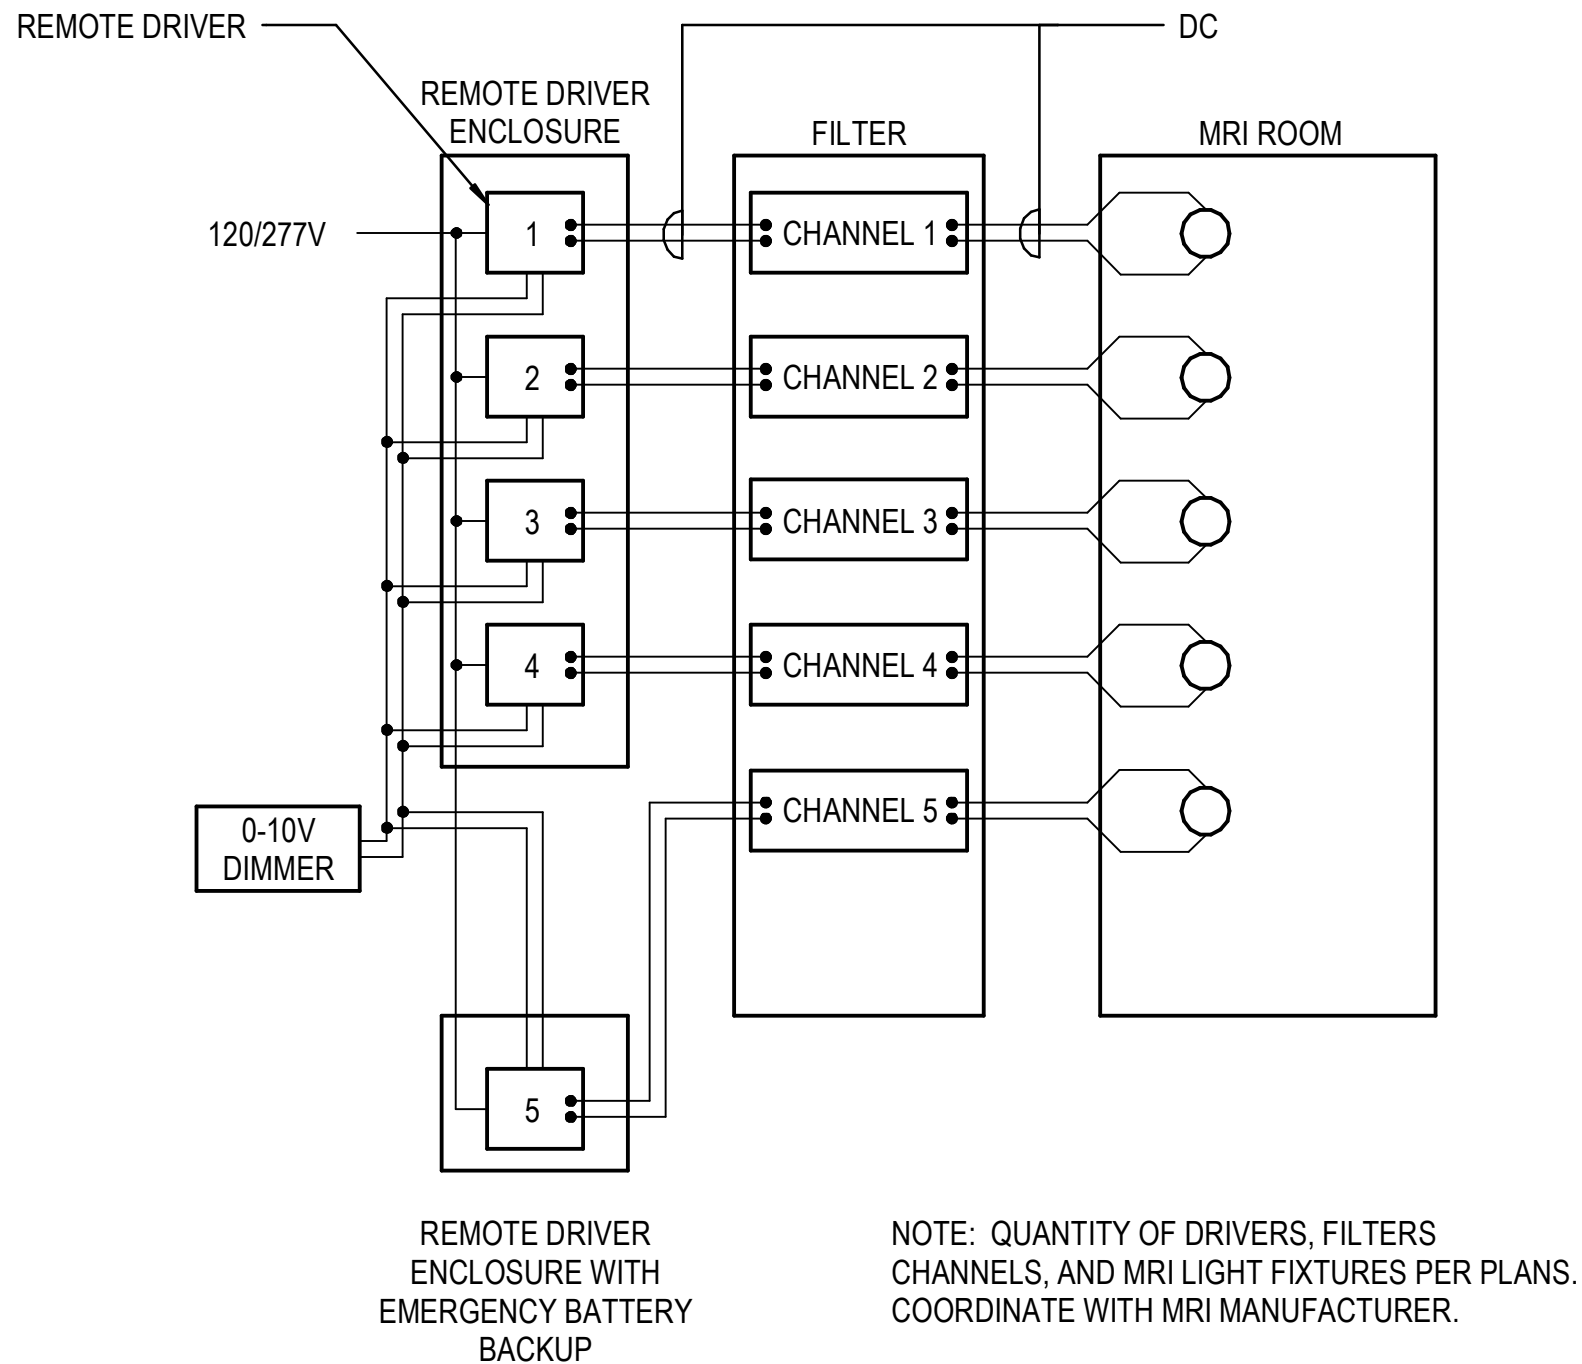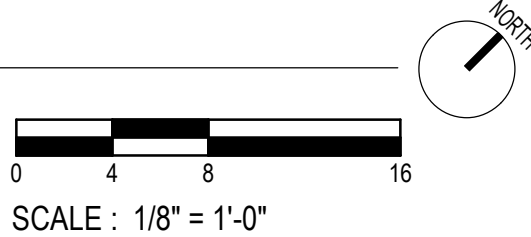

2 MRI LIGHTING SCHEMATIC
N.T.S.

CHI St. Vincent
Little Rock Infirmary
Imaging Suite Renovations

Design Phase



CONSTRUCTION
DOCUMENTS

Revisions

No. Date Description

1	08-25-2026	RB 001

Stamp

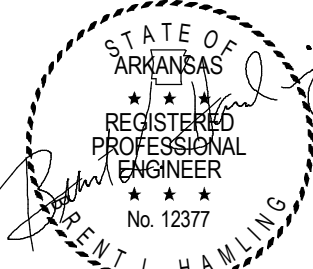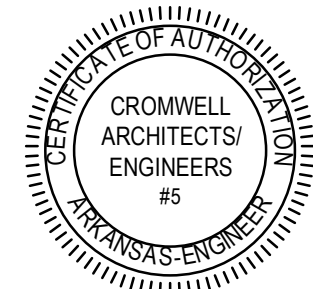

Notes

1. CROMWELL ARCHITECTS ENGINEERS, INC. ALL RIGHTS RESERVED
2. THIS SHEET DESIGNED FOR COLOR PRINTING. CRITICAL INFORMATION MAY BE LOST WITH BLACK AND WHITE PRINTING.

Project Number

2025-179

Issue Date

08-25-2026

Sheet Title

IMAGING SUITE LIGHTING
PLAN

Sheet Number

EL101