


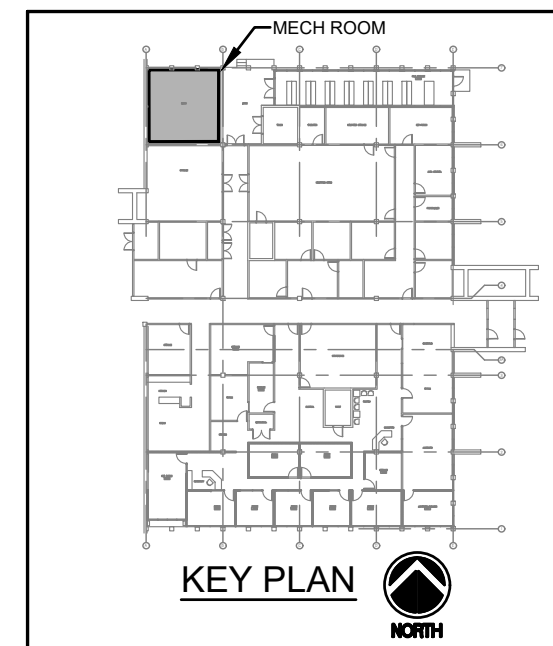


DEMOLITION KEYED NOTES



- [1] REMOVE EXISTING CHILLER. REMOVE ASSOCIATED REFRIGERANT, REFRIGERANT PIPING, AND WATER PIPING. LEAVE EXISTING CONCRETE HOUSEKEEPING PAD.
- [2] REMOVE EXISTING AIR COOLED CONDENSER AND ASSOCIATED REFRIGERANT PIPING.
- [3] REMOVE EXISTING PUMP & ALL ASSOCIATED PIPING. EXISTING CONCRETE PAD TO REMAIN FOR NEW PUMP.
- [4] RELOCATE EXISTING 5-TON CONDENSING UNIT. REMOVE PORTION OF REFRIGERANT PIPING AS REQUIRED FOR NEW INSTALLATION. RELOCATE CONTROL WIRING. SEE NEW PLAN.
- [5] REMOVE AND REPLACE EXISTING DDC CONTROLS PANEL AS REQUIRED. COORDINATE WITH CONTROLS CONTRACTOR.
- [6] REMOVE EXISTING AIR SEPARATOR & EXPANSION TANK SUSPENDED FROM STRUCTURE.
- [7] REMOVE ALL REFRIGERANT PIPING. CAP ALL PIPES THAT COME UP OUT OF FLOOR INSIDE MECHANICAL ROOM AND THAT COME UP OUT OF THE GROUND OUTSIDE AT THE CONDENSERS.
- [8] REMOVE ALL 4" CHILLED WATER PIPING IN MECHANICAL ROOM BACK TO HERE. SEE NEW PLAN FOR NEW PIPING CONNECTION.

DEMOLITION GENERAL NOTES:

1. ITEMS SHOWN DASHED ON THIS PLAN ARE EXISTING ITEMS TO BE REMOVED UNLESS NOTED OTHERWISE.
2. FIELD VERIFY EXACT SIZE AND LOCATION OF ALL EXISTING ITEMS SHOWN ON THIS PLAN.

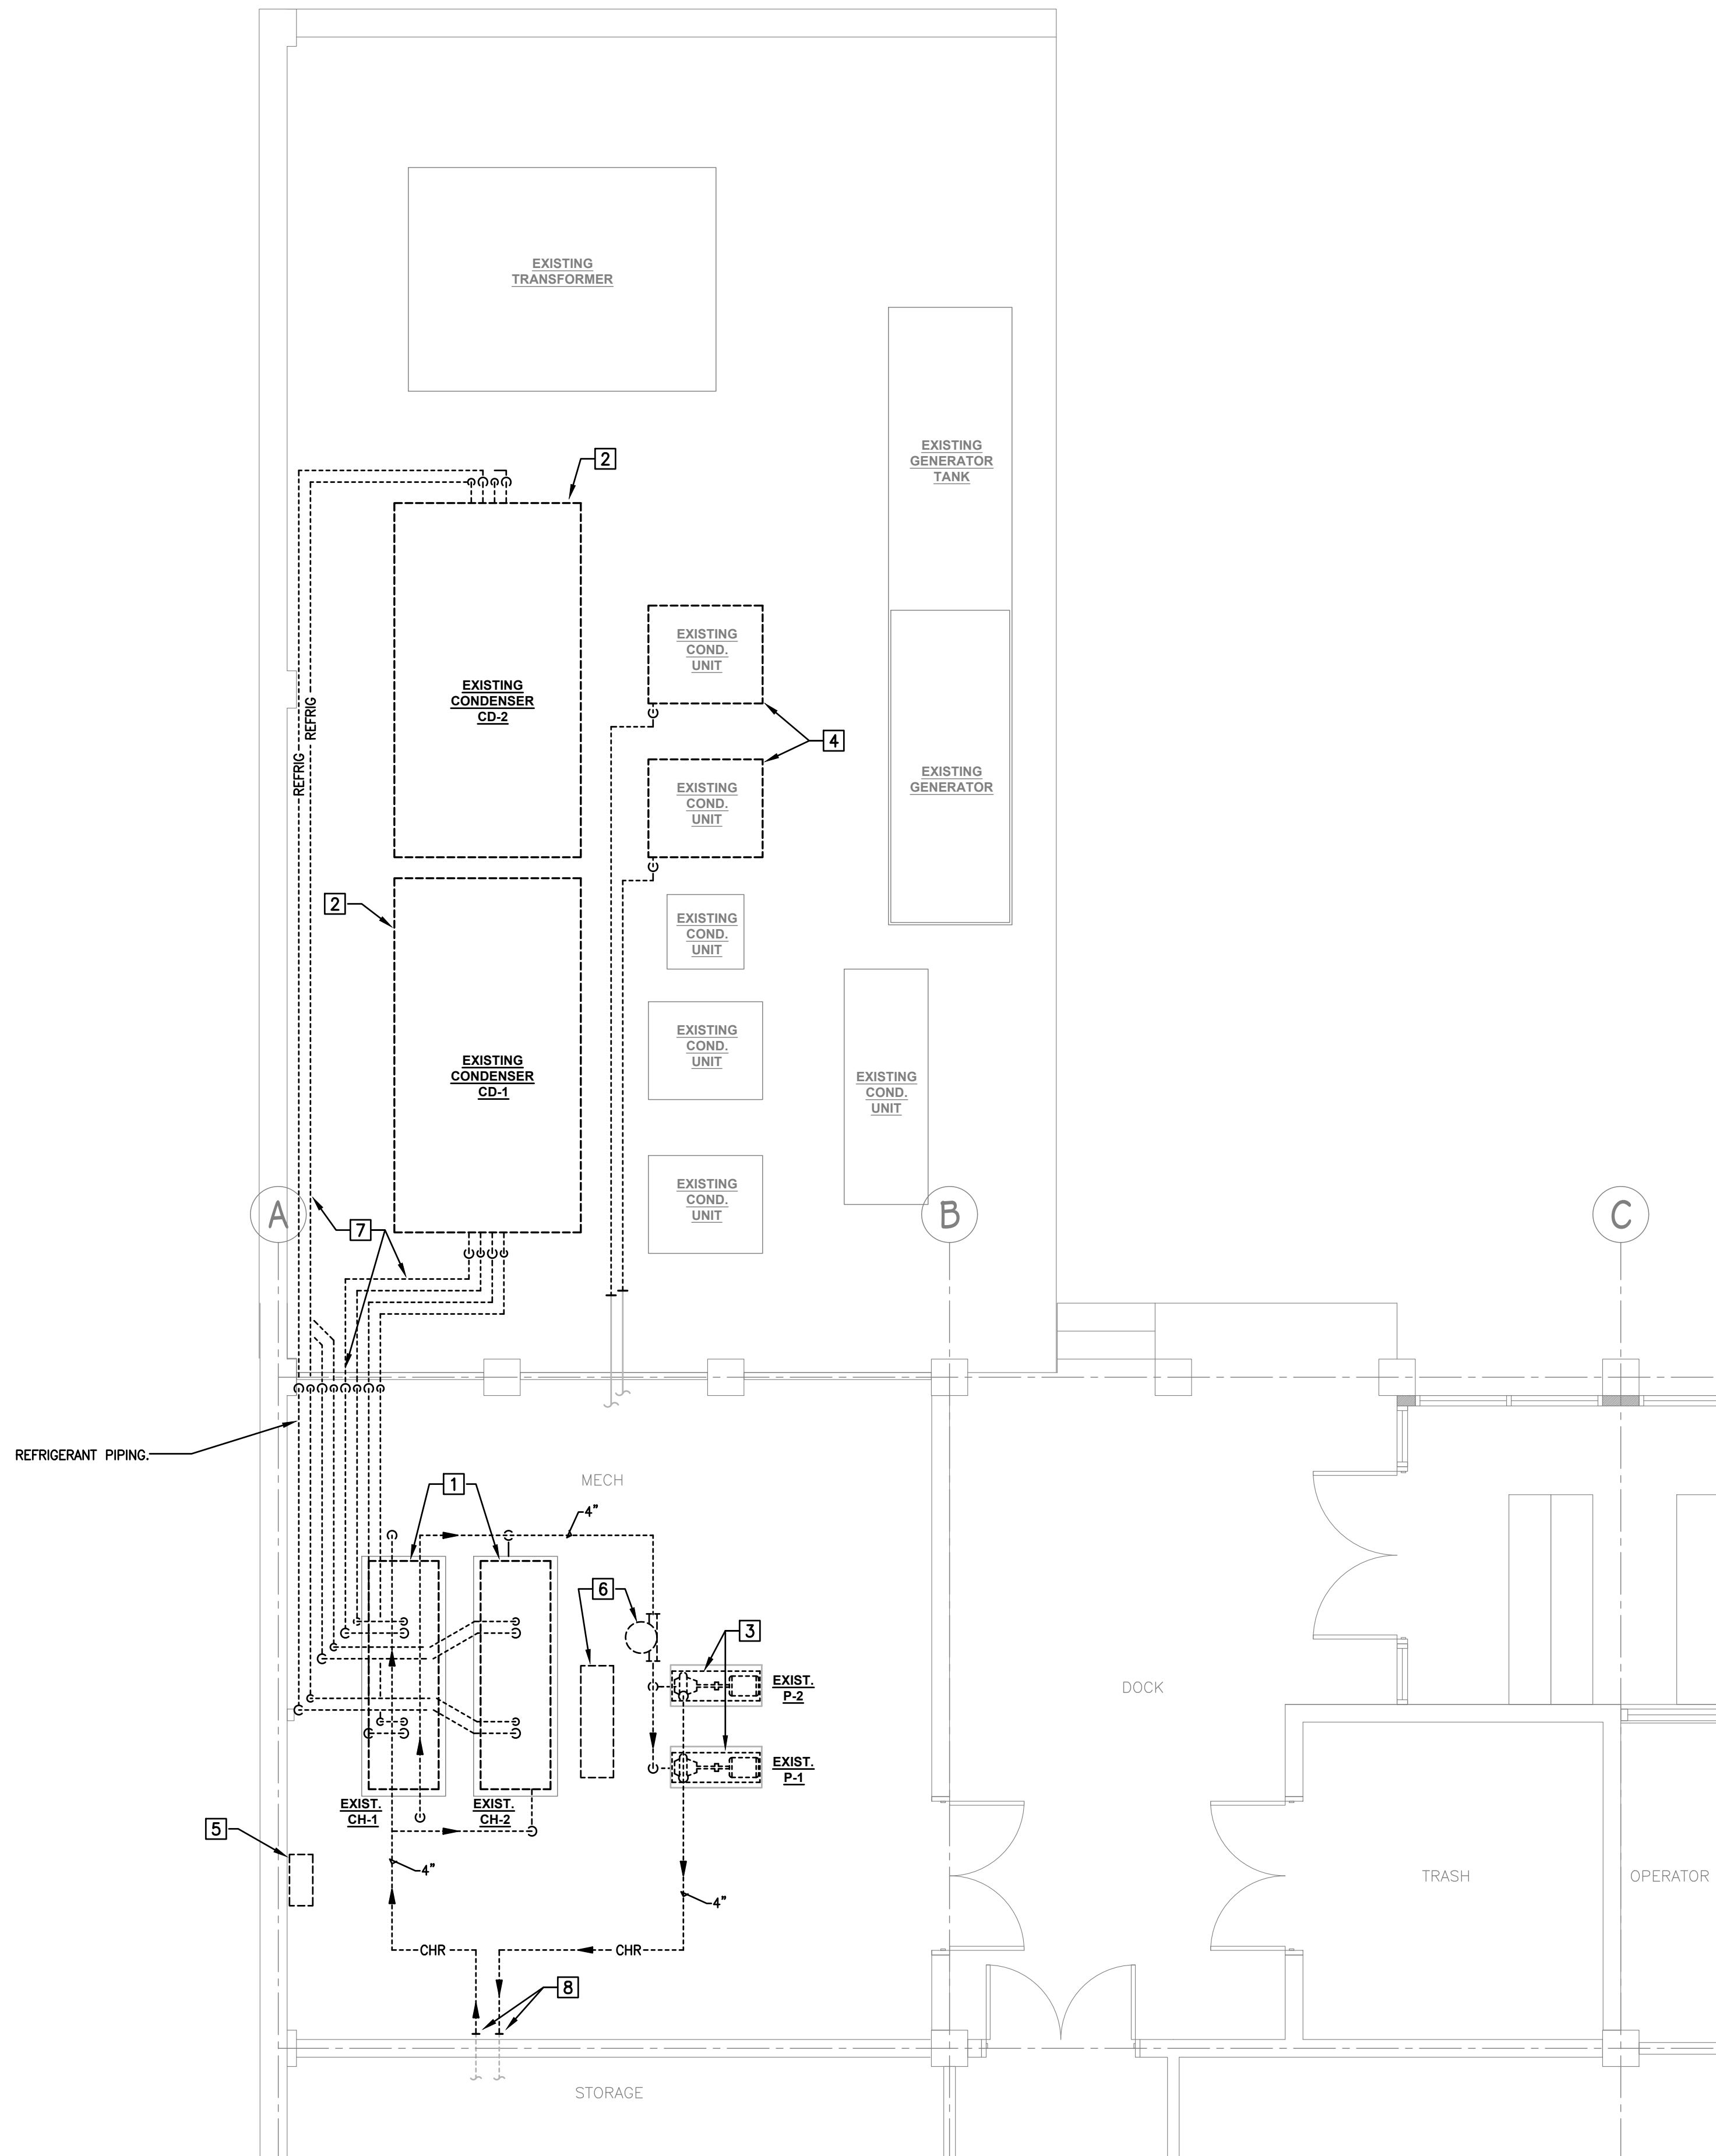

1 DEMOLITION PLAN - PARTIAL GROUND FLOOR - MECHANICAL
SCALE : 1/4" = 1'-0"

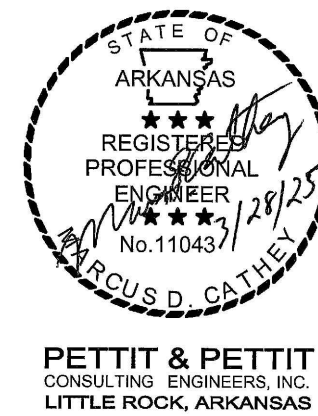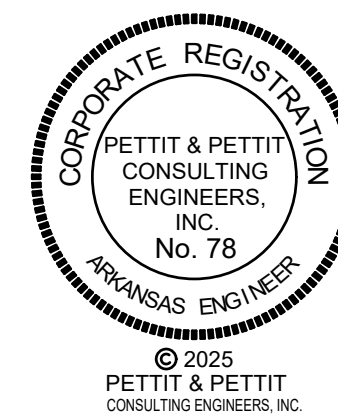

© 2025
PETTIT & PETTIT
CONSULTING ENGINEERS, INC.

PETTIT & PETTIT
CONSULTING ENGINEERS, INC.
LITTLE ROCK, ARKANSAS